

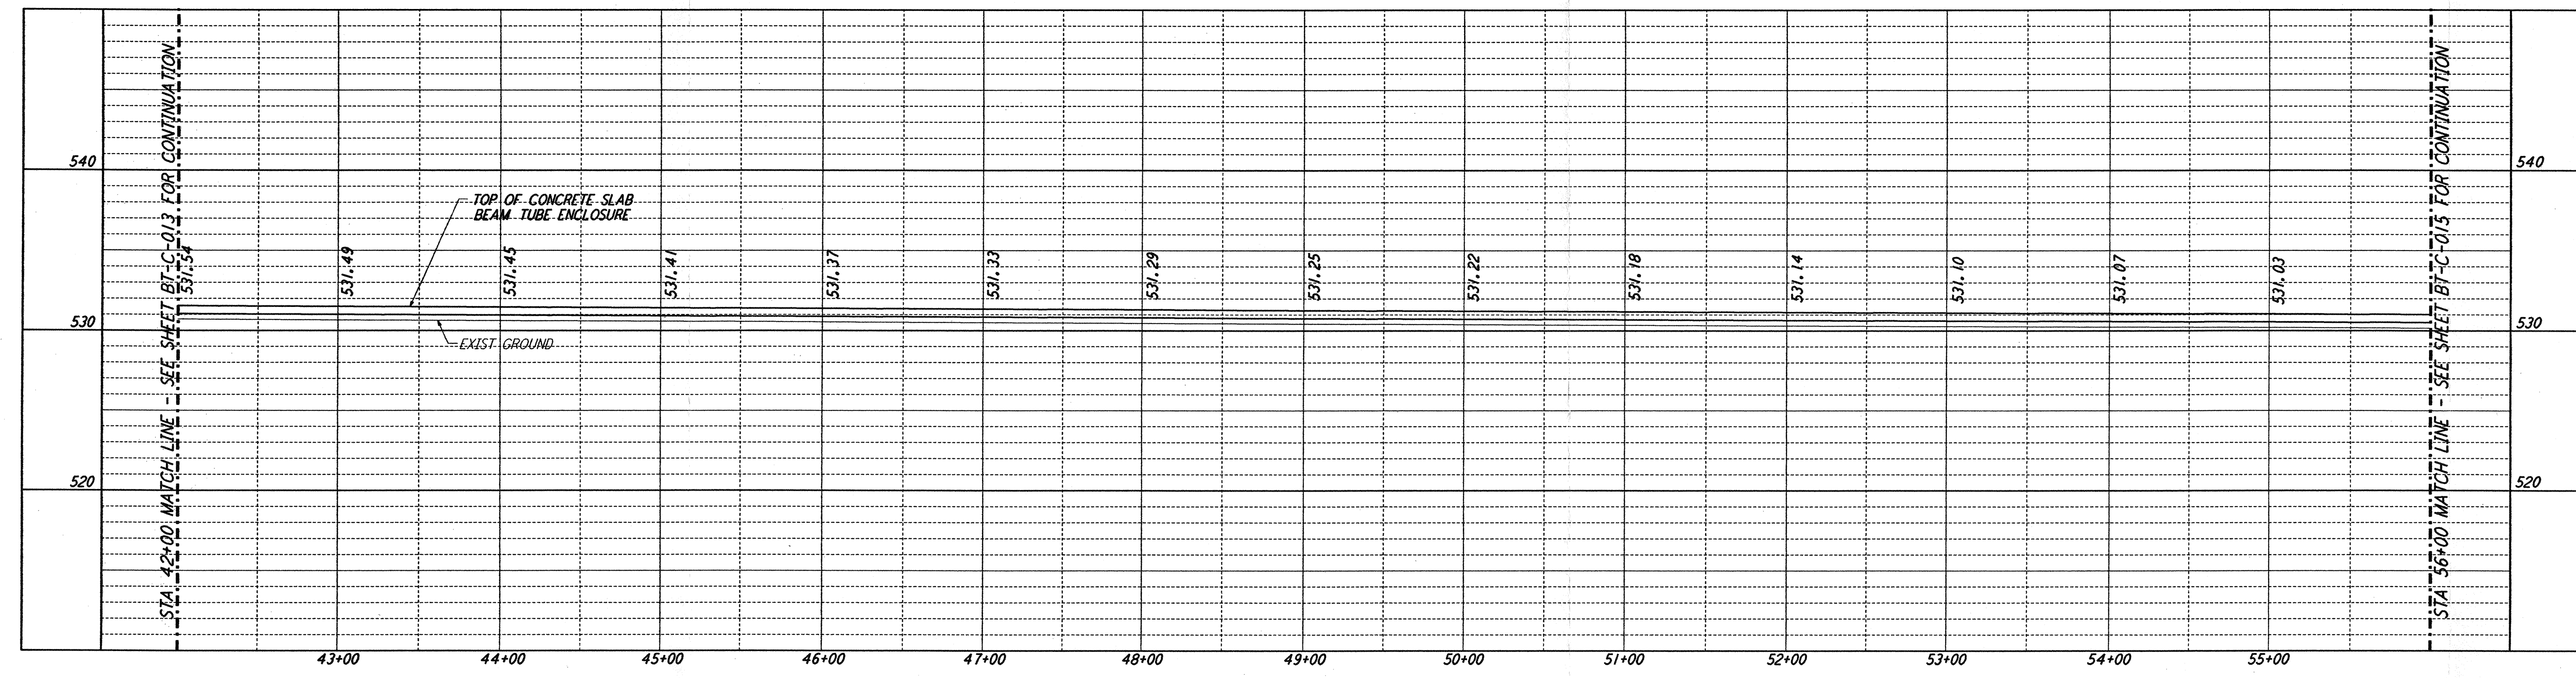



This document and the design it covers are the property of **PARSONS**. They are loaned only with the borrower's expressed written agreement that they will not be reproduced, copied, loaned, exhibited, or used in any other way, except by written consent from **PARSONS** to the borrower.

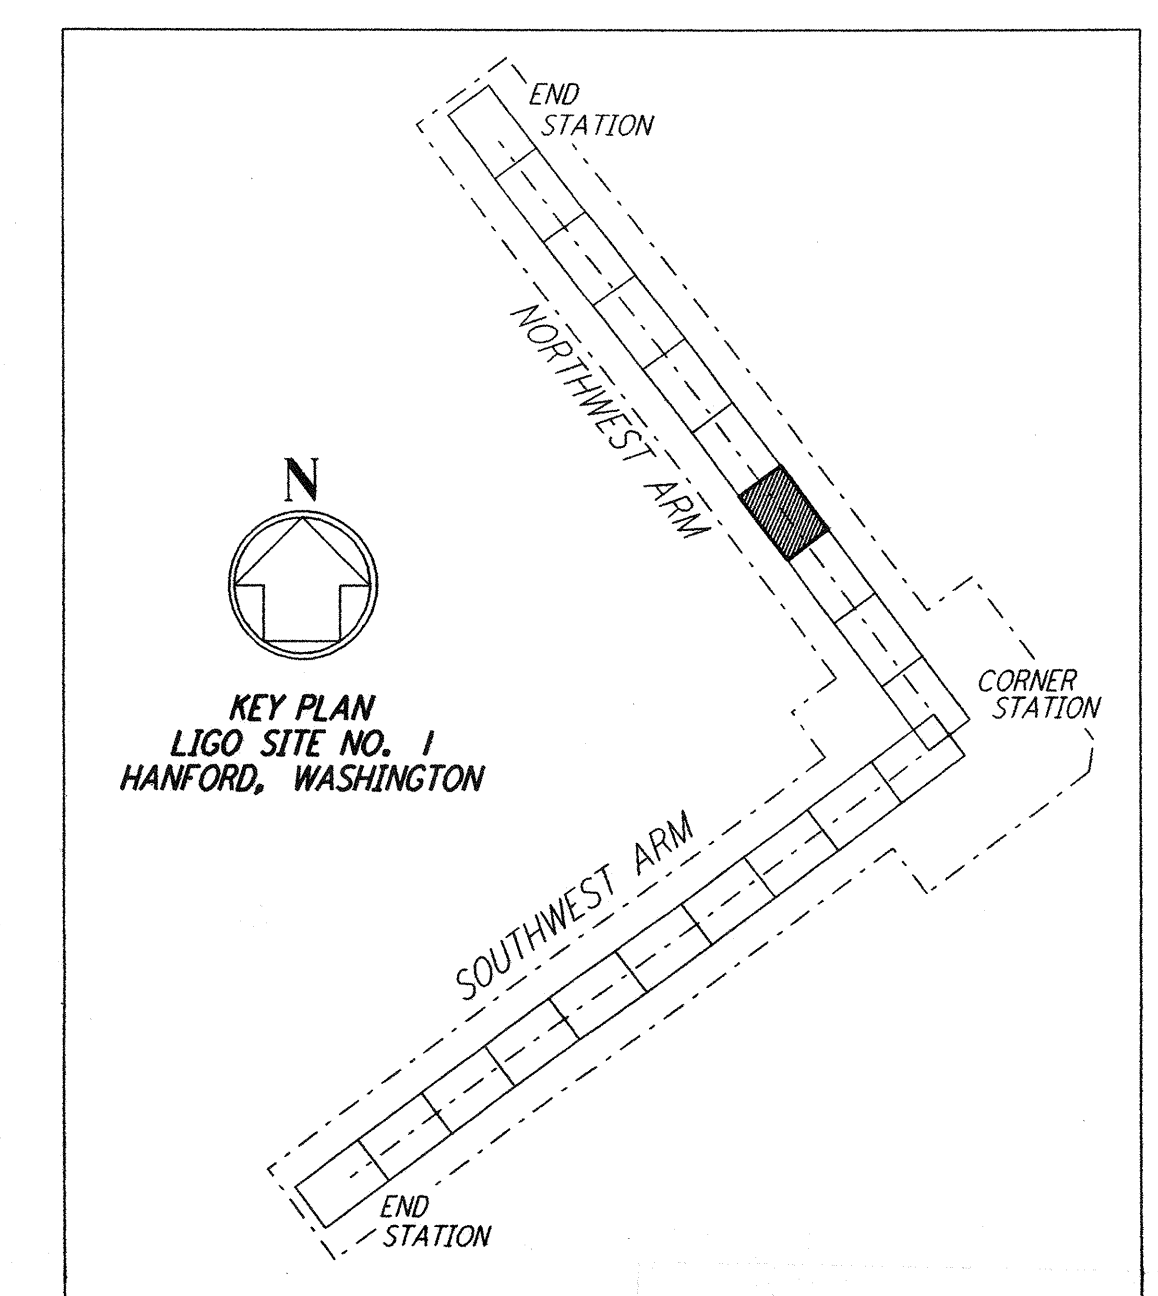

- NOTES:**
- SEE SHEET BT-C-002 FOR GENERAL NOTES, LEGEND AND ABBREVIATIONS.
 - SEE SHEET BT-C-004 FOR TYPICAL SECTIONS AND DETAILS.

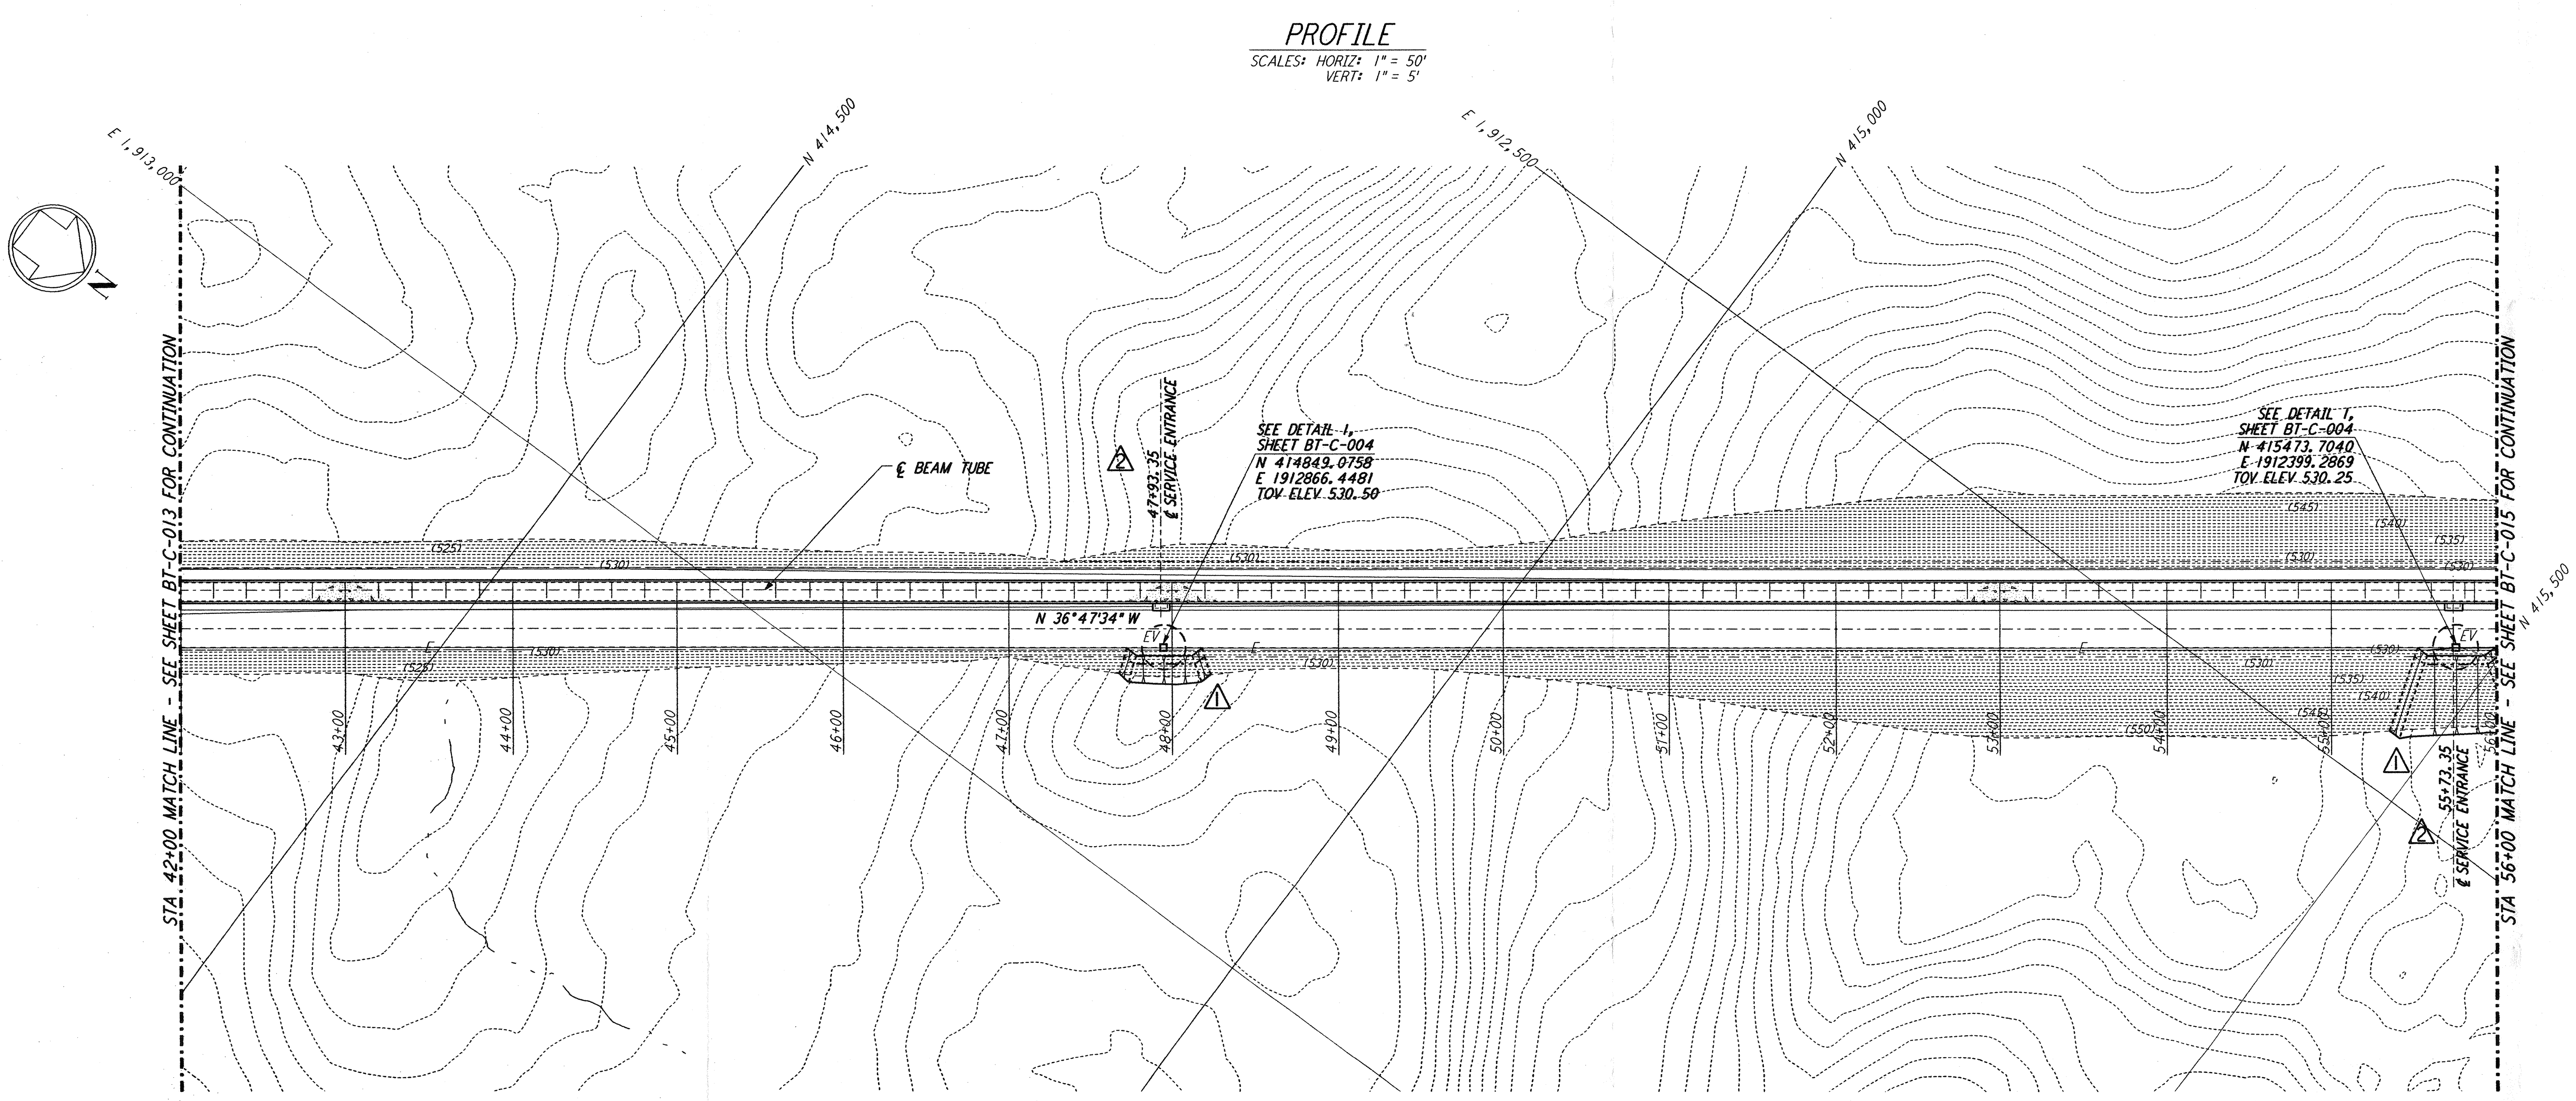

LIGO-D960169-03-O

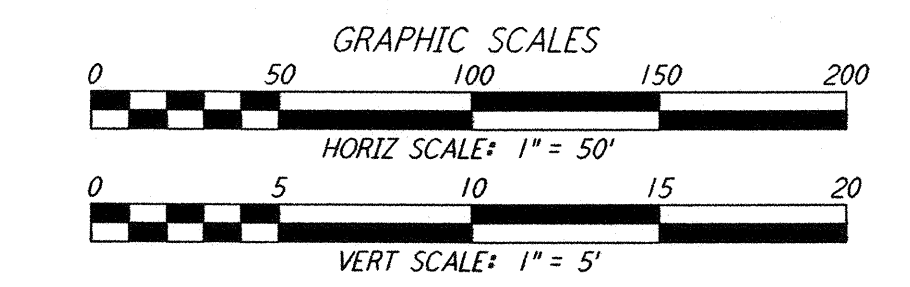

NO.	DATE	BY	CHKD	ENGR	PROJ	DESCRIPTION
3	1-22-99	MEI	--	--	MDW	ISSUED FOR AS BUILT
2	5-10-96	WRB	TDM	JB	MDW	REVISED BEAM TUBE SERVICE ENTRANCES
1	2-29-96	WRB	TDM	JB	MDW	CHANGE ORDER NO. 2

ISSUED FOR CONSTRUCTION
 DRAWN WRB 1-19-96
 CHECKED MP 1-19-96
 ENGINEER JB 1-19-96
 PROJ MDW 1-19-96

AS-BUILT DRAWINGS

PARSONS
 100 WEST WALNUT STREET
 PASADENA, CALIFORNIA

LIGO
 CALIFORNIA INSTITUTE OF TECHNOLOGY
 MASSACHUSETTS INSTITUTE OF TECHNOLOGY

LASER INTERFEROMETER GRAVITATIONAL-WAVE OBSERVATORY BTE SITEWORK & FABRICATION - HANFORD, WA

CIVIL NORTHWEST ARM PLAN AND PROFILE STA 42+00 TO STA 56+00

SCALE: AS NOTED
 CONTRACT NUMBER: PP150969
 PROJECT NUMBER: 8094

BT-C-014