


This document and the design it covers are the property of PARSONS. They are loaned only with the borrower's expressed written agreement that they will not be reproduced, copied, loaned, exhibited, or used in any other way, except by written consent from PARSONS to the borrower.

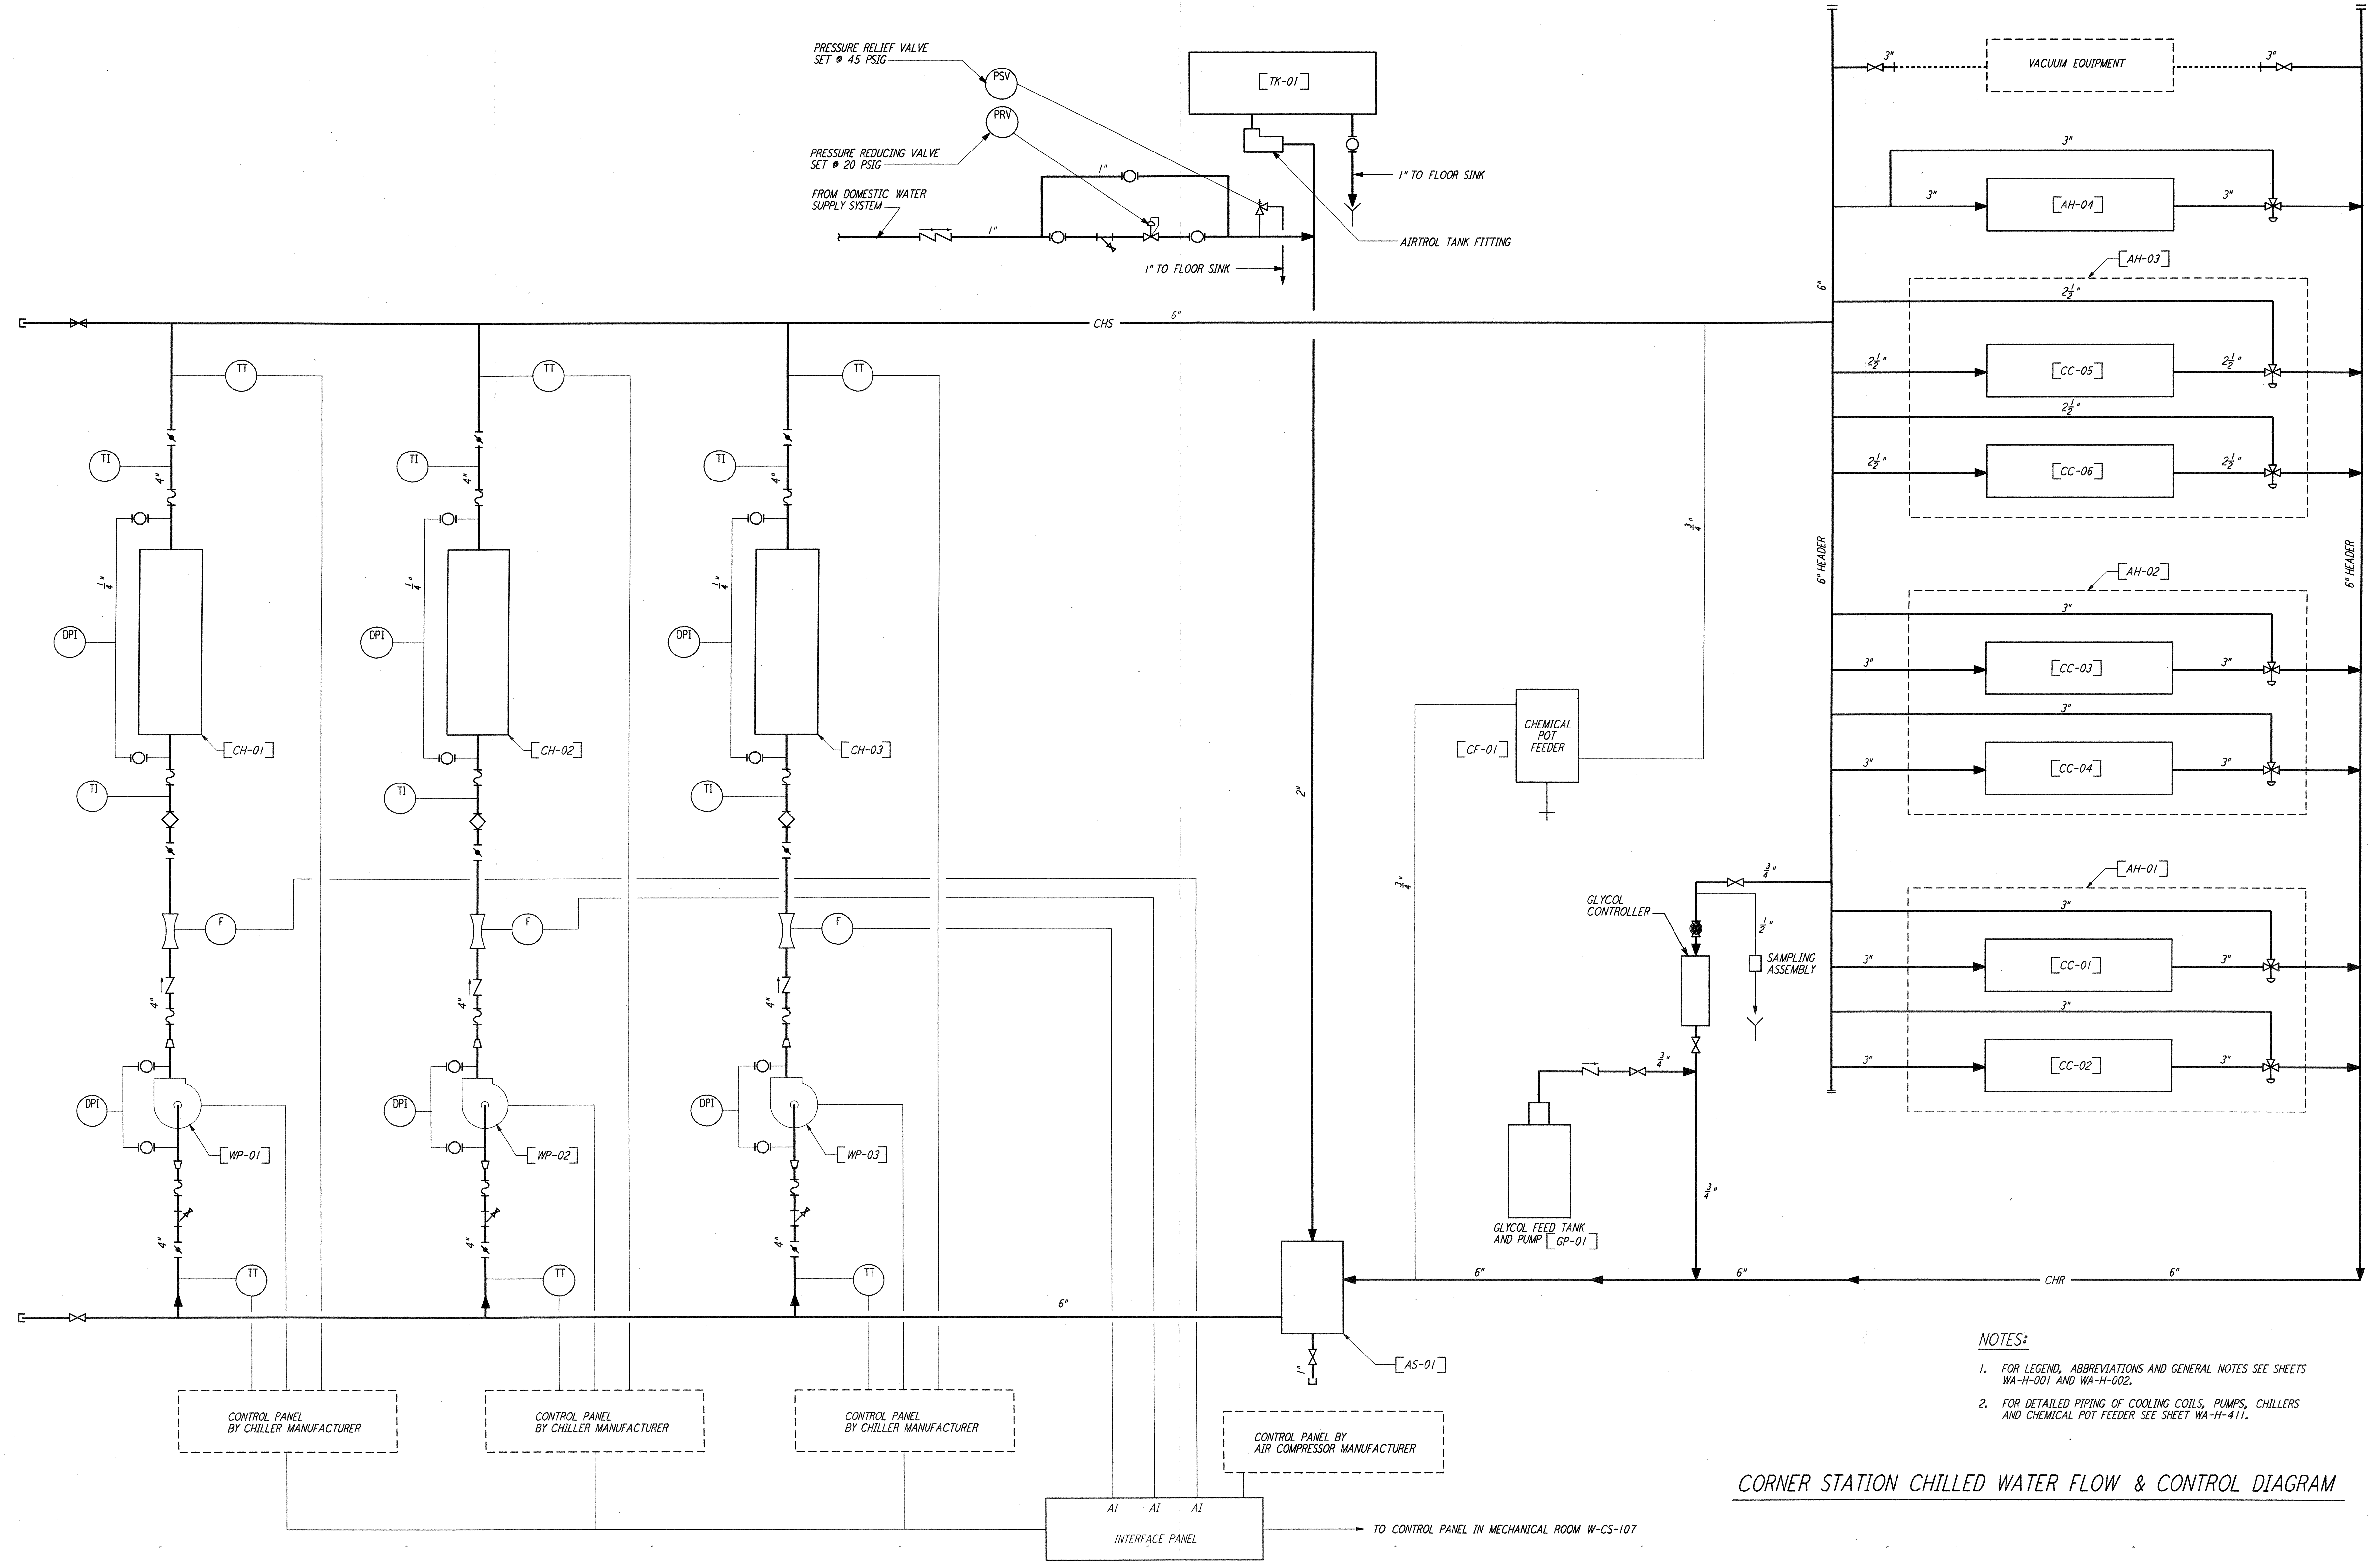

- NOTES:**
- FOR LEGEND, ABBREVIATIONS AND GENERAL NOTES SEE SHEETS WA-H-001 AND WA-H-002.
 - FOR DETAILED PIPING OF COOLING COILS, PUMPS, CHILLERS AND CHEMICAL POT FEEDER SEE SHEET WA-H-411.

CORNER STATION CHILLED WATER FLOW & CONTROL DIAGRAM

NO.	DATE	BY	CHKD	ENGR	PROJ	DESCRIPTION
1	5-15-98	CP	AA	AA	MDW	ISSUED FOR AS-BUILT

ISSUED FOR CONSTRUCTION
 DRAWN CLP 6-24-96
 CHECKED ME 7/3/96
 ENGINEER AA 7/13/96
 PROJ MDW 7/6/96

AS-BUILT DRAWINGS



LIGO-D960354-01-0

LASER INTERFEROMETER GRAVITATIONAL-WAVE OBSERVATORY SITE NO. 1 - HANFORD, WASHINGTON

TITLE	SCALE	CONTRACT NUMBER	PROJECT NUMBER								
HVAC CORNER STATION CHILLED WATER FLOW DIAGRAM	NONE	PP150969	8094								
SHEET NUMBER	REVISIONS										
WA-H-121	<table border="1"> <tr> <td>NO.</td> <td>DATE</td> <td>BY</td> <td>DESCRIPTION</td> </tr> <tr> <td> </td> <td> </td> <td> </td> <td> </td> </tr> </table>			NO.	DATE	BY	DESCRIPTION				
NO.	DATE	BY	DESCRIPTION								