


NOTES:

1. FOR LEGEND, ABBREVIATIONS AND GENERAL NOTES SEE SHEETS WA-H-001 AND WA-H-002.
2. SEE INPUT/OUTPUT SUMMARY SHEET WA-H-541 FOR ALARMS AND EQUIPMENT CONTROL.

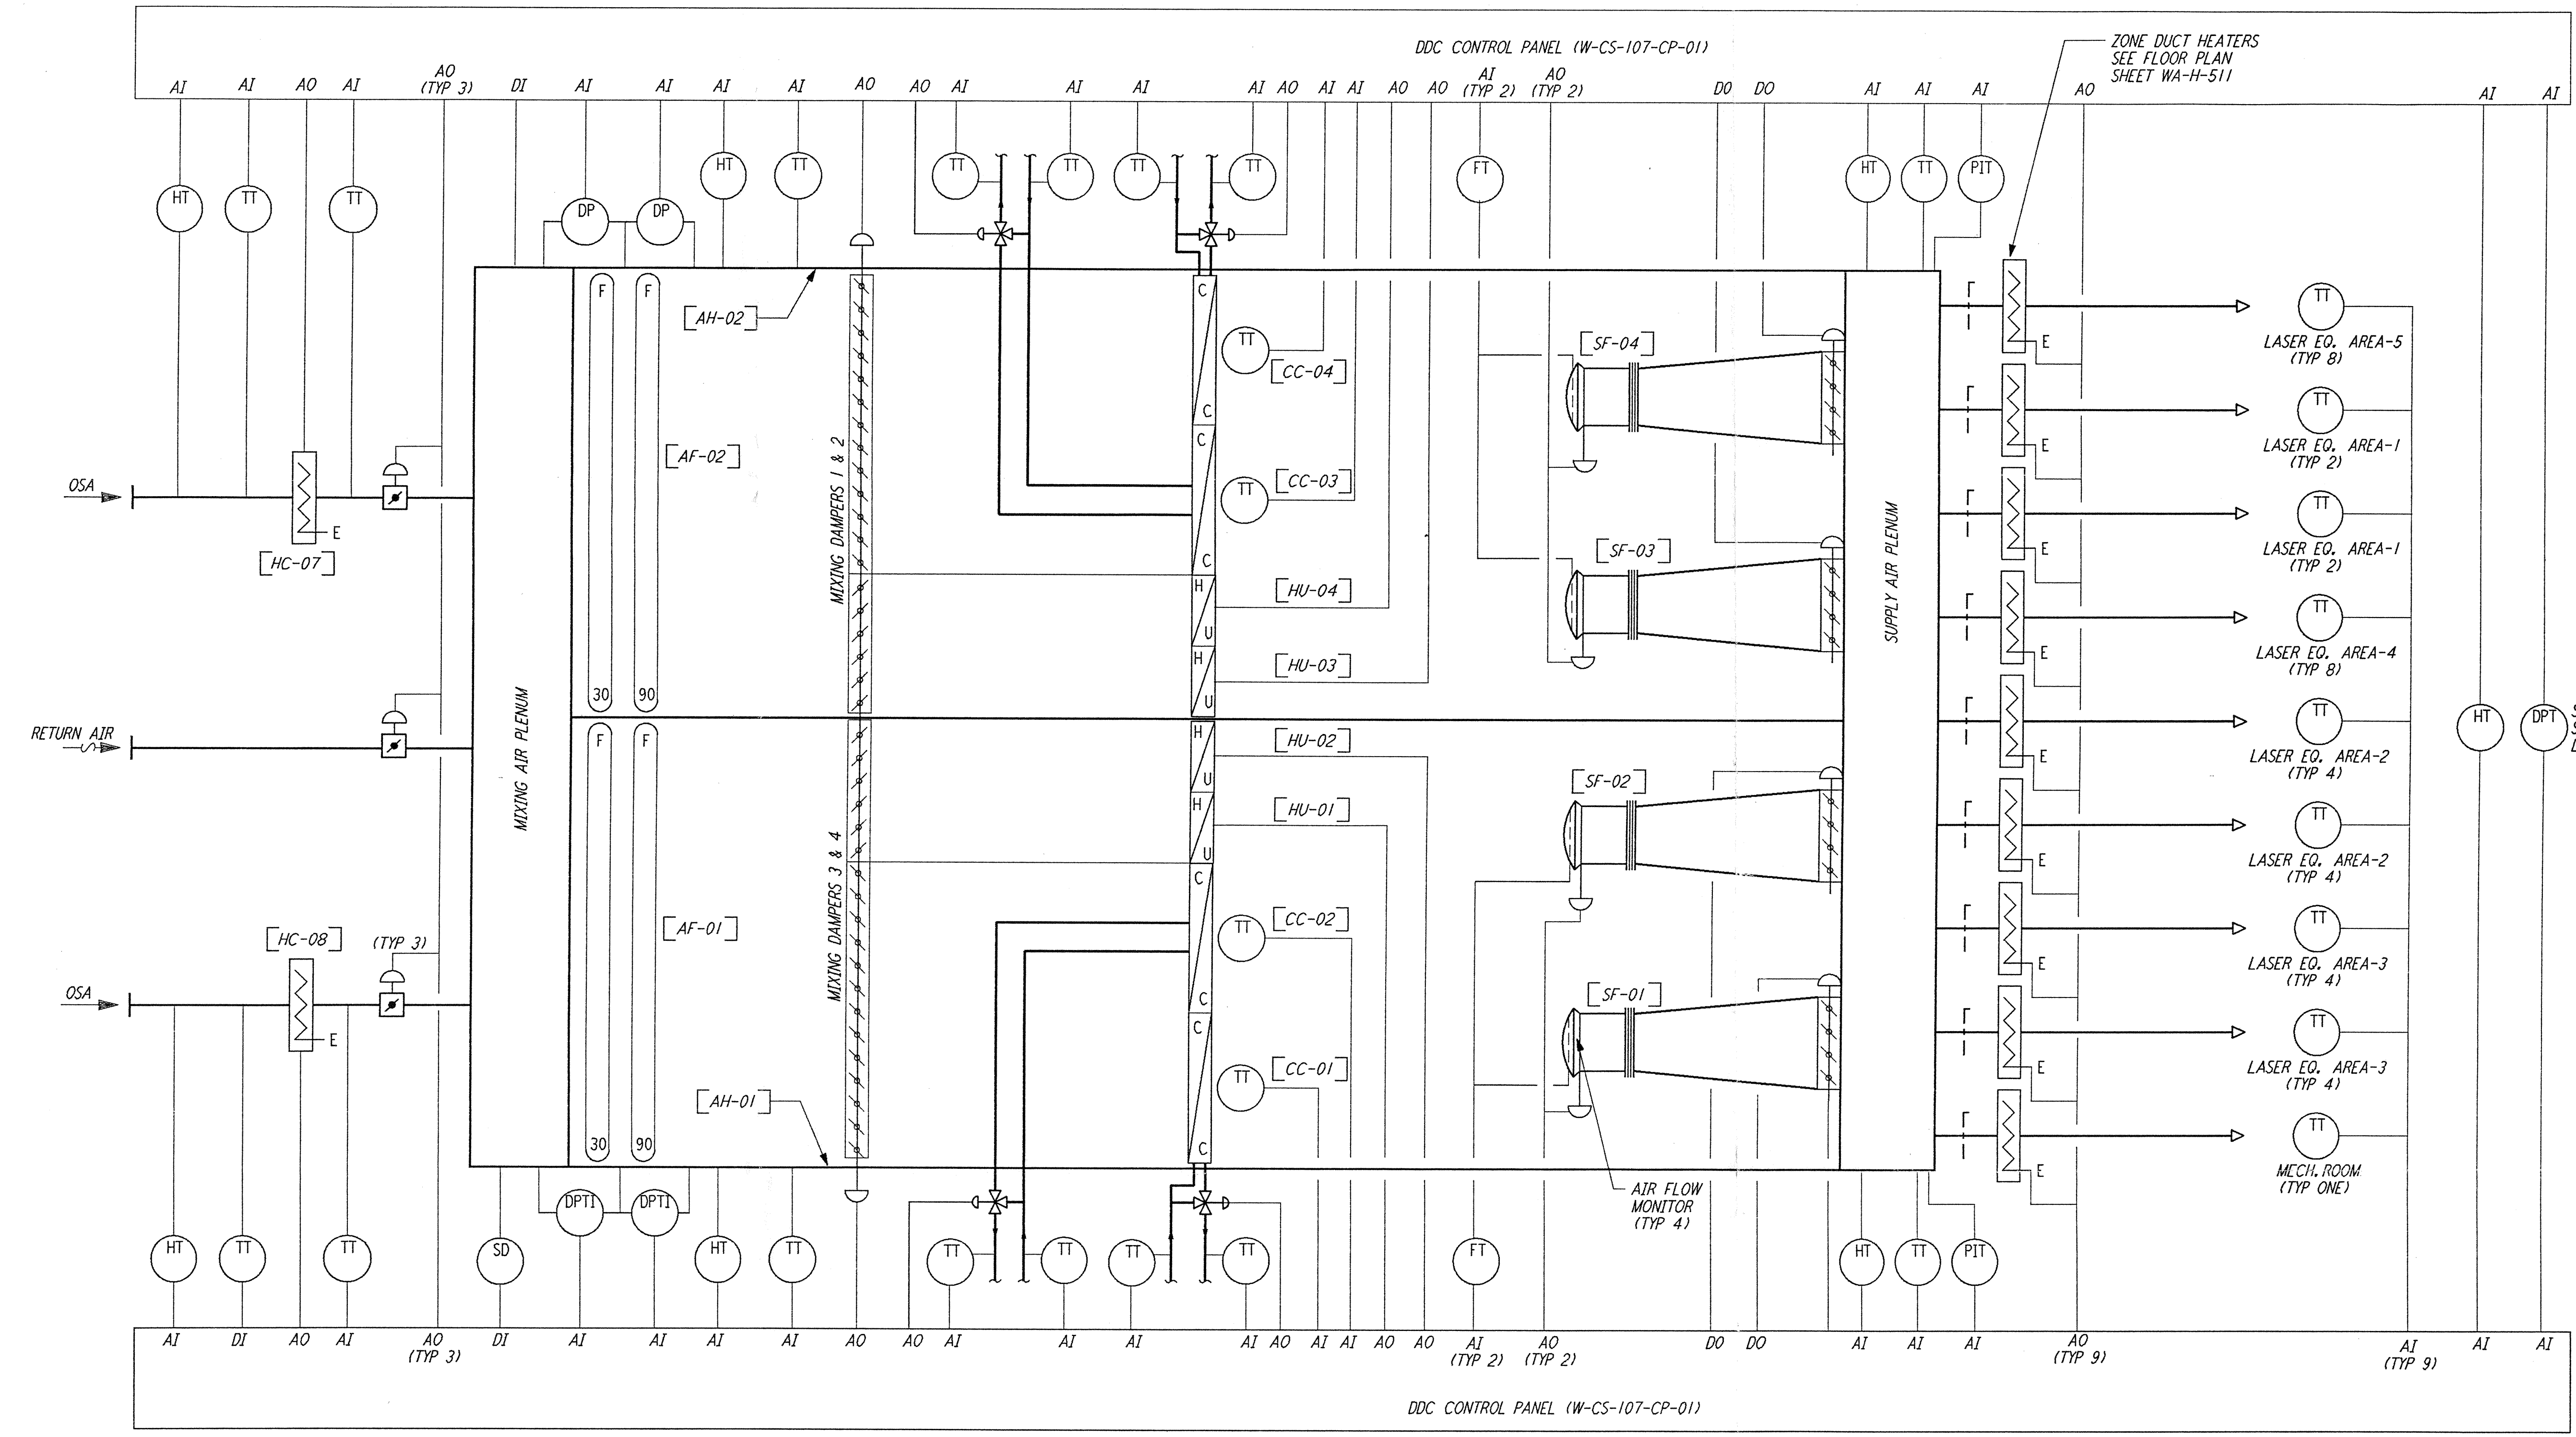

LVEA AIR FLOW & CONTROL DIAGRAM (AH-01 & AH-02)

This document and the design it covers are the property of PARSONS. They are loaned only with the borrower's expressed written agreement that they will not be reproduced, copied, loaned, exhibited, or used in any other way, except by written consent from PARSONS to the borrower.

NO.	DATE	BY	CHKD	ENGR	PROJ	DESCRIPTION
A	4-19-96	CLP	ME	AA		FINAL DESIGN REVIEW & BID

DRAWN	CLP
CHECKED	
ENGINEER	
PROJ	

PARSONS

100 WEST WALNUT STREET
 PASADENA, CALIFORNIA

LIGO

CALIFORNIA INSTITUTE OF TECHNOLOGY
 MASSACHUSETTS INSTITUTE OF TECHNOLOGY

LASER INTERFEROMETER GRAVITATIONAL-WAVE OBSERVATORY SITE NO. 1 - HANFORD, WASHINGTON		
TITLE	SCALE	CONTRACT NUMBER
HVAC CORNER STATION AIR FLOW DIAGRAMS	NONE	PP150969
		PROJECT NUMBER
		8094
SHEET NUMBER		REVISIONS
WA-H-521		