 



NOTES:
 1. FOR GENERAL NOTES, AND LEGEND SEE DWG. WA-E-110.

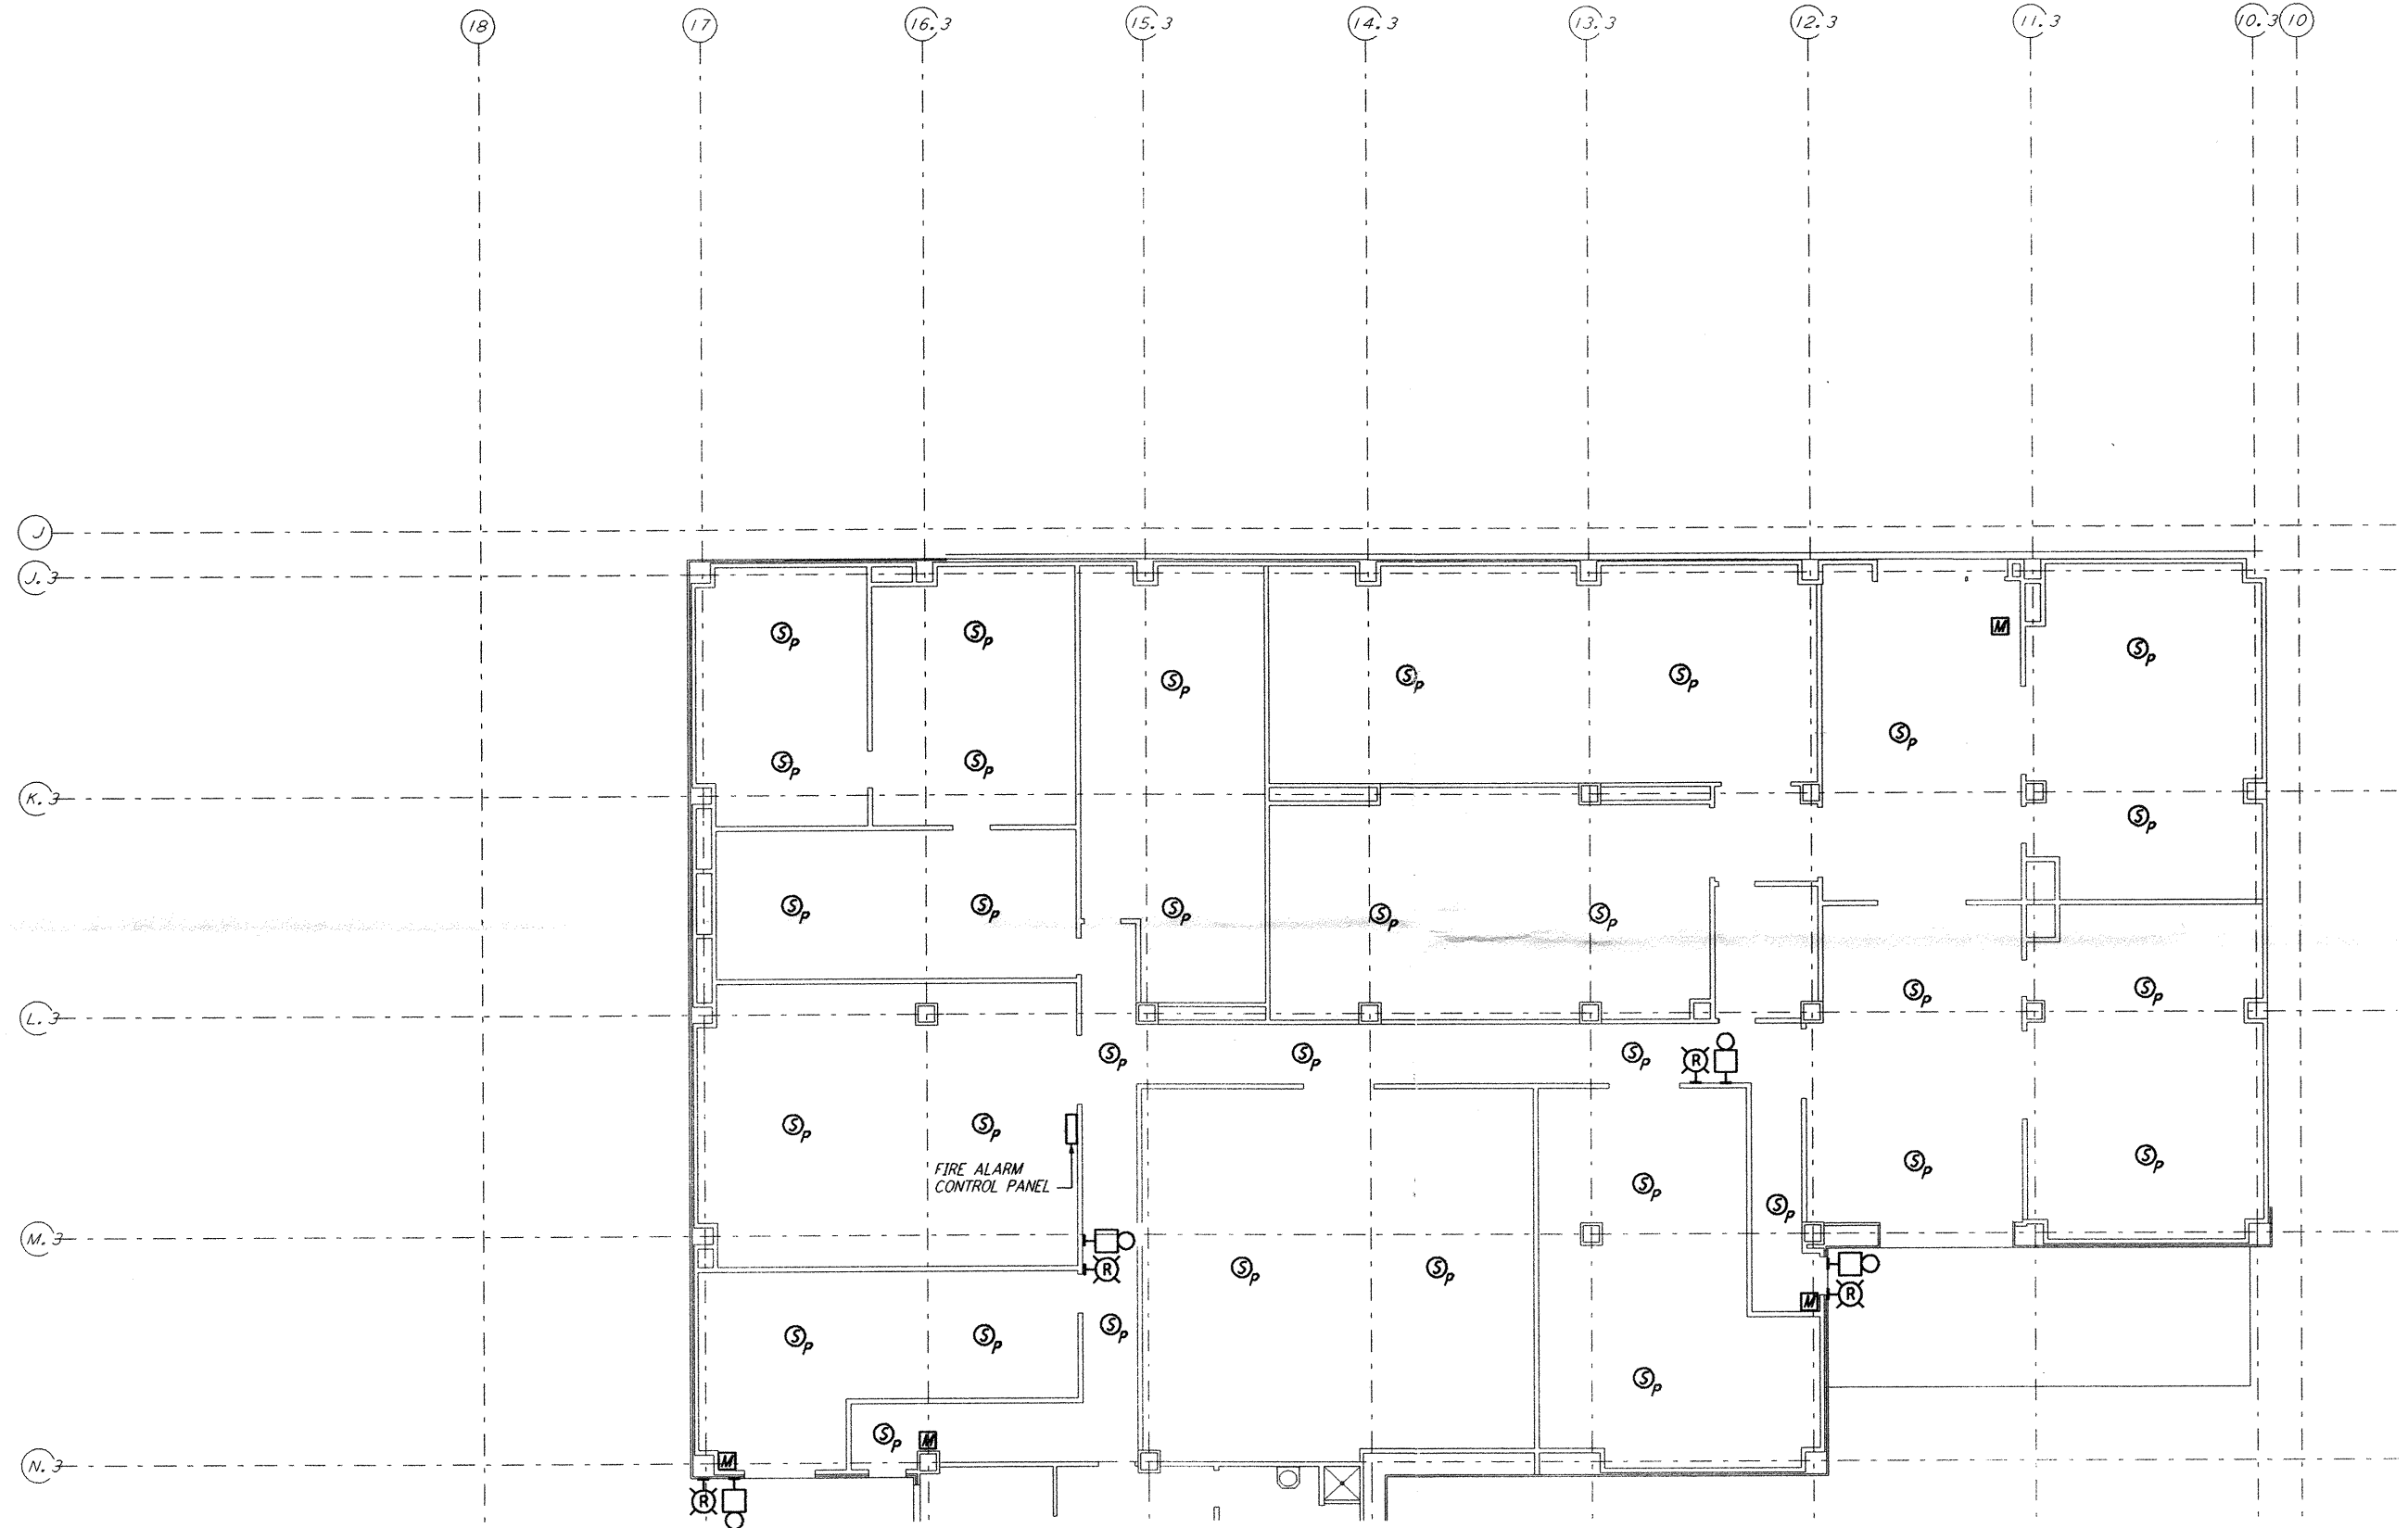

This document and the design it covers are the property of PARSONS. They are loaned only with the borrower's expressed written agreement that they will not be reproduced, copied, loaned, exhibited, or used in any other way, except by written consent from PARSONS to the borrower.

| REVISION NO. | DATE | APRD BY | DESCRIPTION OF REVISION |
|--------------|------|---------|-------------------------|
| 9 | | | |
| 8 | | | |
| 7 | | | |
| 6 | | | |
| 5 | | | |
| 4 | | | |
| 3 | | | |
| 2 | | | |
| 1 | | | |

| ISSUE NO. | DATE | APRD BY | ISSUED FOR |
|-----------|----------|---------|---------------------------|
| J | | | |
| H | | | |
| G | | | |
| F | | | |
| E | | | |
| D | | | |
| C | | | |
| B | | | |
| A | 10-31-95 | TDM | PRELIMINARY DESIGN REVIEW |

| DATE | 10-31-95 |
|----------|----------|
| DRAWN | J. G. |
| CHECKED | |
| ENGINEER | |
| PRDJ MGR | |

PARSONS
 100 WEST WALNUT STREET
 PASADENA, CALIFORNIA

LIGO
 CALIFORNIA INSTITUTE OF TECHNOLOGY
 MASSACHUSETTS INSTITUTE OF TECHNOLOGY

LASER INTERFEROMETER
 GRAVITATIONAL-WAVE OBSERVATORY
 SITE NO. 1 - HANFORD, WASHINGTON

ELECTRICAL CORNER STATION OSB LAB AREA FIRE DET AND SECURITY PLAN

SCALE: AS NOTED
 CONTRACT NUMBER: PP150969
 PROJECT NUMBER: 8094

REVISIONS: **WA-E-111**

Tue Oct 31 01:03:30 1995 s3-v18b2 J:\PLOTS\QUEUES\18B2\EE111A.PRF