



not be reproduced, copied, loaned, exhibited, or used in any other way, except by written consent from PARSONS to the borrower.

 
This document and the design it covers are the property of PARSONS. They are loaned only with the borrower's expressed written agreement that they will

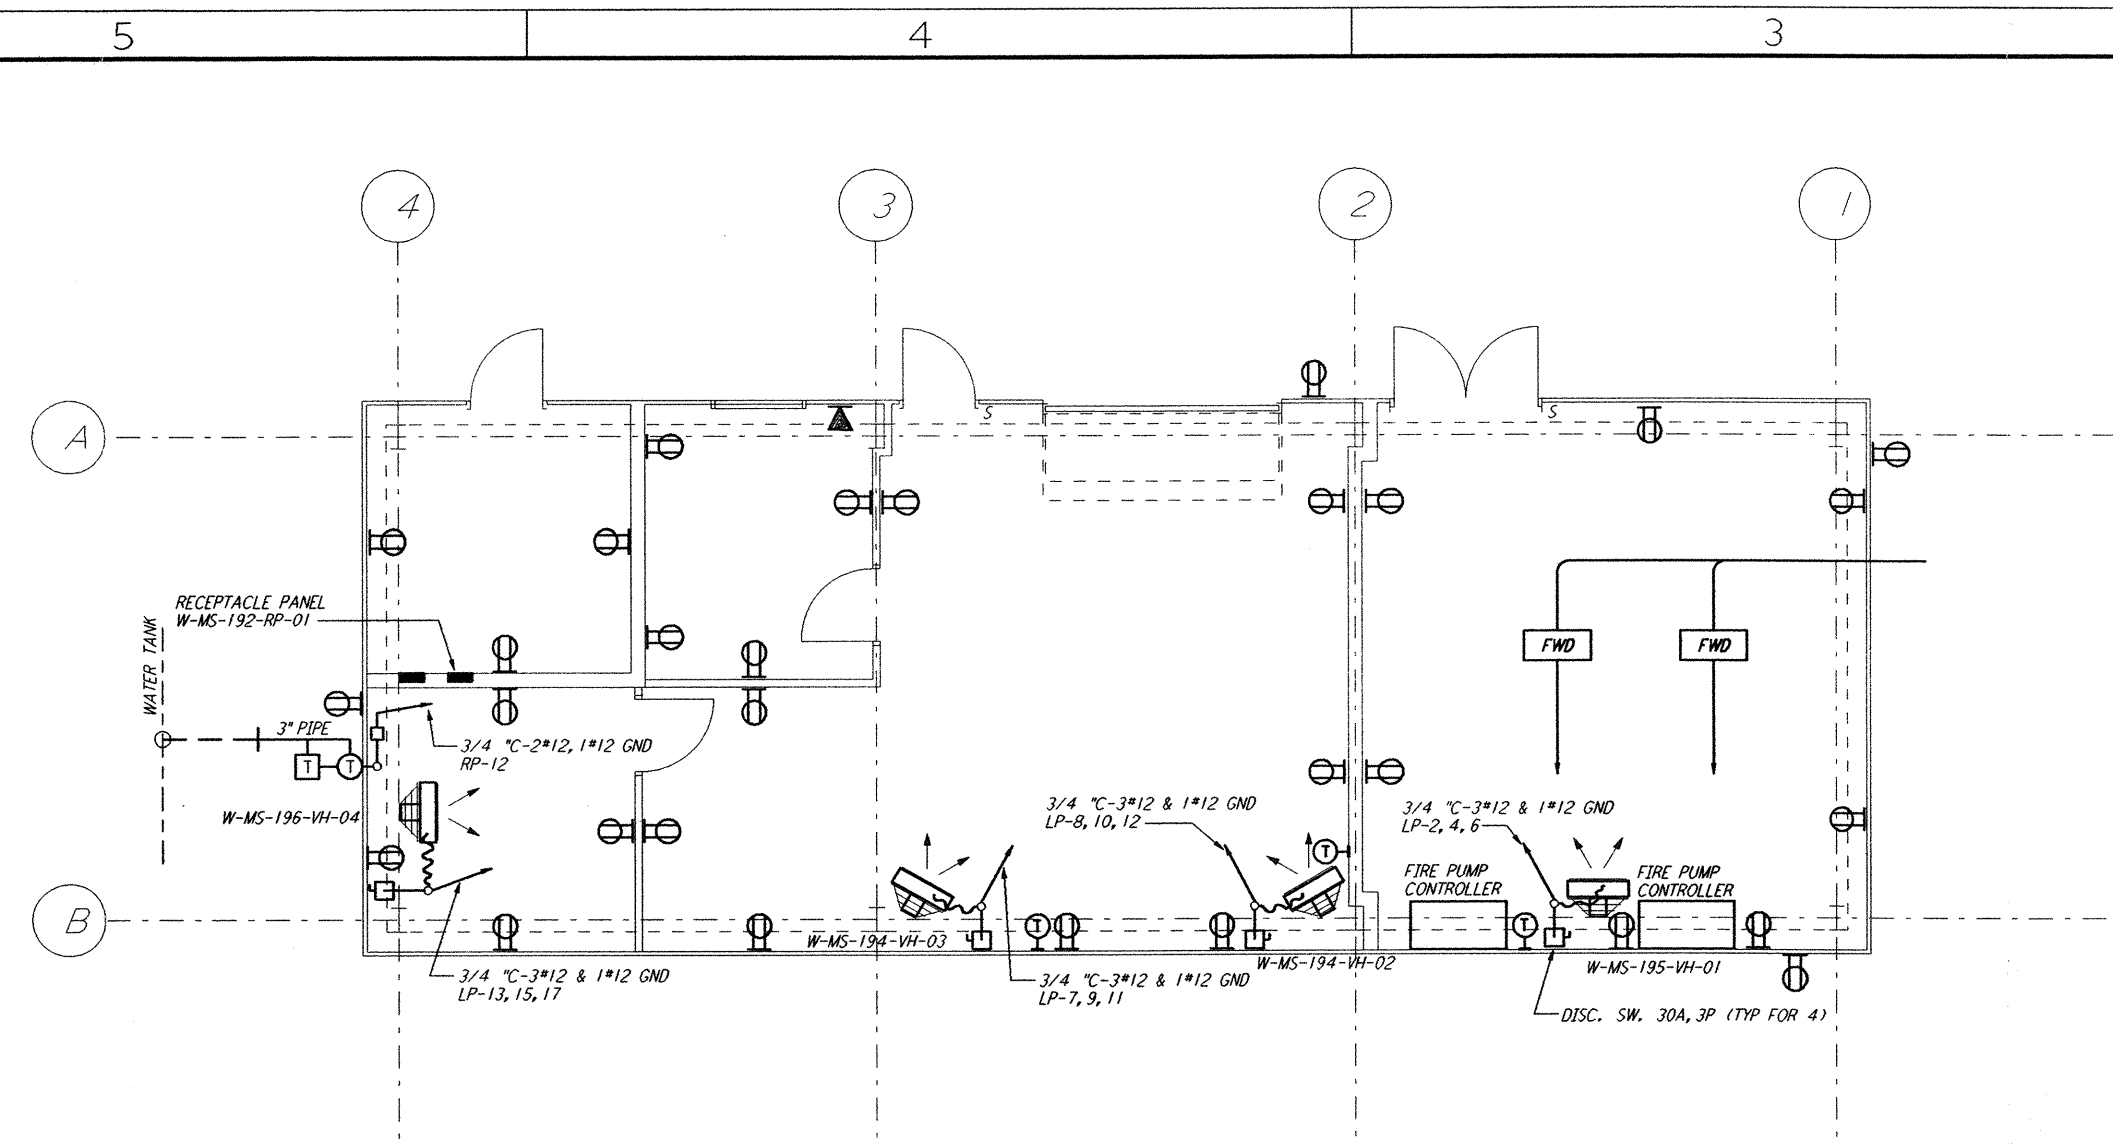

MAINTENANCE BUILDING FLOOR PLAN
 $\frac{1}{4}'' = 1'-0''$

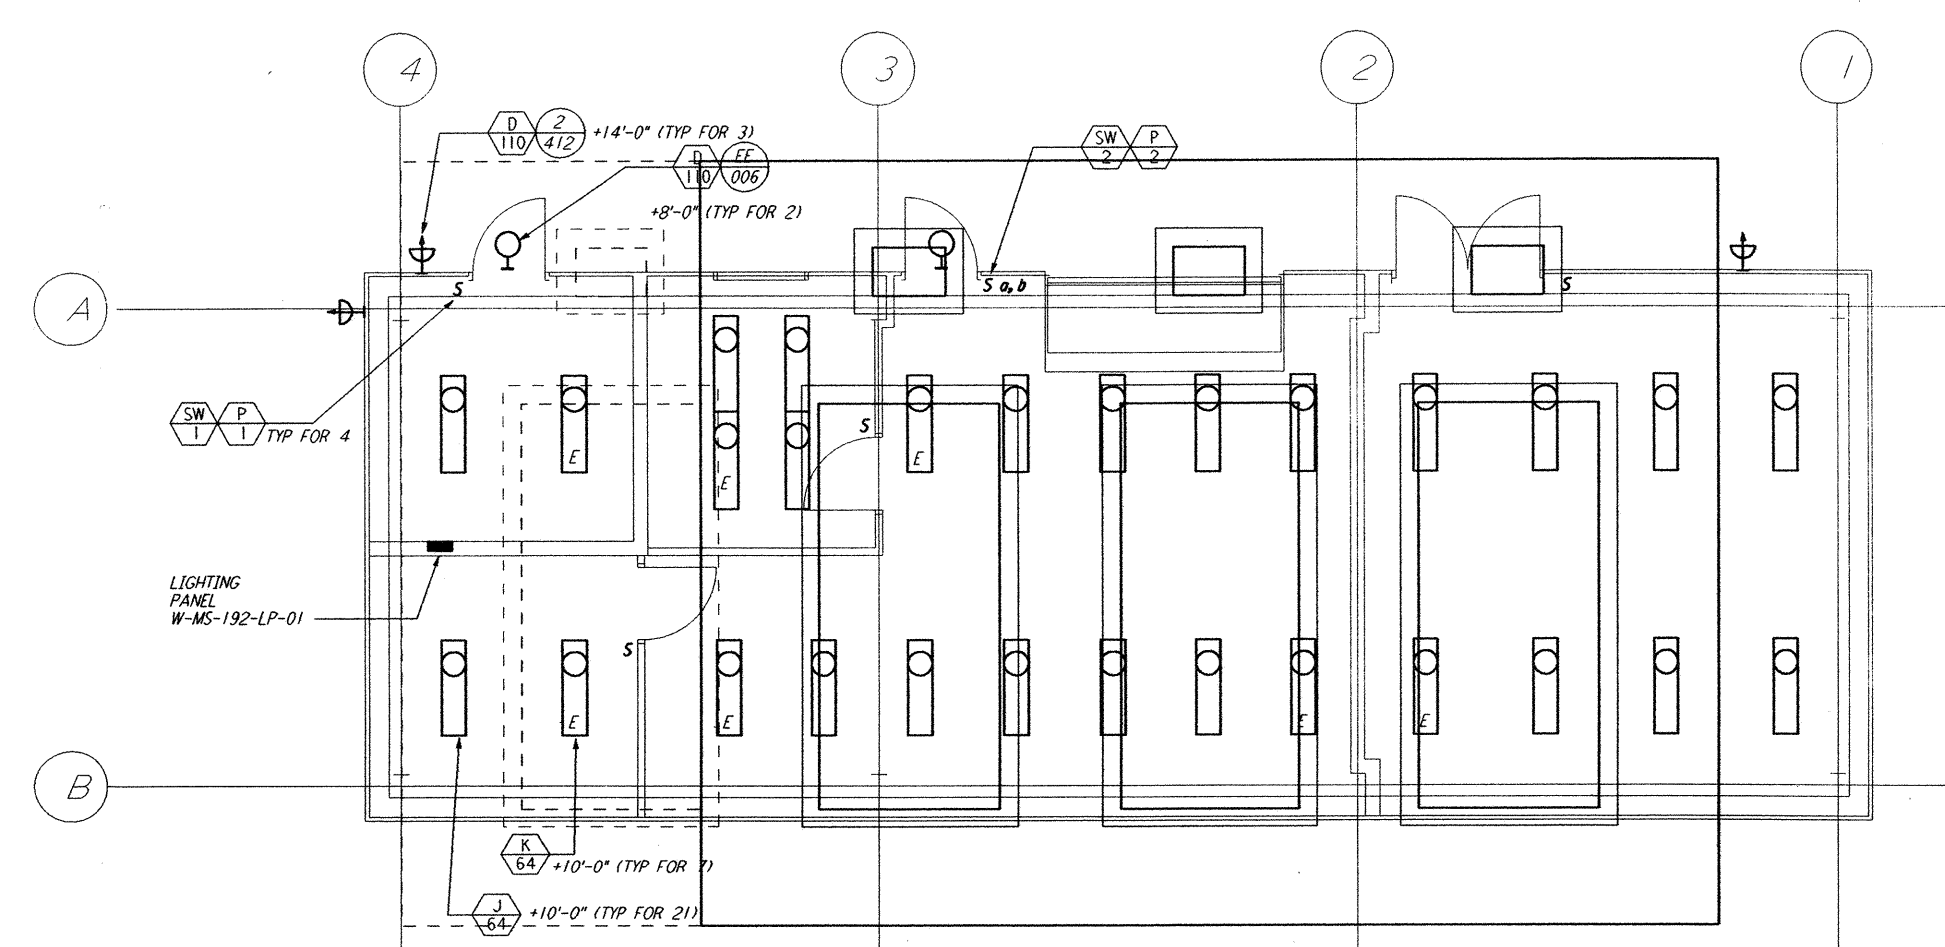

MAINTENANCE BUILDING LIGHTING PLAN
 $\frac{1}{4}'' = 1'-0''$



NO.	DATE	APRD BY	DESCRIPTION OF REVISION

NO.	DATE	APRD BY	ISSUED FOR
A	10-31-95	TDM	PRELIMINARY DESIGN REVIEW

DATE	10-31-95
DRAWN	J.G.
CHECKED	
ENGINEER	
PROJ MGR	

PARSONS
 100 WEST WALNUT STREET
 PASADENA, CALIFORNIA

LIGO
 CALIFORNIA INSTITUTE OF TECHNOLOGY
 MASSACHUSETTS INSTITUTE OF TECHNOLOGY

LASER INTERFEROMETER
 GRAVITATIONAL-WAVE OBSERVATORY
 SITE NO. 1 - HANFORD, WASHINGTON
 TITLE: ELECTRICAL CORNER STATION CHILLER MAINTENANCE BLDG POWER PLAN
 SHEET NUMBER: WA-E-113
 AS NOTED PP150969 8094
 SCALE: AS NOTED
 PROJECT NUMBER: 8094

Tue Oct 31 01:04:41 1995 s3-v18b2 J:\PLOTS\QUEUES\V18B2\EE113A.PRF