

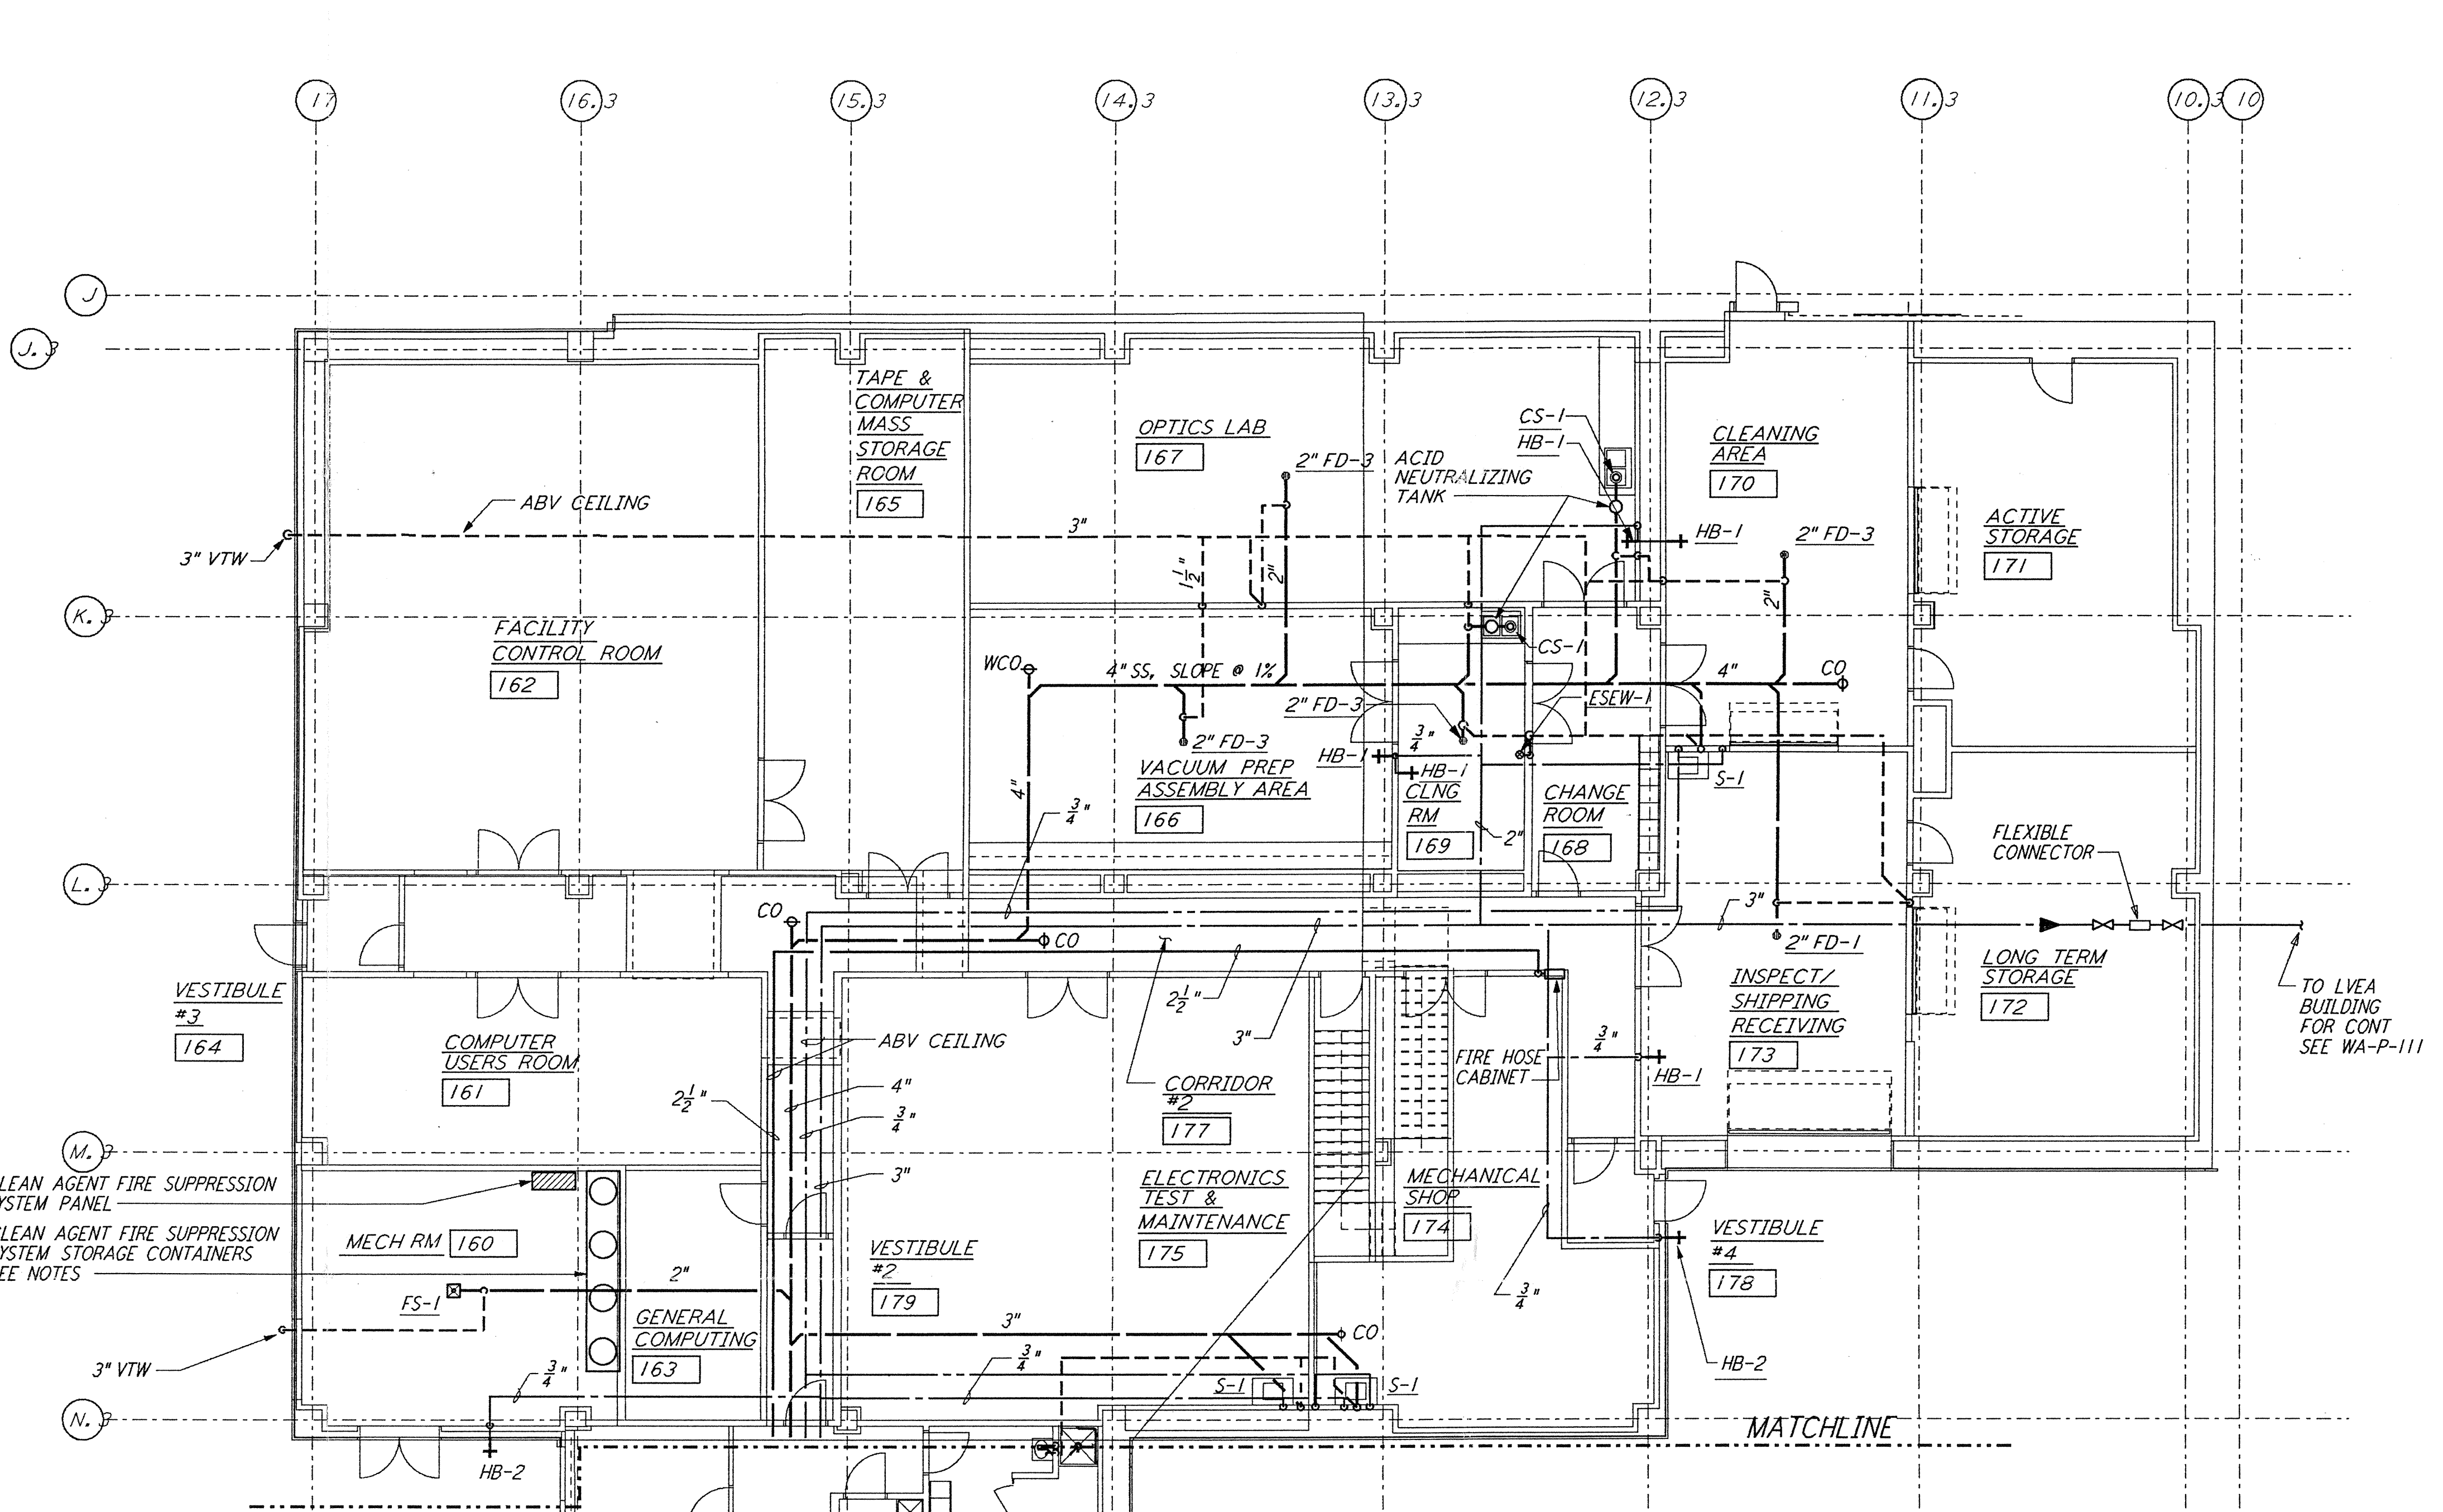
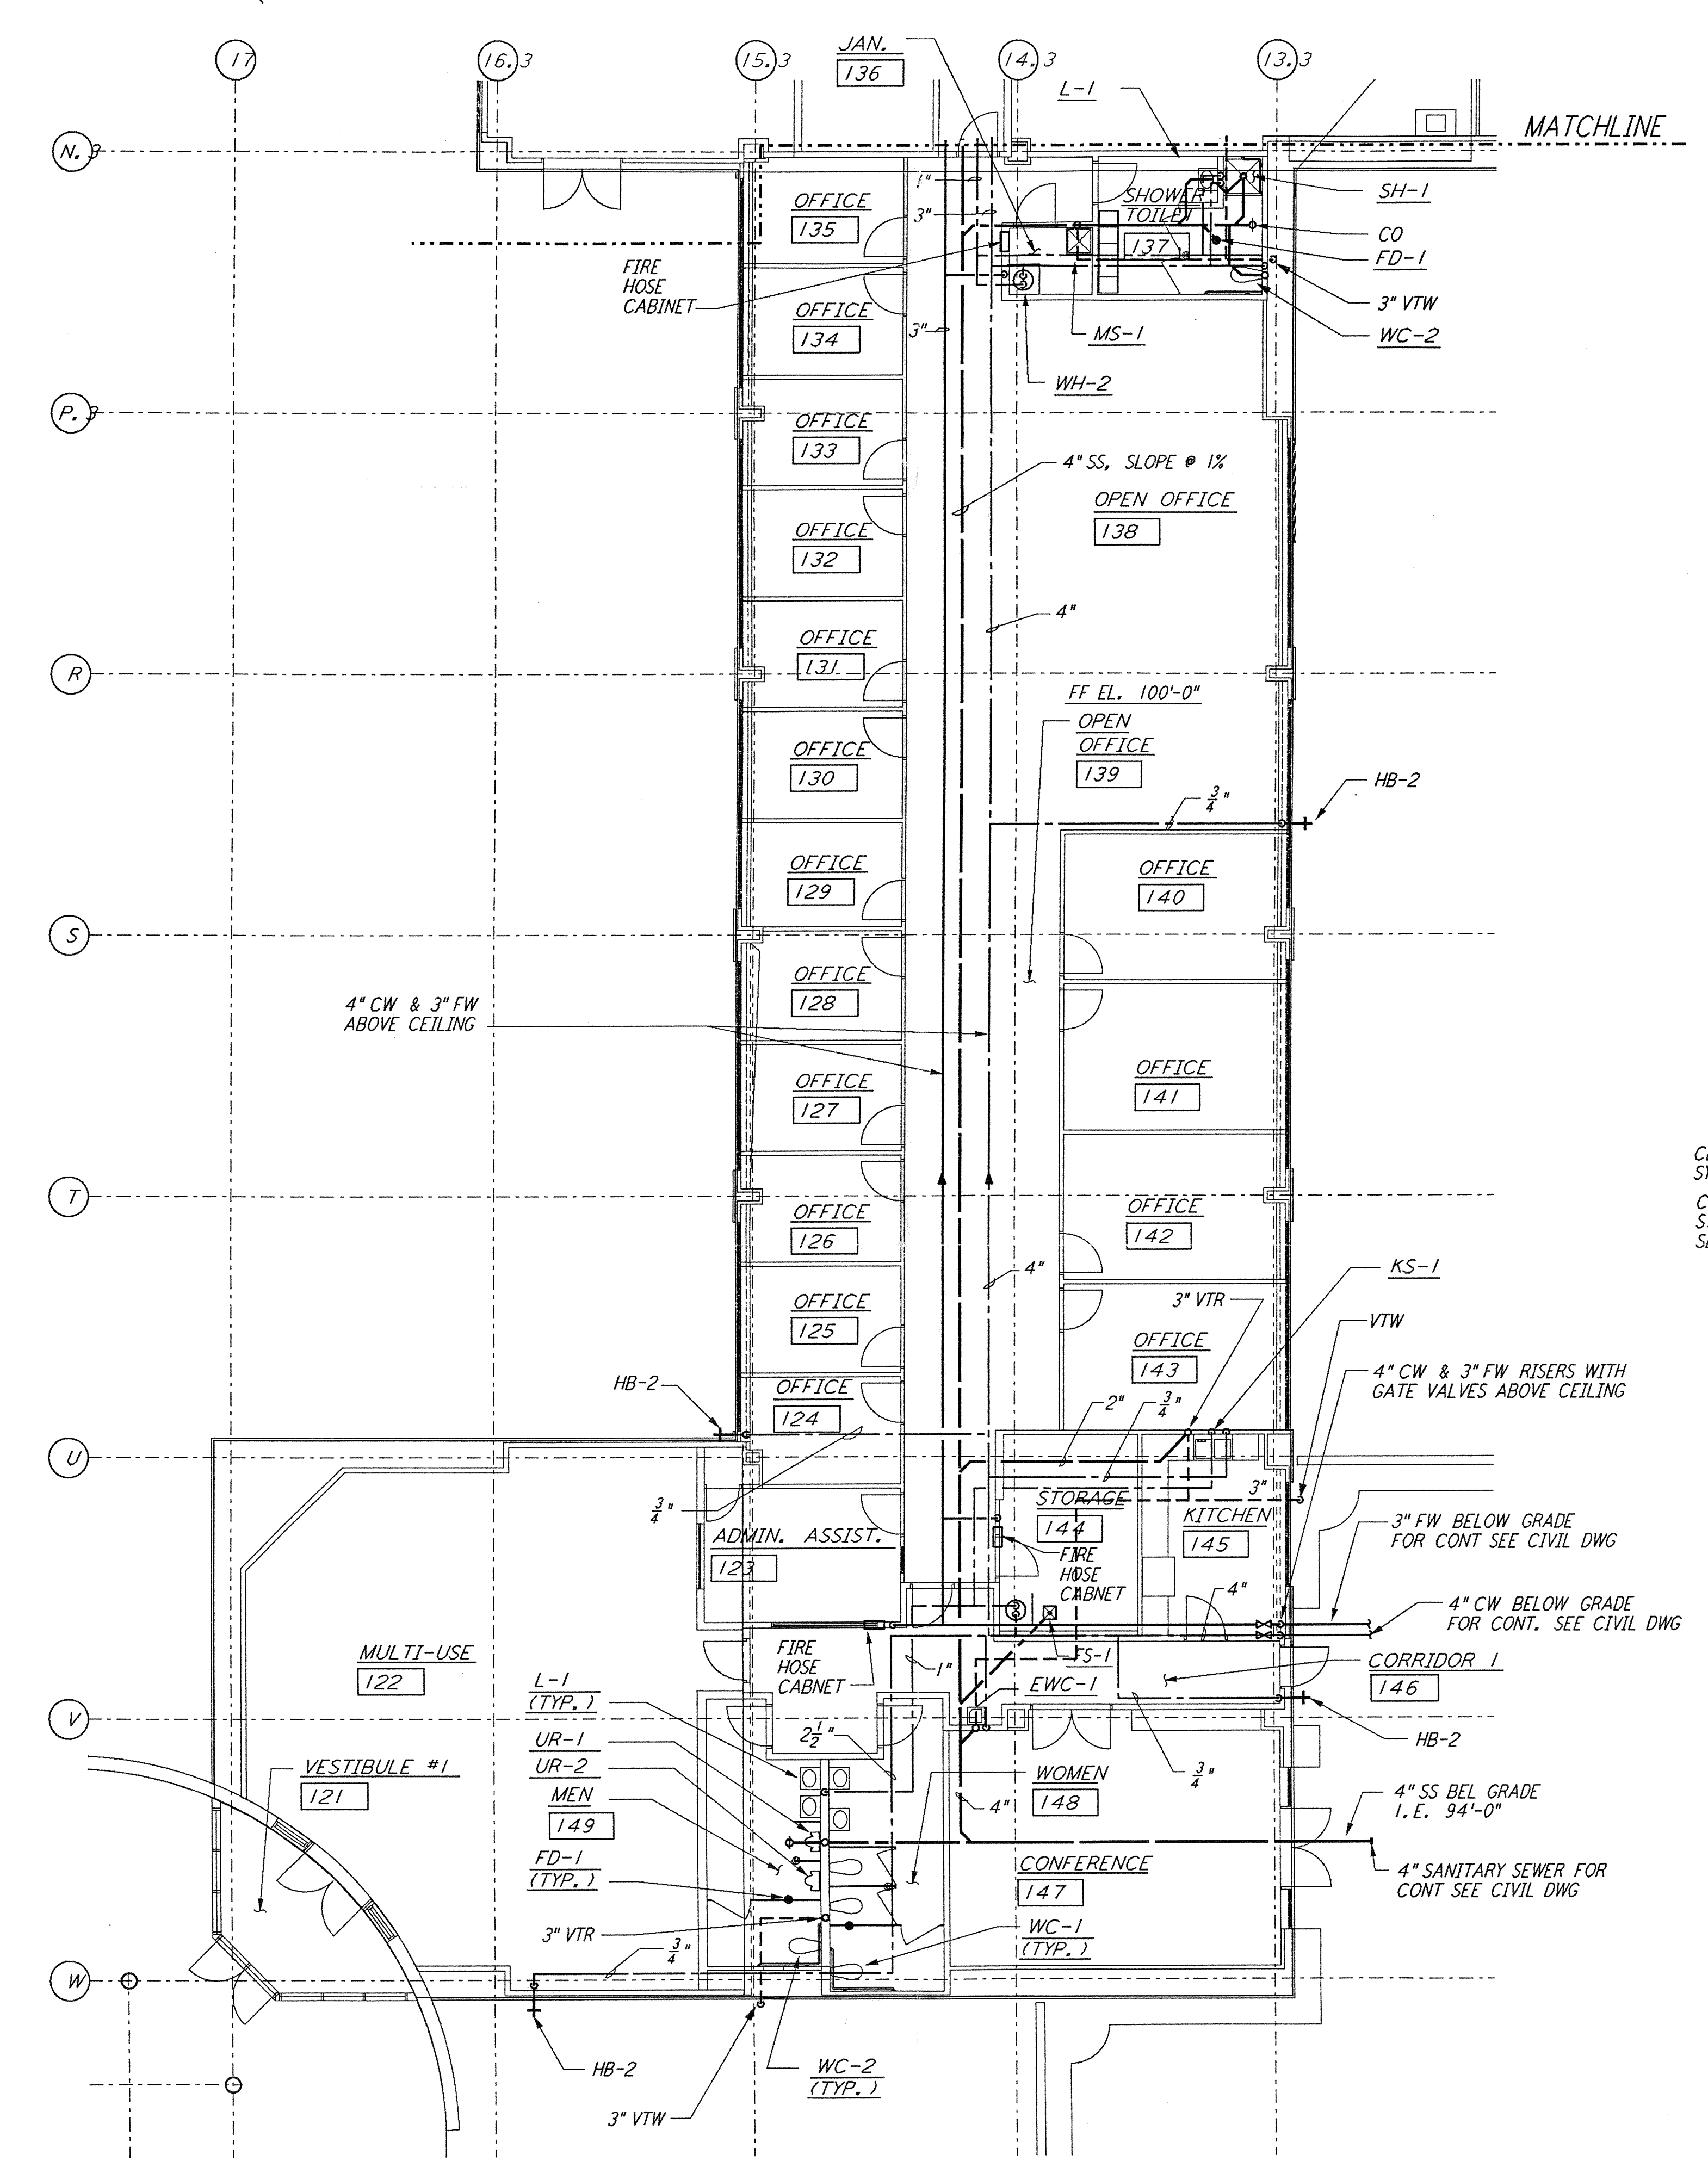


This document and the design it covers are the property of PARSONS. They are loaned only with the borrower's expressed written agreement that they will not be reproduced, copied, loaned, exhibited, or used in any other way, except by written consent from PARSONS to the borrower.

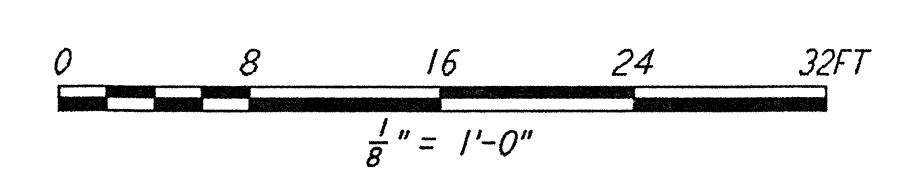

- NOTES:**
- A CLEAN AGENT FIRE SUPPRESSION SYSTEM SHALL BE PROVIDED ABOVE AND WITHIN THE DEPRESSED FLOOR SPACE, FOR THE FOLLOWING ROOMS:
    - A. FACILITY CONTROL ROOM [162]
    - B. TAPE & COMPUTER MASS STORAGE ROOM [165]
    - C. COMPUTER USERS ROOM [161]
    - D. GENERAL COMPUTING [163]
  - REFER TO THE PERFORMANCE TYPE SPECIFICATIONS FOR REQUIREMENTS AND DESIGN CRITERIA.

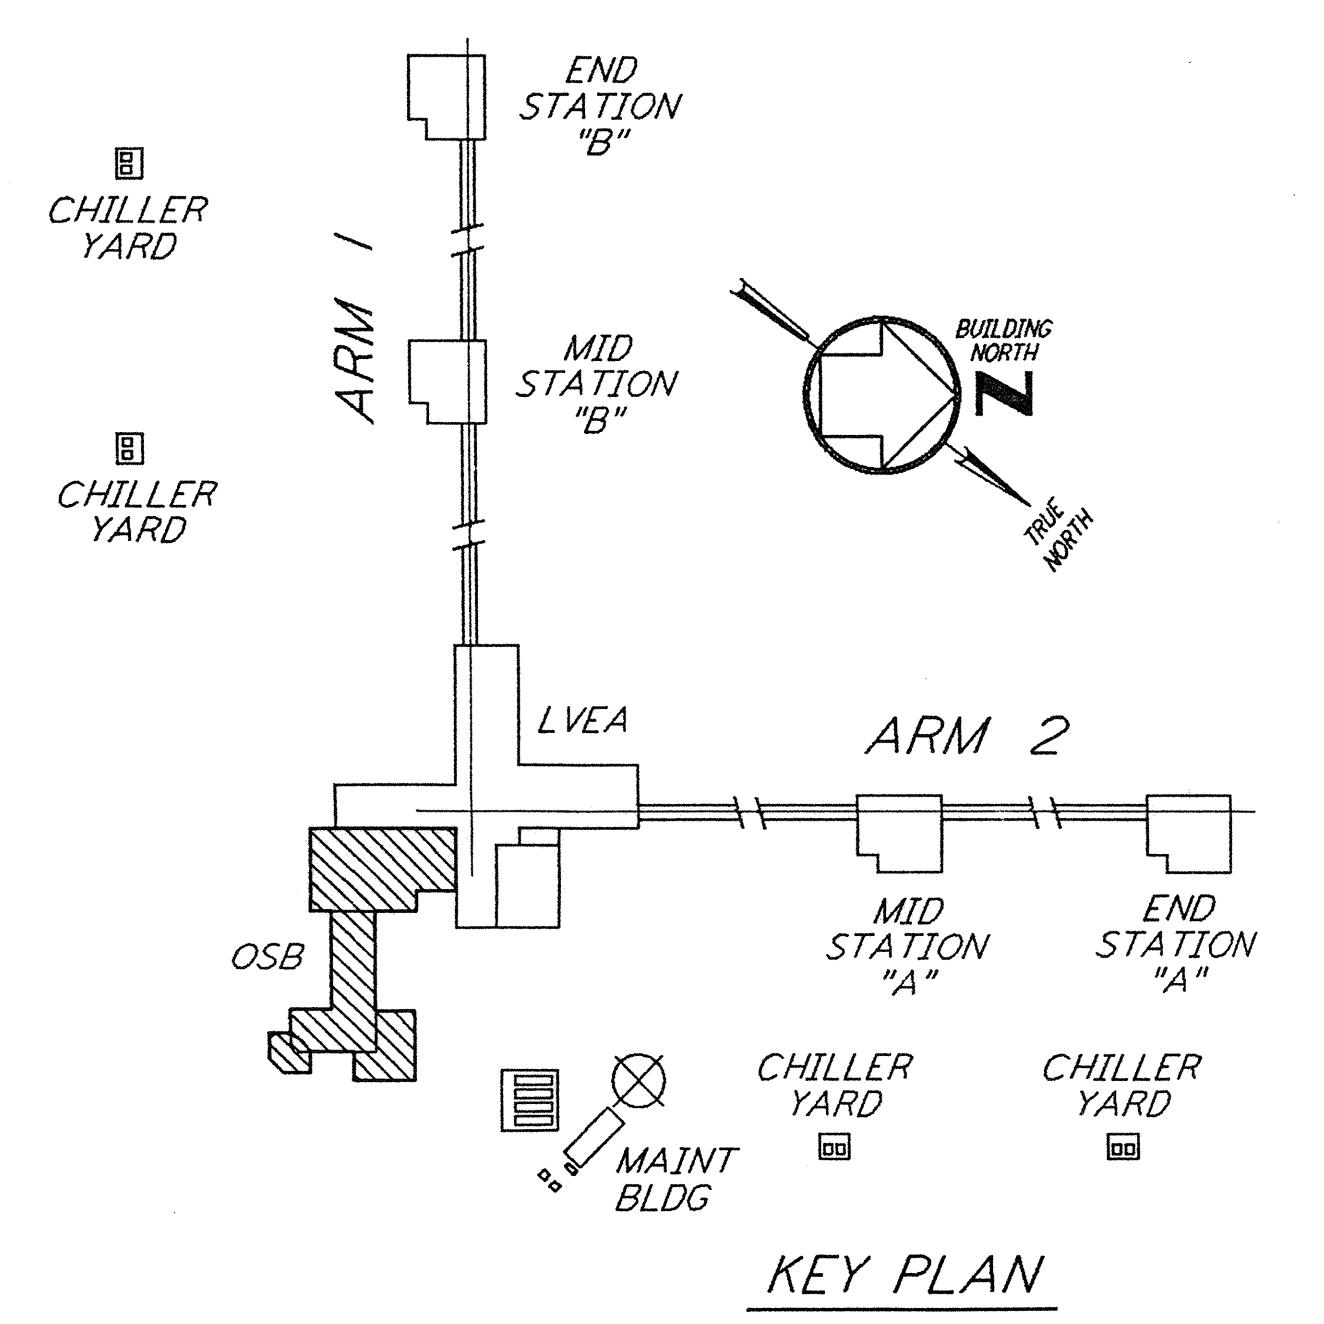

NO.	DATE	BY	CHKD	ENGR	PROJ	DESCRIPTION
B	4-19-96	DG	MP	MN	TDM	FINAL DESIGN REVIEW & BID
A	10-31-95	SG	MP	MN	TDM	PRELIMINARY DESIGN REVIEW

DRAWN	DC
CHECKED	
ENGINEER	
PROJ	

100 WEST WALNUT STREET  
PASADENA, CALIFORNIA

CALIFORNIA INSTITUTE OF TECHNOLOGY  
MASSACHUSETTS INSTITUTE OF TECHNOLOGY

LASER INTERFEROMETER  
GRAVITATIONAL-WAVE OBSERVATORY  
SITE NO. 1 - HANFORD, WASHINGTON

TITLE	SCALE	CONTRACT NUMBER	PROJECT NUMBER
PLUMBING CORNER STATION OSB FLOOR PLAN	AS NOTED	PP150969	8094
SHEET NUMBER		REVISIONS	
WA-P-112		A	

LIGO-D980441-BFO