
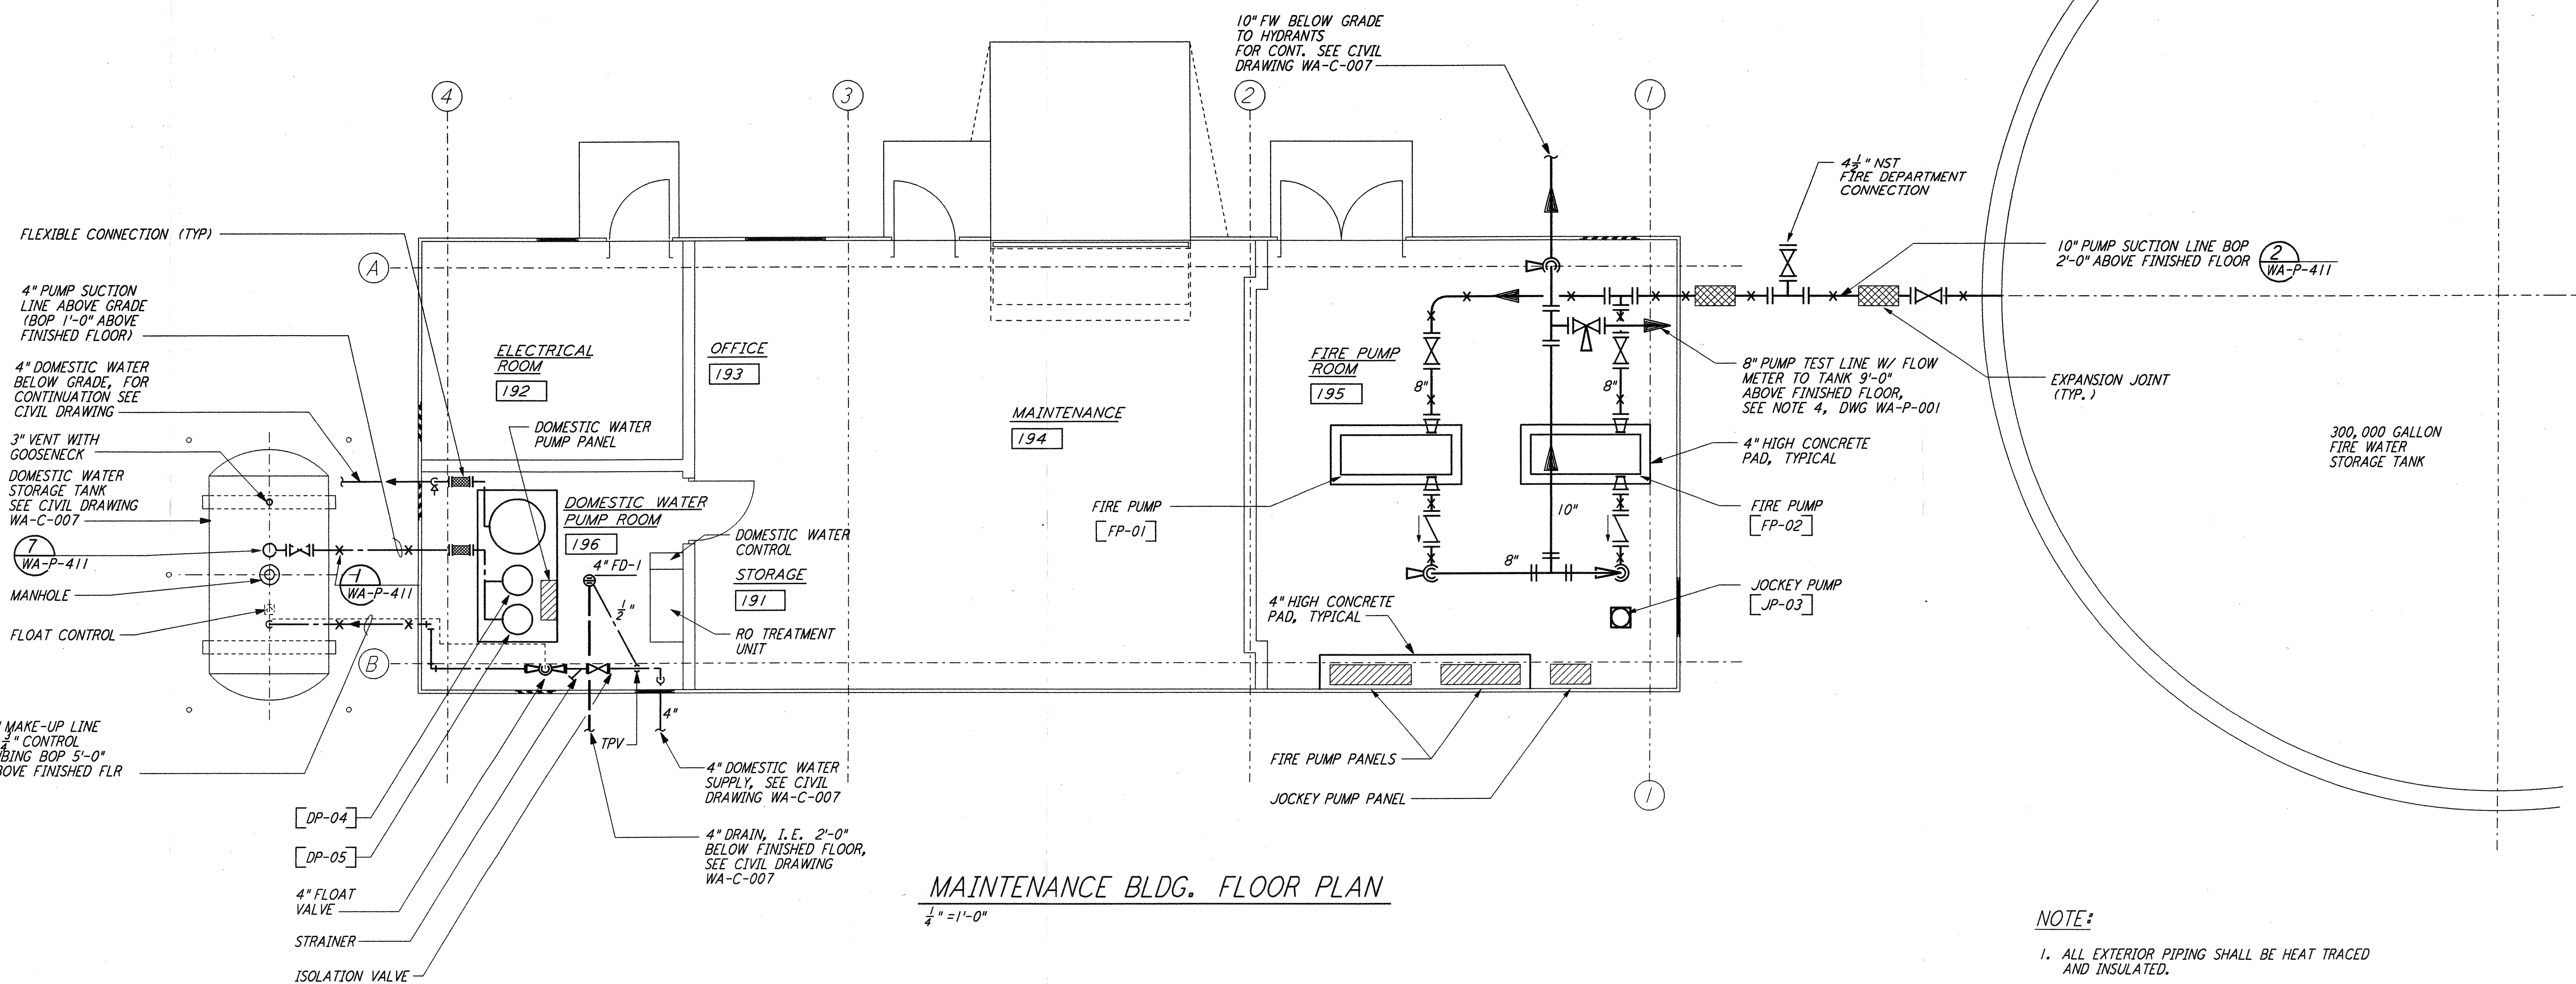


5

4

3

2

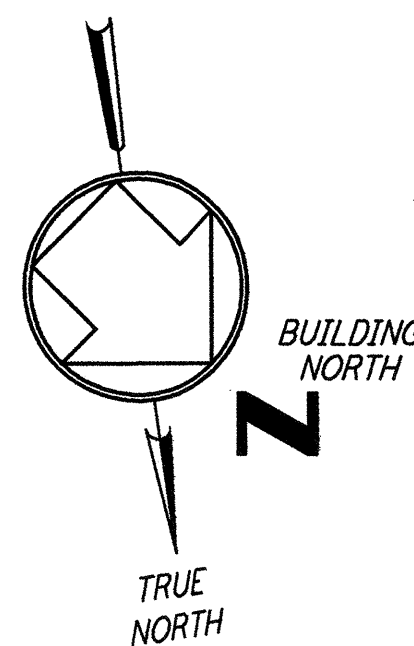


MAINTENANCE BLDG. FLOOR PLAN
 1/4" = 1'-0"

NOTE:


- 1. ALL EXTERIOR PIPING SHALL BE HEAT TRACED AND INSULATED.

not be reproduced, copied, loaned, exhibited, or used in any other way, except by written consent from PARSONS to the borrower.

This document and the design it covers are the property of PARSONS. They are loaned only with the borrower's expressed written agreement that they will

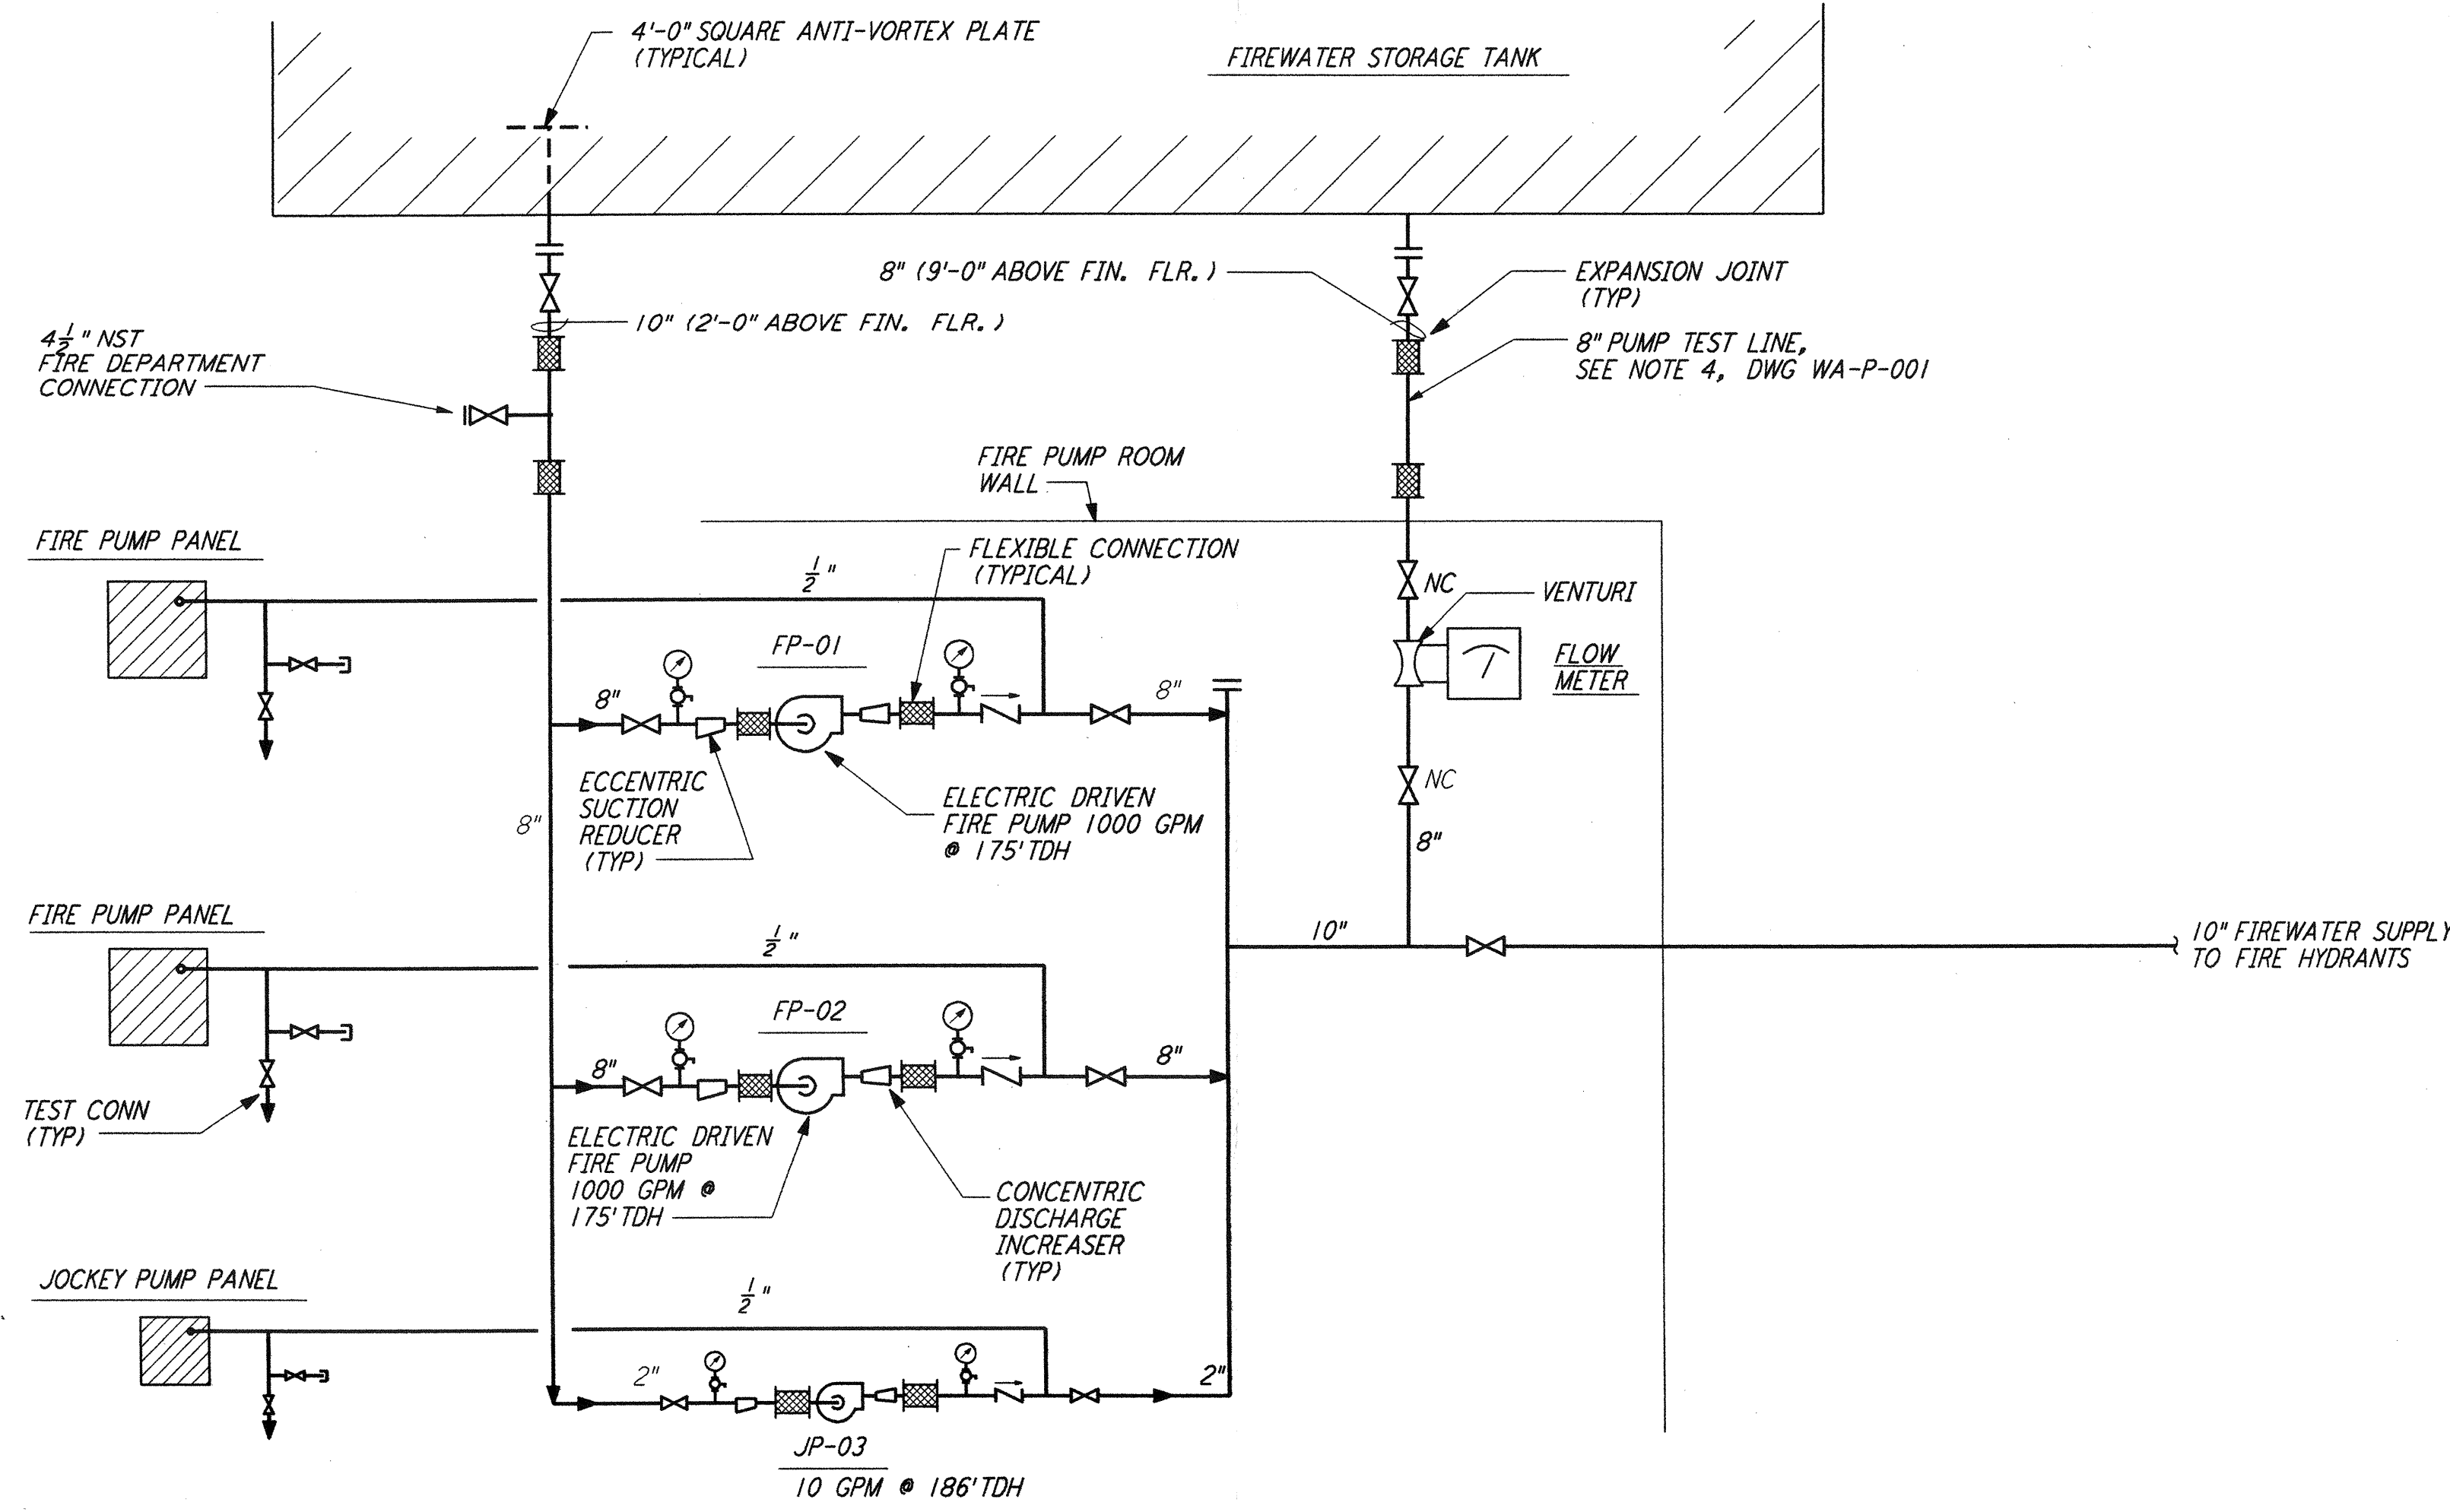

FIRE PUMP FLOW DIAGRAM
 SCALE: NTS

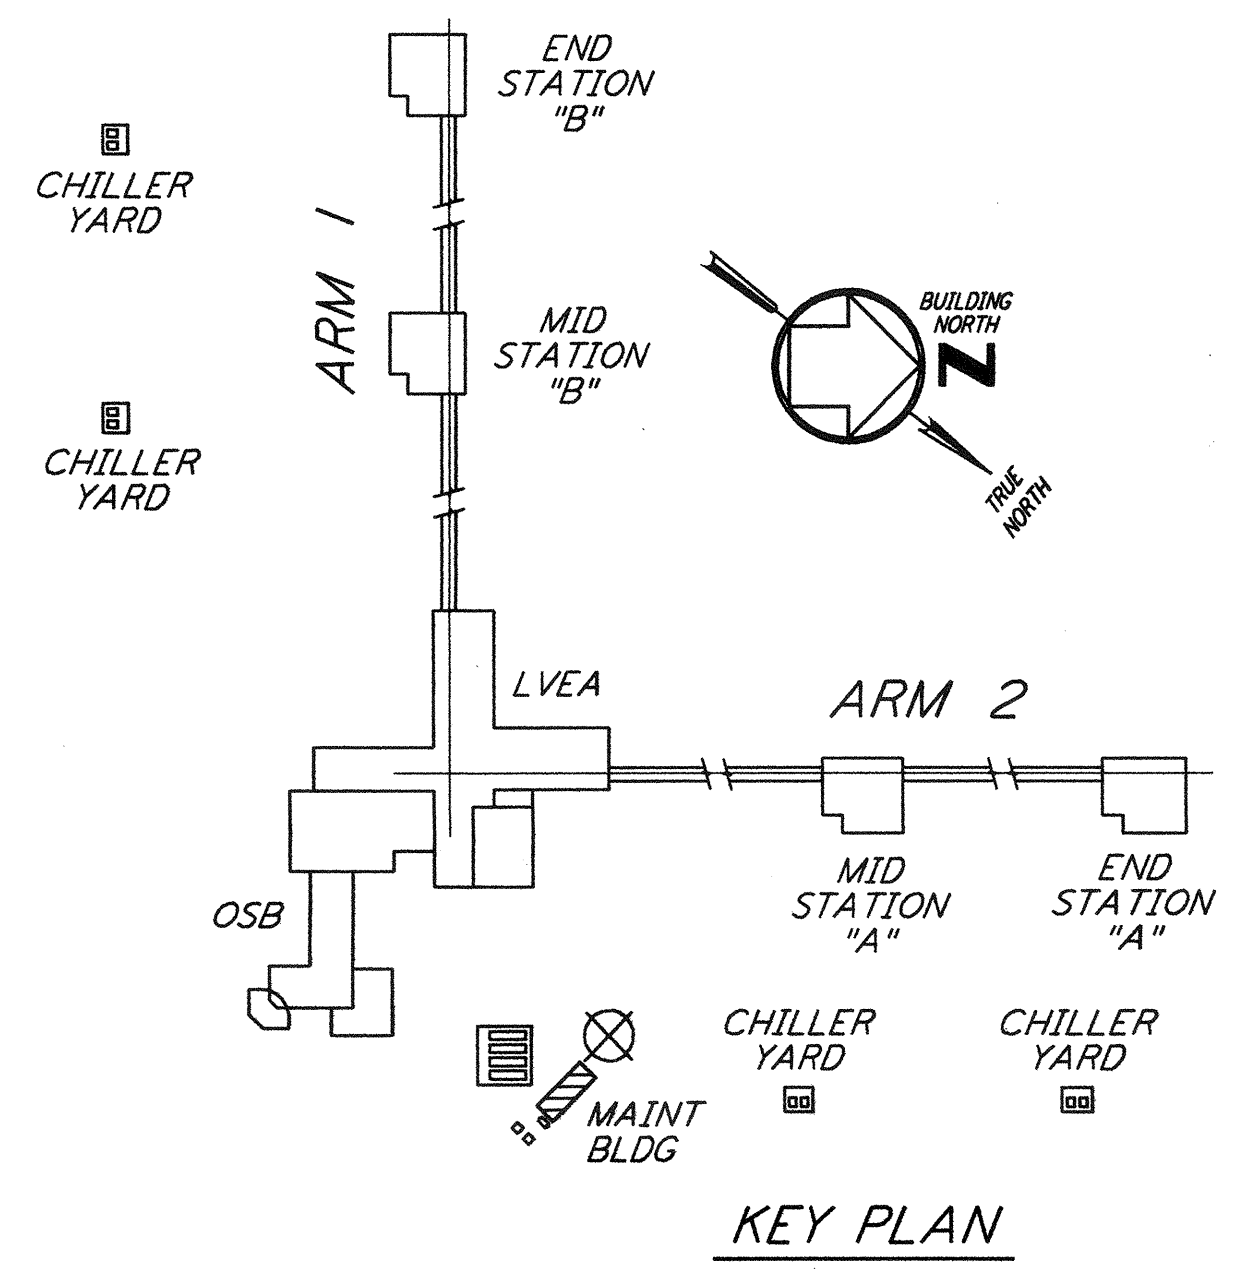

KEY PLAN
 0 4 8 12 16 FT
 1/4" = 1'-0"

NO.	DATE	BY	CHKD	ENGR	PROJ	DESCRIPTION
1	5-15-98	CP	AA	AA	PK	ISSUED FOR AS-BUILT

ISSUED FOR CONSTRUCTION	
DRAWN	DG 6-24-96
CHECKED	WR 7/19/96
ENGINEER	MN 7/19/96
PROJ	MDW 7/19/96

AS-BUILT DRAWINGS

100 WEST WALNUT STREET
 PASADENA, CALIFORNIA

CALIFORNIA INSTITUTE OF TECHNOLOGY
 MASSACHUSETTS INSTITUTE OF TECHNOLOGY

LIGO-D960442-01-0

LASER INTERFEROMETER
 GRAVITATIONAL-WAVE OBSERVATORY
 SITE NO. 1 - HANFORD, WASHINGTON

TITLE	PLUMBING CORNER STATION MAINTENANCE BUILDING FLOOR PLAN & FLOW DIAGRAM	SHEET NUMBER	AS NOTED PPI50969	PROJECT NUMBER	8094
			WA-P-113		

5

4

3

2

LIGOWAF3.BDR