



- NOTES:**
- 1) FOR GENERAL NOTES & LEGEND SEE PSI DWG. #V049-3-001 SHT. 1.
 - 2) FOR LIST OF CIVIL CONTRACTORS REFERENCE DWGS. WITH CURRENT REVISIONS SEE PSI DWG. #V049-3-001 SHT. 2.
 - 3) DATA HIGHWAY EXTENSION CABLES FOR BAKEOUT CART TO CONNECTION BOX ARE PROVIDED W/CART.
 - 4) FOR DATA HIGHWAY INTERCONNECTING WIRING SEE DWG. #V049-3-131.
 - 5) IDENTIFY ALL CONNECTION BOXES WITH BLACK PHENOLIC TAGS WITH WHITE LETTERING. LETTERING SHALL BE 3/8" HIGH.
 - 6) LOCATE CONNECTION BOXES ADJACENT TO BAKEOUT CART CONTROL POWER. SEE PSI DWG. #V049-3-118

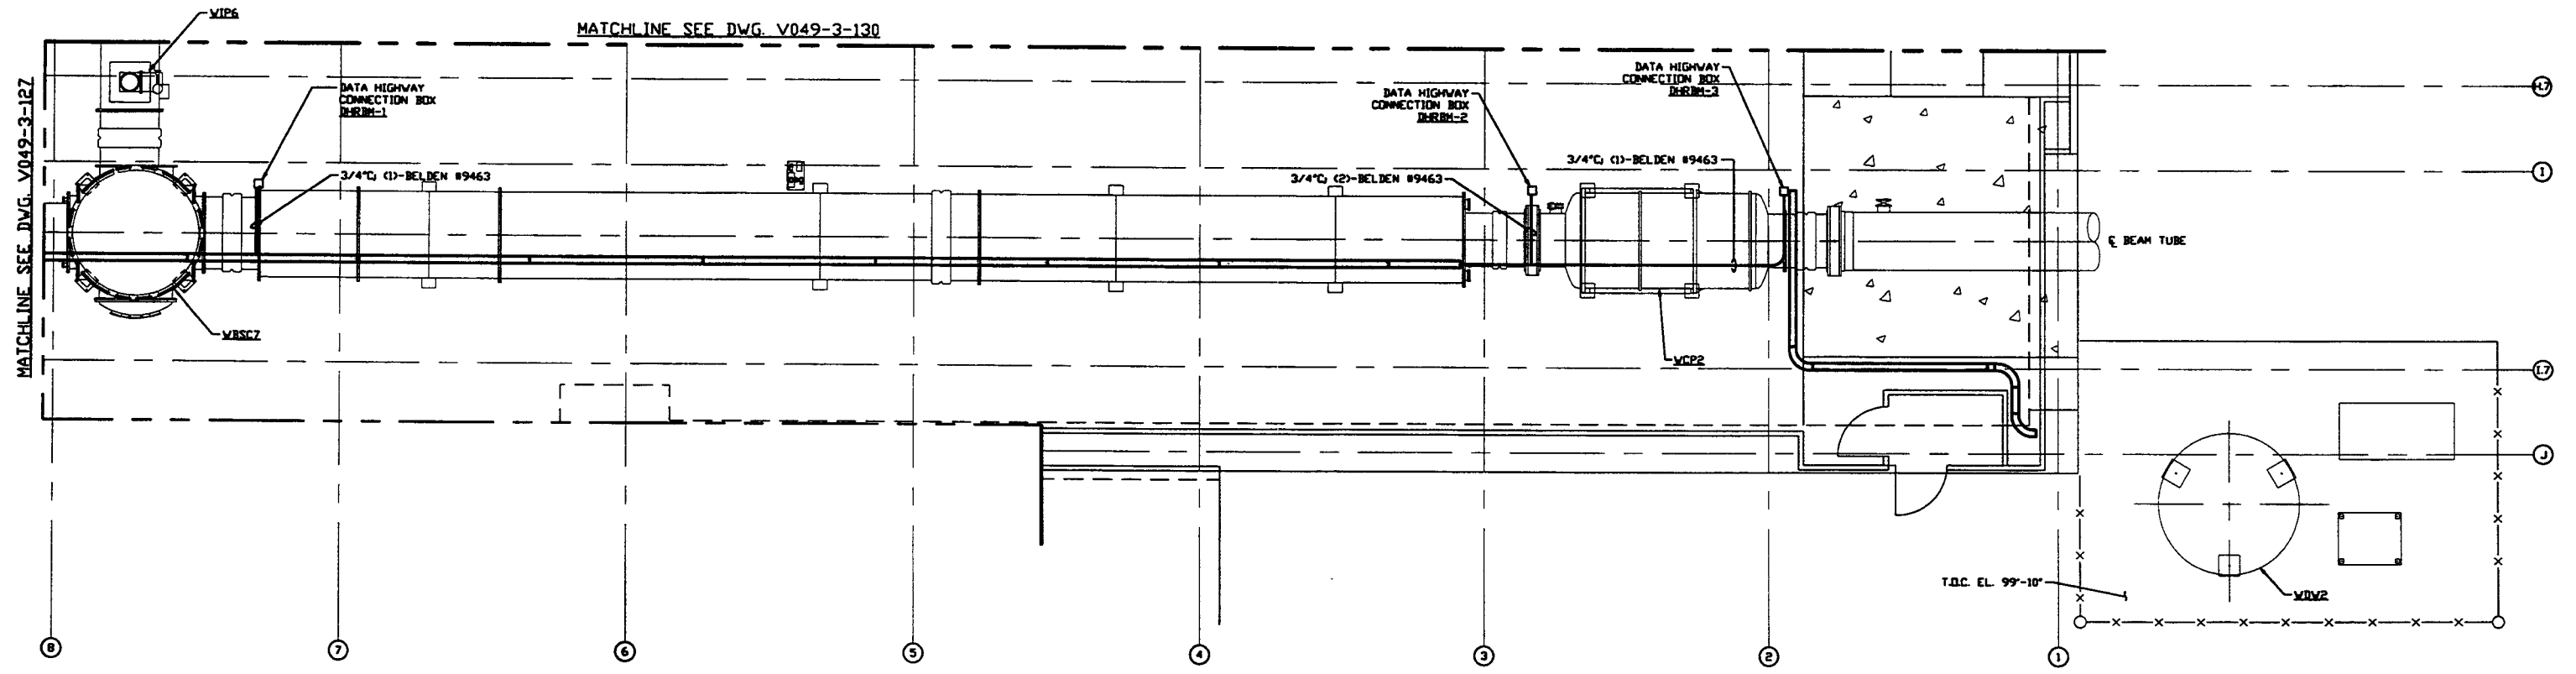

RIGHT BEAM MANIFOLD PLAN @ EL. 100'-0"

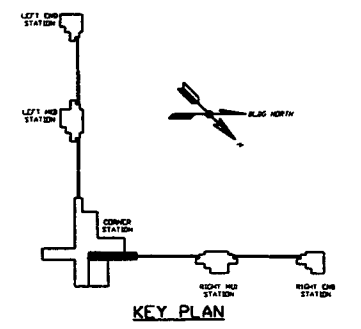

PROPRIETARY AND CONFIDENTIAL		THIS DOCUMENT CONTAINS PROPRIETARY INFORMATION BELONGING TO PROCESS SYSTEMS INTERNATIONAL, INC. OR ITS AFFILIATED COMPANIES AND SHALL BE USED ONLY FOR THE PURPOSE FOR WHICH IT WAS SUPPLIED. IT SHALL NOT BE COPIED, REPRODUCED OR OTHERWISE DISCLOSED IN WHOLE OR IN PART TO OTHERS EXCEPT IN ACCORDANCE WITH THE TERMS OF ANY AGREEMENT UNDER WHICH IT WAS SUPPLIED OR WITH THE PRIOR WRITTEN CONSENT OF PROCESS SYSTEMS INTERNATIONAL, INC. AND SHALL BE RETURNED UPON REQUEST.		UNLESS OTHERWISE SPECIFIED DIMENSIONS ARE IN INCHES		TOLERANCES:		FRACTIONAL ±		ANGULAR ±		FINISHES:		DATE:		REV:		CHKD:		DRWN:		DATE:		DEC:		SCALE:		SHEET:		1 OF 1	
V049-3-131	DATA HIGHWAY INTERCONNECTION DIAGRAM WASHINGTON																														
V049-3-118	POWER PLAN WASHINGTON RIGHT BEAM MANIFOLD																														
V049-3-108	CABLE TRAY PLAN WASHINGTON RIGHT BEAM MANIFOLD																														
V049-3-002	WASHINGTON OVERALL SITE PLAN																														
V049-3-001	GENERAL NOTES & LEGEND																														
DWG. NO.	DESCRIPTION	DWG. NO.	DESCRIPTION	DO NOT SCALE THIS DRAWING		USED ON:		NEXT ASS'Y:		ISSUE DESCRIPTION		ISSUE DESCRIPTION		ISSUE DESCRIPTION		ISSUE DESCRIPTION		ISSUE DESCRIPTION		ISSUE DESCRIPTION		ISSUE DESCRIPTION		ISSUE DESCRIPTION		ISSUE DESCRIPTION		ISSUE DESCRIPTION			

PROCESS SYSTEMS INTERNATIONAL, INC.
 20 WALKUP DR. WESTBOROUGH, MASSACHUSETTS 01581 USA

DATA HIGHWAY PLAN
LIGO VACUUM EQUIPMENT
WASHINGTON SITE
RIGHT BEAM MANIFOLD

CAD FILE: V0493129
 SIZE: D
 DWG. NO.: V049-3-129
 REV: 2

SCALE: 3/16" = 1' - 0"
 SHEET: 1 OF 1

LIGO-D960572-02-V