
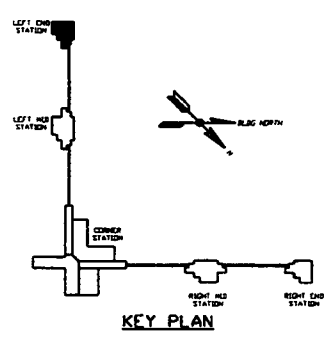
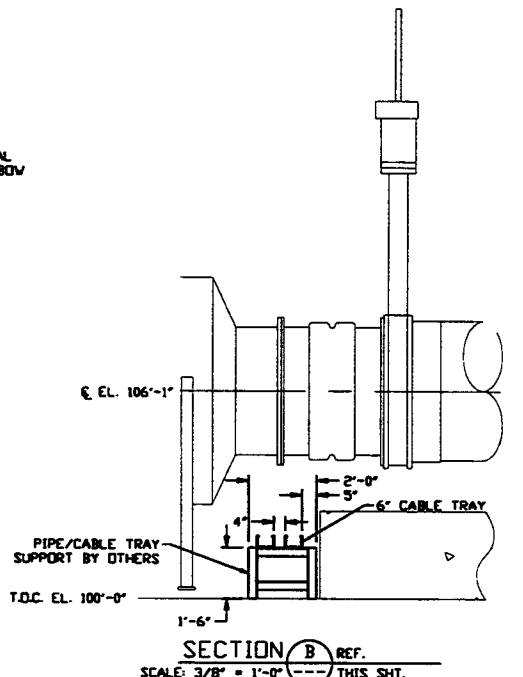
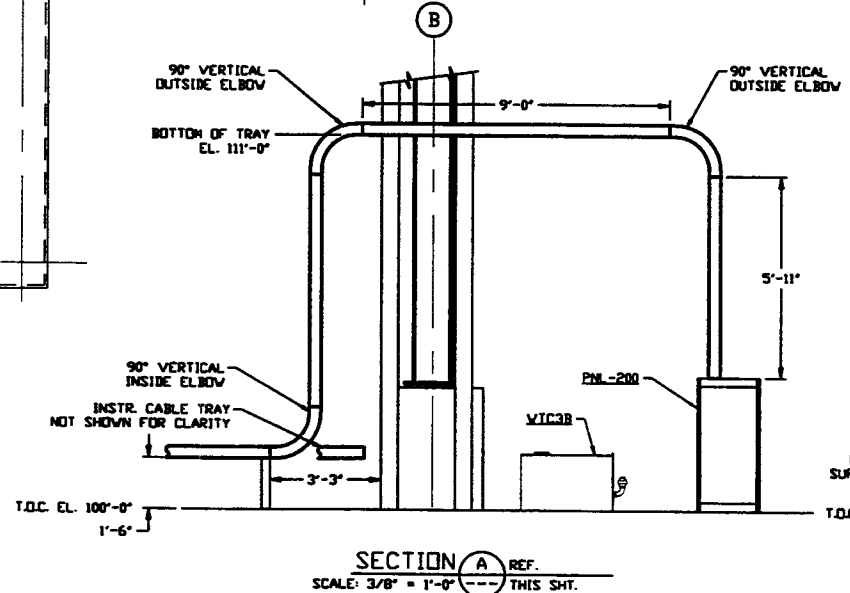
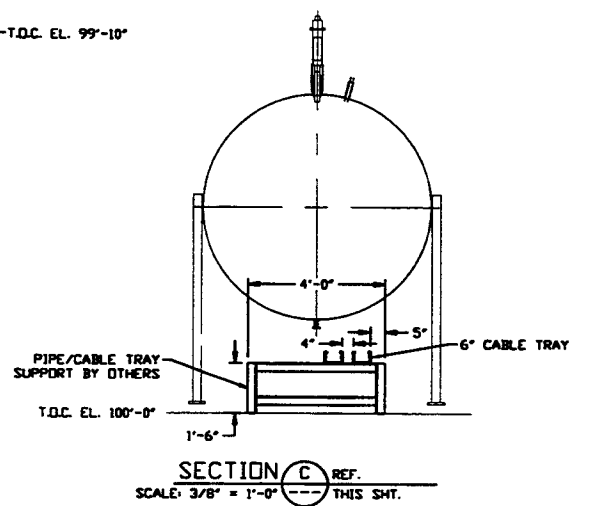


- NOTES:**
- 1.) FOR GENERAL NOTES & LEGEND SEE PSI DWG. #V049-3-001 SHT. 1.
  - 2.) FOR LIST OF CIVIL CONTRACTOR REFERENCE PSI DWG. #V049-3-001 SHT. 2.
  - 3.) ALL CABLE TRAY LENGTHS ARE 12'-0" UNLESS OTHERWISE SPECIFIED.
  - 4.) ALL CABLE TRAY SHALL BE GROUNDED PER M.E.C.
  - 5.) ALL CABLE TRAY SHALL BE FIELD SUPPORTED.
  - 6.) CABLE TRAY FOR IDN PUMP POWER CABLES SHALL BE LABELED "DANGER HIGH VOLTAGE".
  - 7.) CABLE TRAY SHALL BE LADDER TYPE AND SHALL MEET LOAD/SPAN CLASS DESIGNATION 16A. CABLE TRAY SHALL BE OF ALUMINUM CONSTRUCTION.
  - 8.) CABLE TRAY SHALL HAVE SIDE CHANNEL FLANGES IN.
  - 9.) DIMENSIONS TO CABLE TRAY ARE MEASURED TO THE OUTSIDE EDGE OF FLANGE.

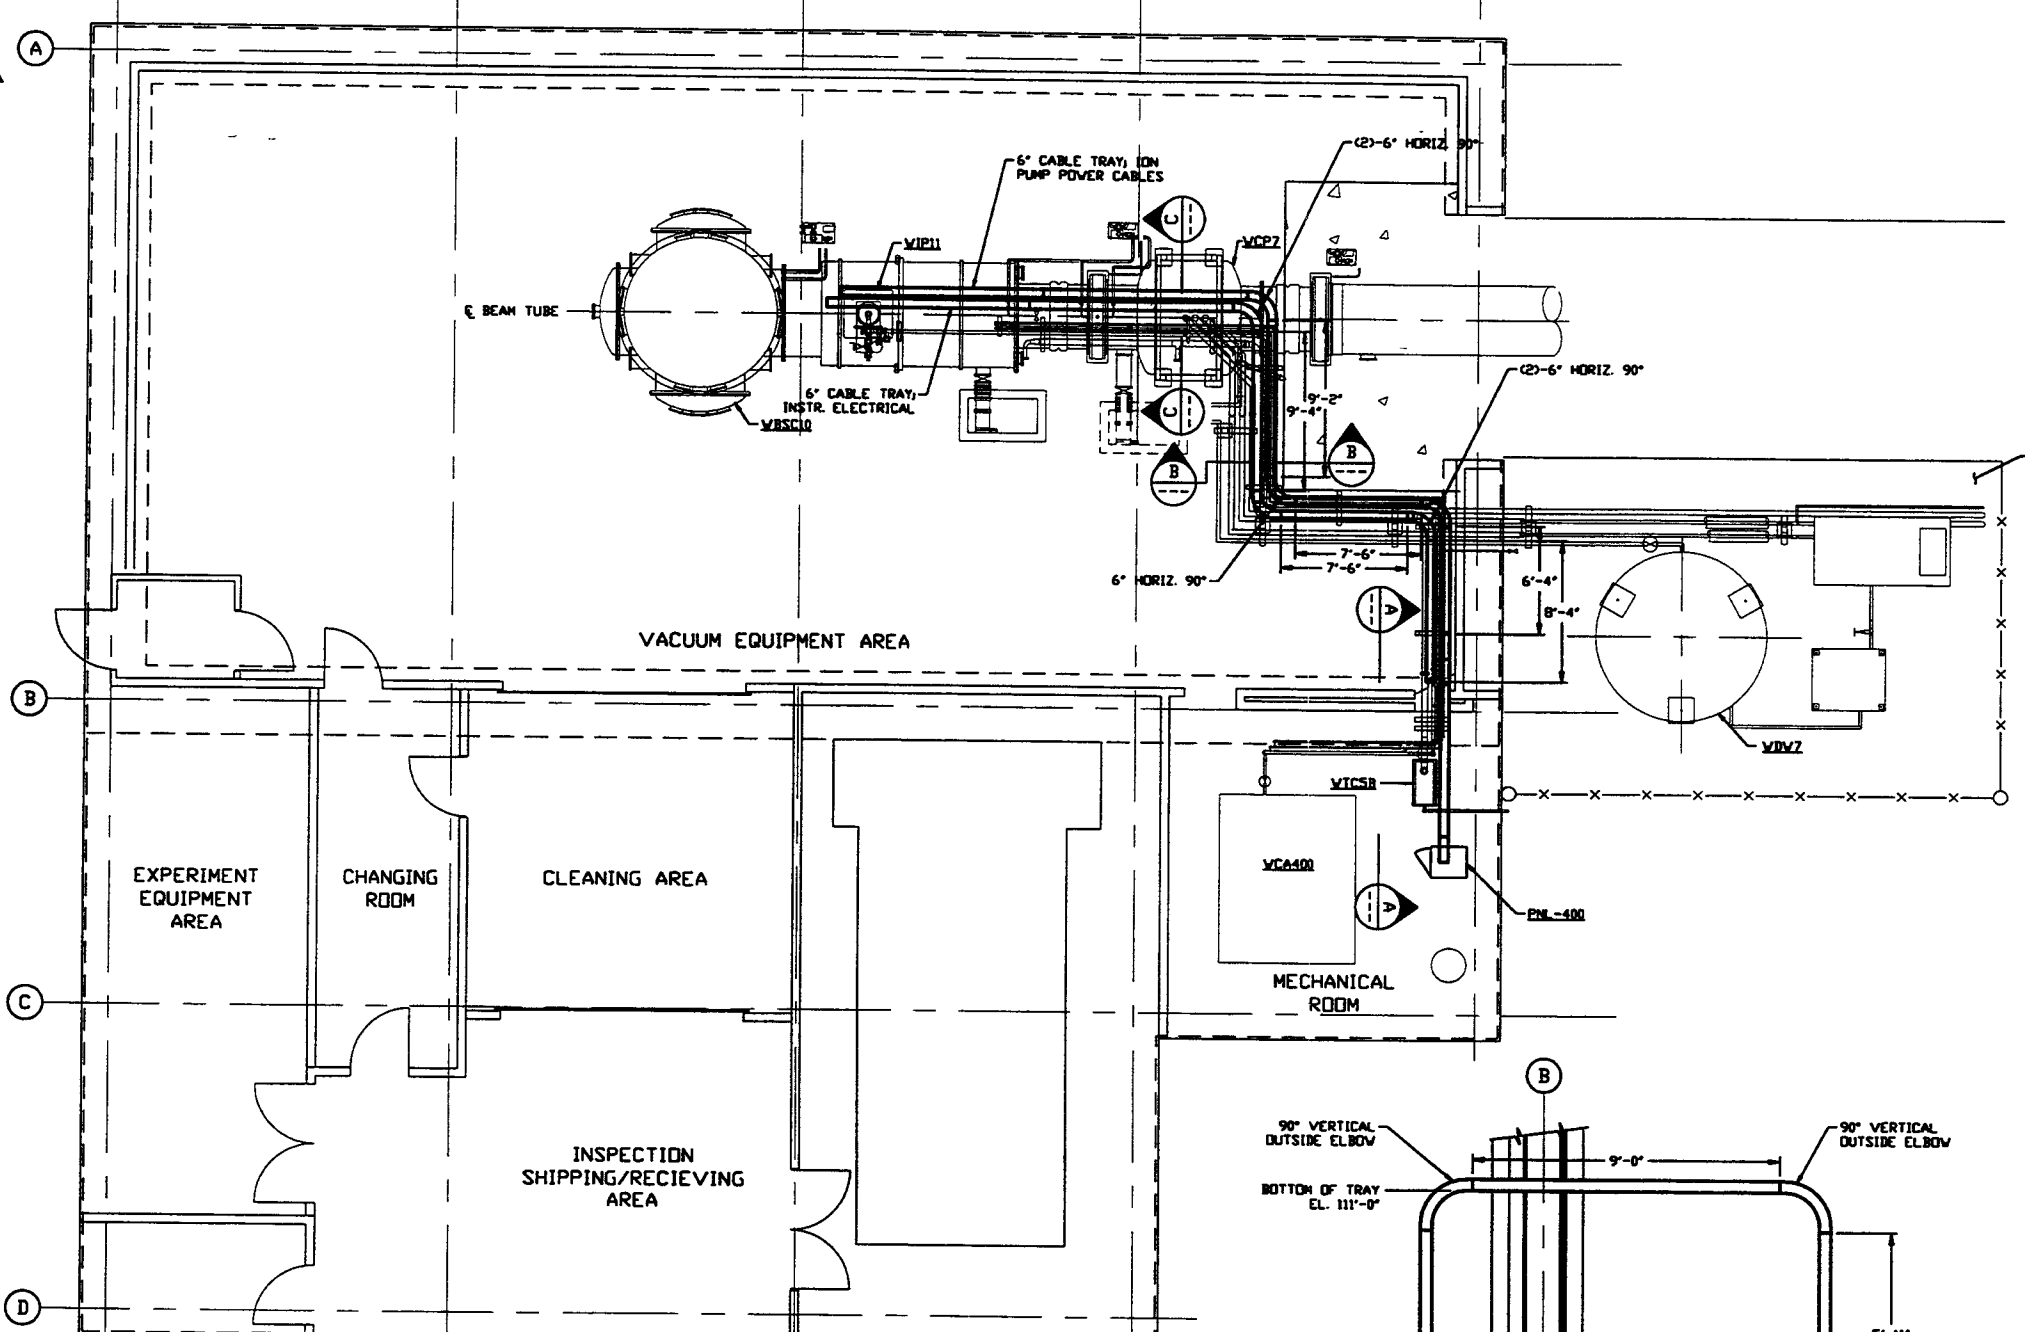

LEFT END STATION PLAN @ EL. 100'-0"

<b>PROPRIETARY AND CONFIDENTIAL</b>				UNLESS OTHERWISE SPECIFIED DIMENSIONS ARE IN INCHES				PROCESS SYSTEMS INTERNATIONAL, INC. 20 WALKUP DR. WESTBOROUGH, MASSACHUSETTS 01581 USA				
THIS DOCUMENT CONTAINS PROPRIETARY INFORMATION BELONGING TO PROCESS SYSTEMS INTERNATIONAL, INC. OR ITS AFFILIATED COMPANIES AND SHALL BE USED ONLY FOR THE PURPOSE FOR WHICH IT WAS SUPPLIED. IT SHALL NOT BE COPIED, REPRODUCED OR OTHERWISE USED, NOR SHALL SUCH INFORMATION BE FURNISHED IN WHOLE OR IN PART TO OTHERS EXCEPT IN ACCORDANCE WITH THE TERMS OF ANY AGREEMENT UNDER WHICH IT WAS SUPPLIED OR WITH THE PRIOR WRITTEN CONSENT OF PROCESS SYSTEMS INTERNATIONAL, INC. AND SHALL BE RETURNED UPON REQUEST.				TOLERANCES: FRACTIONAL 2 ANGULAR 30°-30' BOND 42° TWO PLACE DECIMAL 0.05 FINISHED SURFACE DIM. BREAK CORNERS IN REMOVE ALL BURRS				CABLE TRAY PLAN LIGO VACUUM EQUIPMENT WASHINGTON SITE LEFT END STATION				
VD49-3-002	WASHINGTON OVERALL SITE PLAN			2	ISSUE FOR CONSTRUCTION			FRB	RJV	05.12.97	0480	
VD49-3-001	GENERAL NOTES & LEGEND			1	ISSUE FOR FDR UPDATE & BID	REB	DMcV		RJV	11.25.96	0355	
DWG. NO.	DESCRIPTION	DWG. NO.	DESCRIPTION	0	ISSUE FOR FDR				FAB	RJV	04.26.96	0129
REFERENCE DRAWINGS				DO NOT SCALE THIS DRAWING				CAB. FILE				
				USED ON				VD493402				
				NEXT ASS'Y.				SIZE				
								D				
								V049-3-402				
								SHEET				
								1 OF 1				