

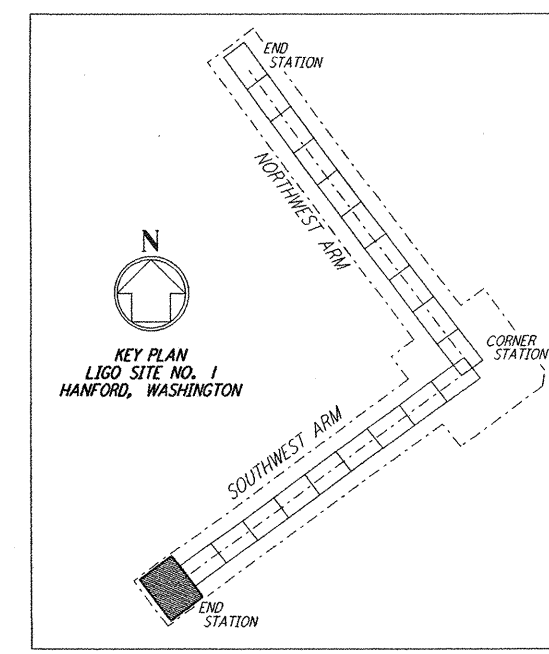
 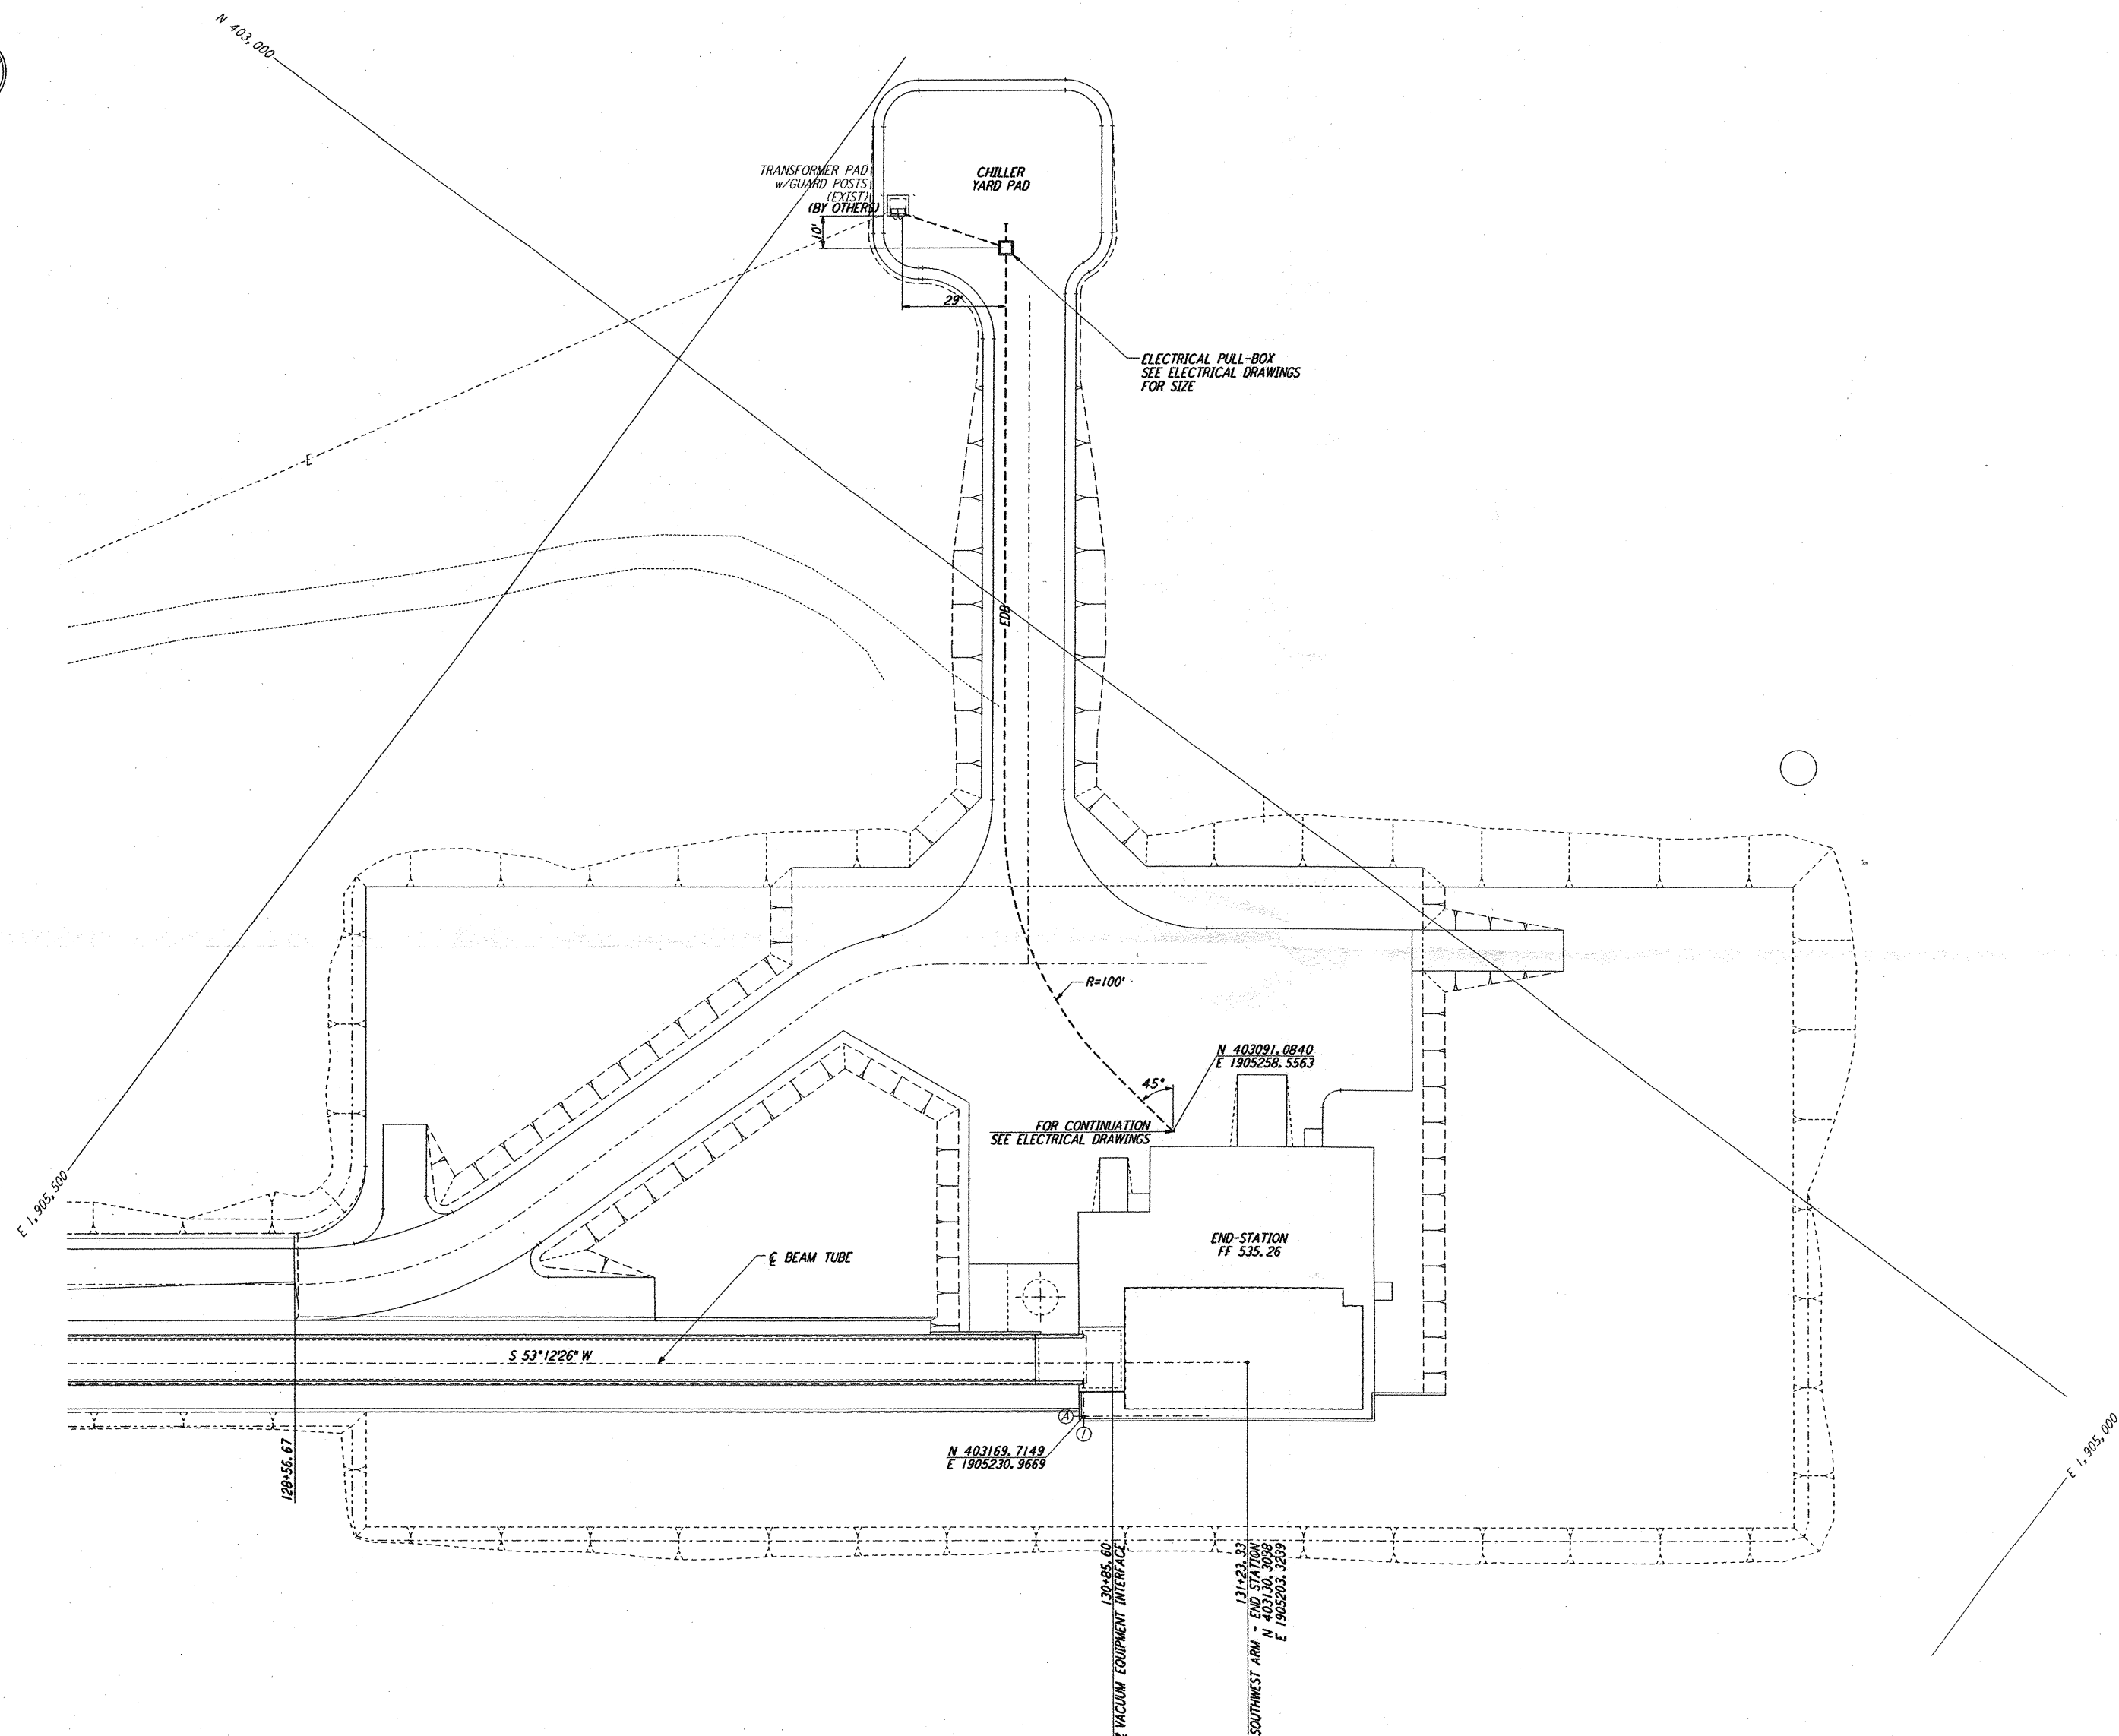


NOTES:
 1. SEE SHEET WA-C-002 FOR GENERAL NOTES, LEGEND AND ABBREVIATIONS.

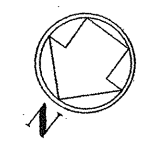

LIGO-D960732-00-O



REFERENCES		REVISIONS		DRAWN		CHECKED		ENGINEER		PROJ	
NO.	DATE	BY	CHKD	ENGR	PROJ	NO.	DATE	BY	CHKD	ENGR	PROJ
0	1-22-99	MEI	--	--	MDW						
A	4-19-96	WRB	TDM		MDW						

AS-BUILT DRAWINGS

ISSUED FOR AS BUILT
 CHANGE ORDER NO. 4

PARSONS
 100 WEST WALNUT STREET
 PASADENA, CALIFORNIA

LIGO
 CALIFORNIA INSTITUTE OF TECHNOLOGY
 MASSACHUSETTS INSTITUTE OF TECHNOLOGY

LASER INTERFEROMETER
 GRAVITATIONAL-WAVE OBSERVATORY
 BTE SITework & FABRICATION - HANFORD, WA

CIVIL
 SOUTHWEST ARM
 END-STATION
 UTILITY PLAN

SCALE: 1" = 20'
 CONTRACT NUMBER: PPI50969
 PROJECT NUMBER: 8094
BT-C-047

This document and the design it covers are the property of PARSONS. They are loaned only with the borrower's expressed written agreement that they will not be reproduced, copied, loaned, exhibited, or used in any other way, except by written consent from PARSONS to the borrower.

E
 D
 C
 B
 A
 The Jan 21 14:53:10 1999 C:\PLOT\OUT\ES3-19862.DWG 52885 K:\V38B2\c\047.dwg LIG08TF3.BDR