



TYPICAL BASE ELBOW SUPPORT 1 REF
 NTS LA-H-412

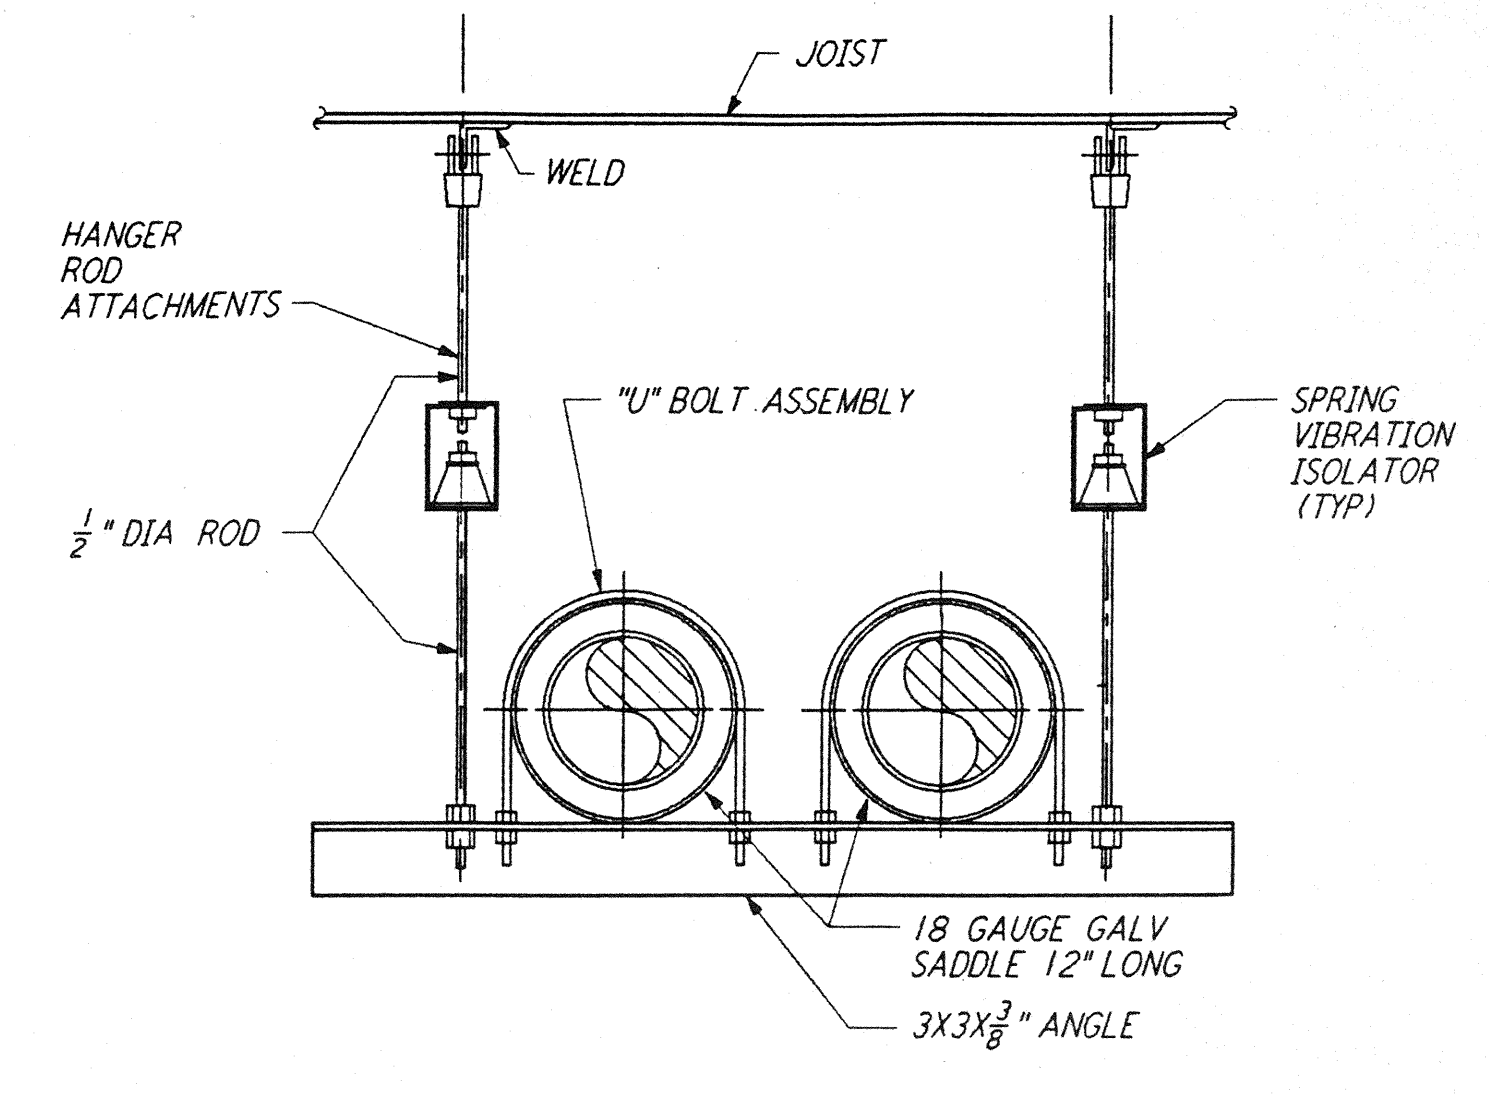


PIPE HANGER - TRAPEZE 2 REF
 NTS LA-H-412

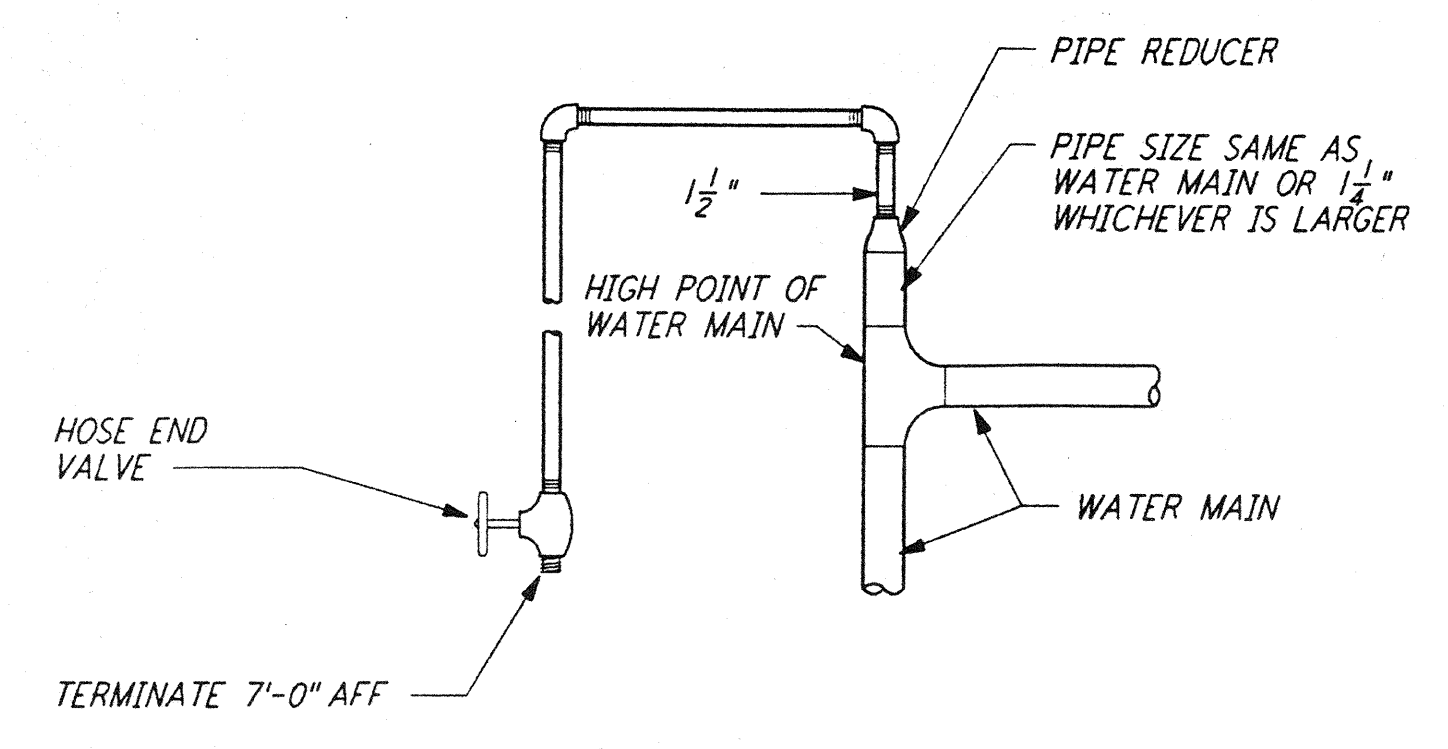

NOTE: LOCATE AT THE HIGHEST POINT OF THE CHILLED WATER SYSTEM.

MANUAL AIR VENT 3 REF
 NTS LA-H-412

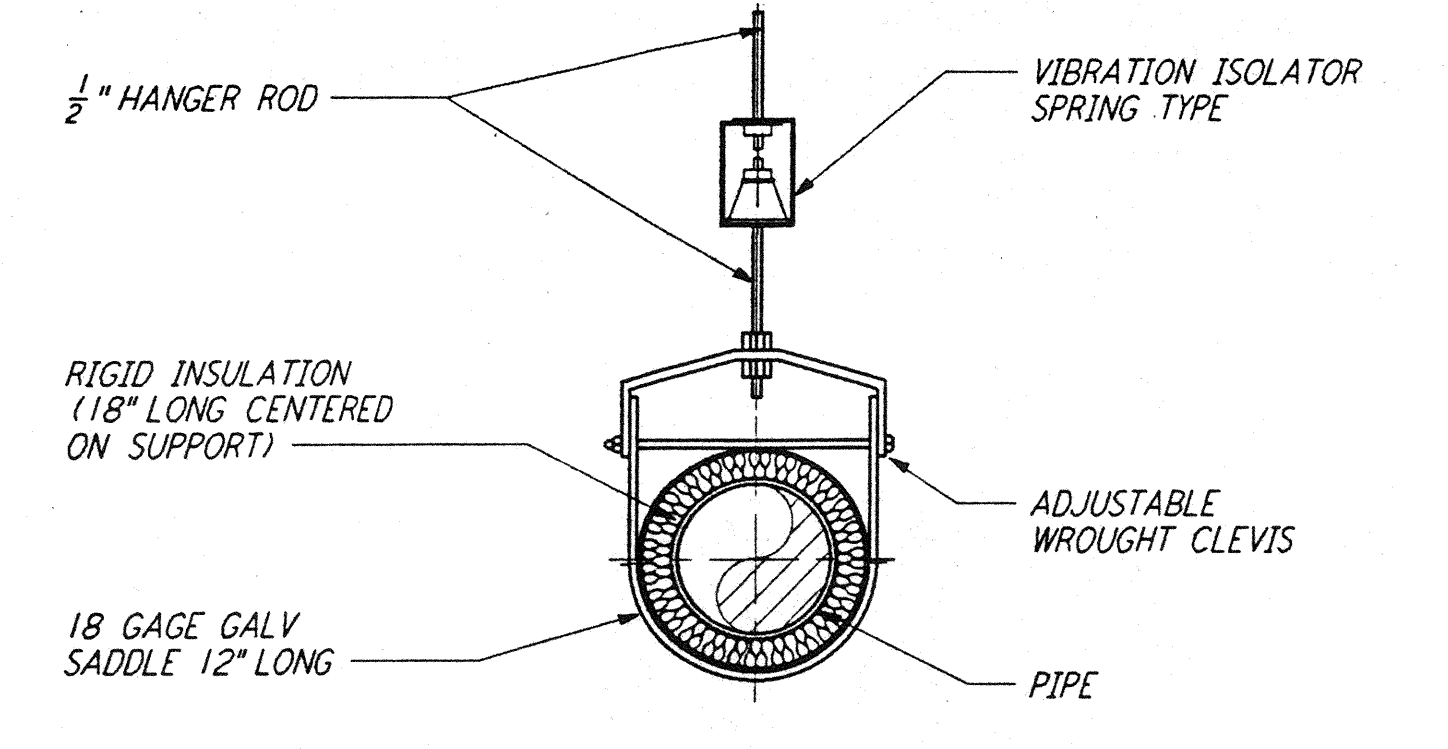

NOTE: MATCH OD OF INSULATION. MATCH OD OF PIPE FOR UNINSULATED LINES.

PIPE HANGER - SINGLE PIPE 4 REF
 NTS LA-H-412

NOTES:


1. FOR LEGEND, ABBREVIATIONS AND GENERAL NOTES SEE SHEETS LA-H-001 AND LA-H-002.

not be reproduced, copied, loaned, exhibited, or used in any other way, except by written consent from PARSONS to the borrower.

This document and the design it covers are the property of PARSONS. They are loaned only with the borrower's expressed written agreement that they will

| NO. | DATE | BY | CHKD | ENGR | PROJ | DESCRIPTION |
|-----|------|----|------|------|------|-------------|
| | | | | | | |
| | | | | | | |
| | | | | | | |
| | | | | | | |

| | | |
|-------------------------|------|----------|
| ISSUED FOR CONSTRUCTION | | |
| DRAWN | CLP | 11-15-96 |
| CHECKED | MM | 10-25-96 |
| ENGINEER | AA | 10-23-96 |
| PROJ | BDAA | 11/15/96 |

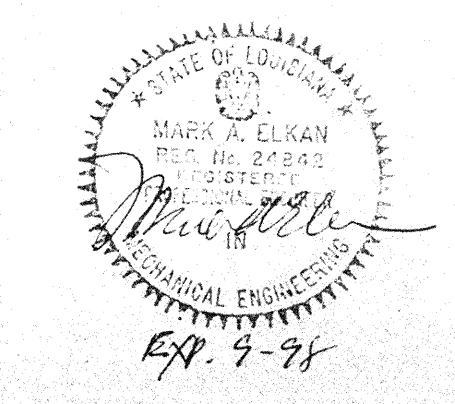

PARSONS
 100 WEST WALNUT STREET
 PASADENA, CALIFORNIA

LIGO
 CALIFORNIA INSTITUTE OF TECHNOLOGY
 MASSACHUSETTS INSTITUTE OF TECHNOLOGY

LASER INTERFEROMETER
 GRAVITATIONAL-WAVE OBSERVATORY
 SITE NO. 2 - LIVINGSTON, LOUISIANA

| | | | |
|-------------------------|--------------|-----------------|----------------|
| TITLE | SCALE | CONTRACT NUMBER | PROJECT NUMBER |
| HVAC DETAILS SHEET 2 | NONE | PP150969 | 8094 |
| DRAWING NO. | SHEET NUMBER | REVISIONS | |
| LA-H-412 | | | |