
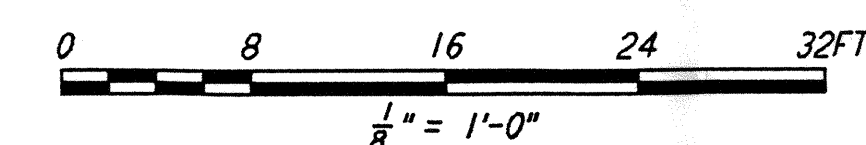
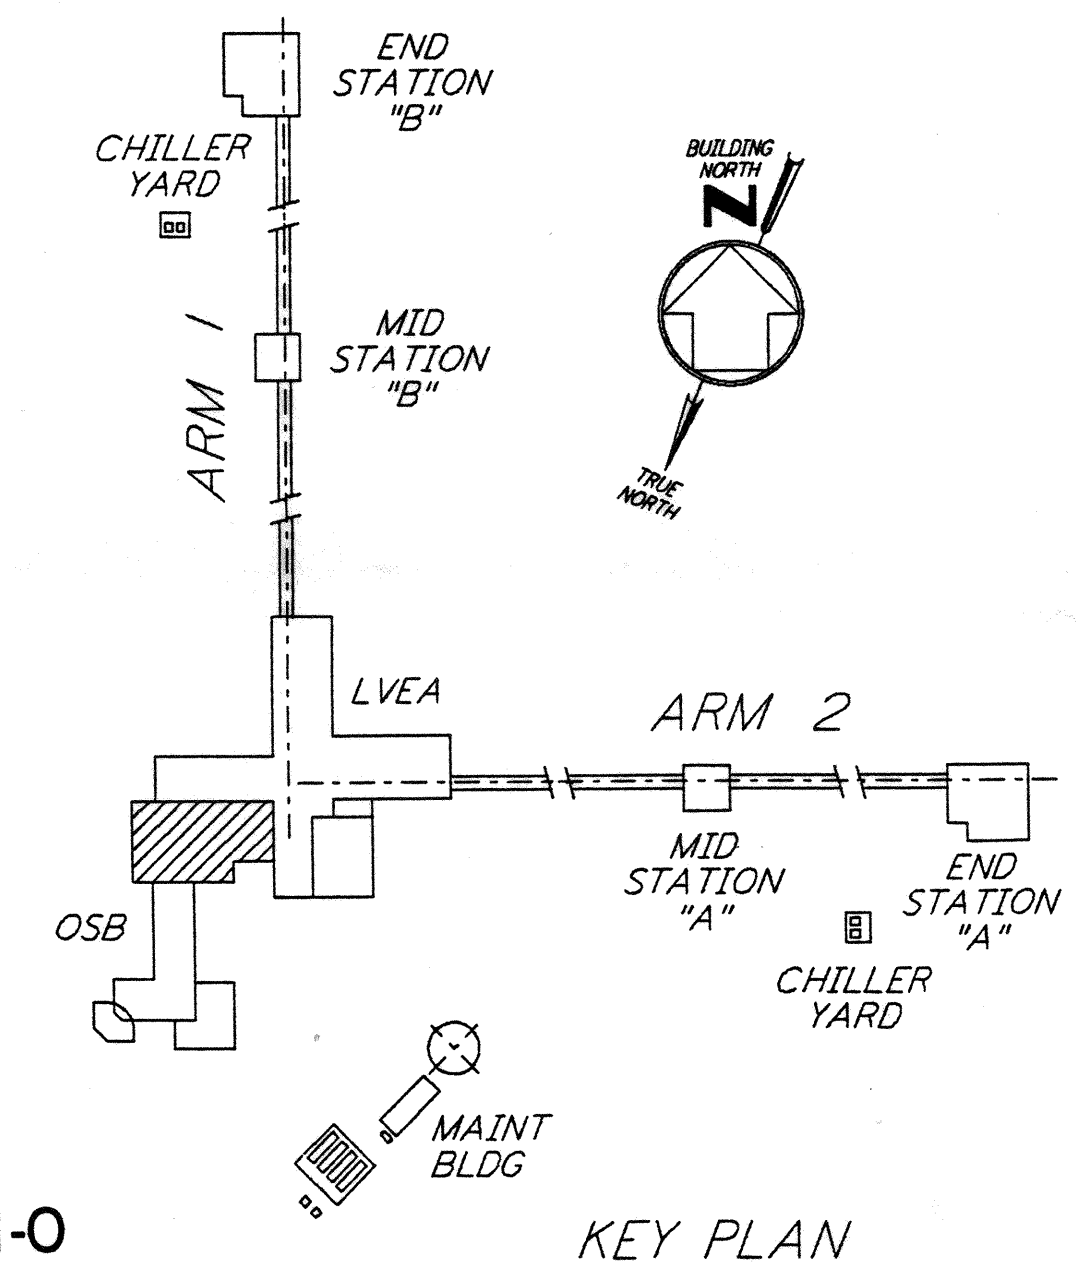


- NOTES:**
1. FOR PLAN SYMBOLS SEE DWG LA-E-002.
 2. WIRING FOR FIRE DETECTION SHALL BE CLASS "A". FOR FIRE ALARM DEVICES SHALL BE CLASS "B". WIRING INSTALLED IN CONCEALED CONDUIT FOR FIRE DETECTION AND SECURITY SYSTEMS SHALL BE DONE BY OTHERS.
 3. DUCT MOUNTED SMOKE DETECTORS SHALL BE PROVIDED WITH AN AUXILIARY RELAY CONTACT (N.C.) FOR EQUIPMENT SHUT-DOWN.
 4. COORDINATE SMOKE DETECTOR LOCATIONS WITH CLEAN AGENT DISCHARGE NOZZLES.
 5. COORDINATE AHU LOCATIONS WITH DUCT MOUNTED SMOKE DETECTORS.

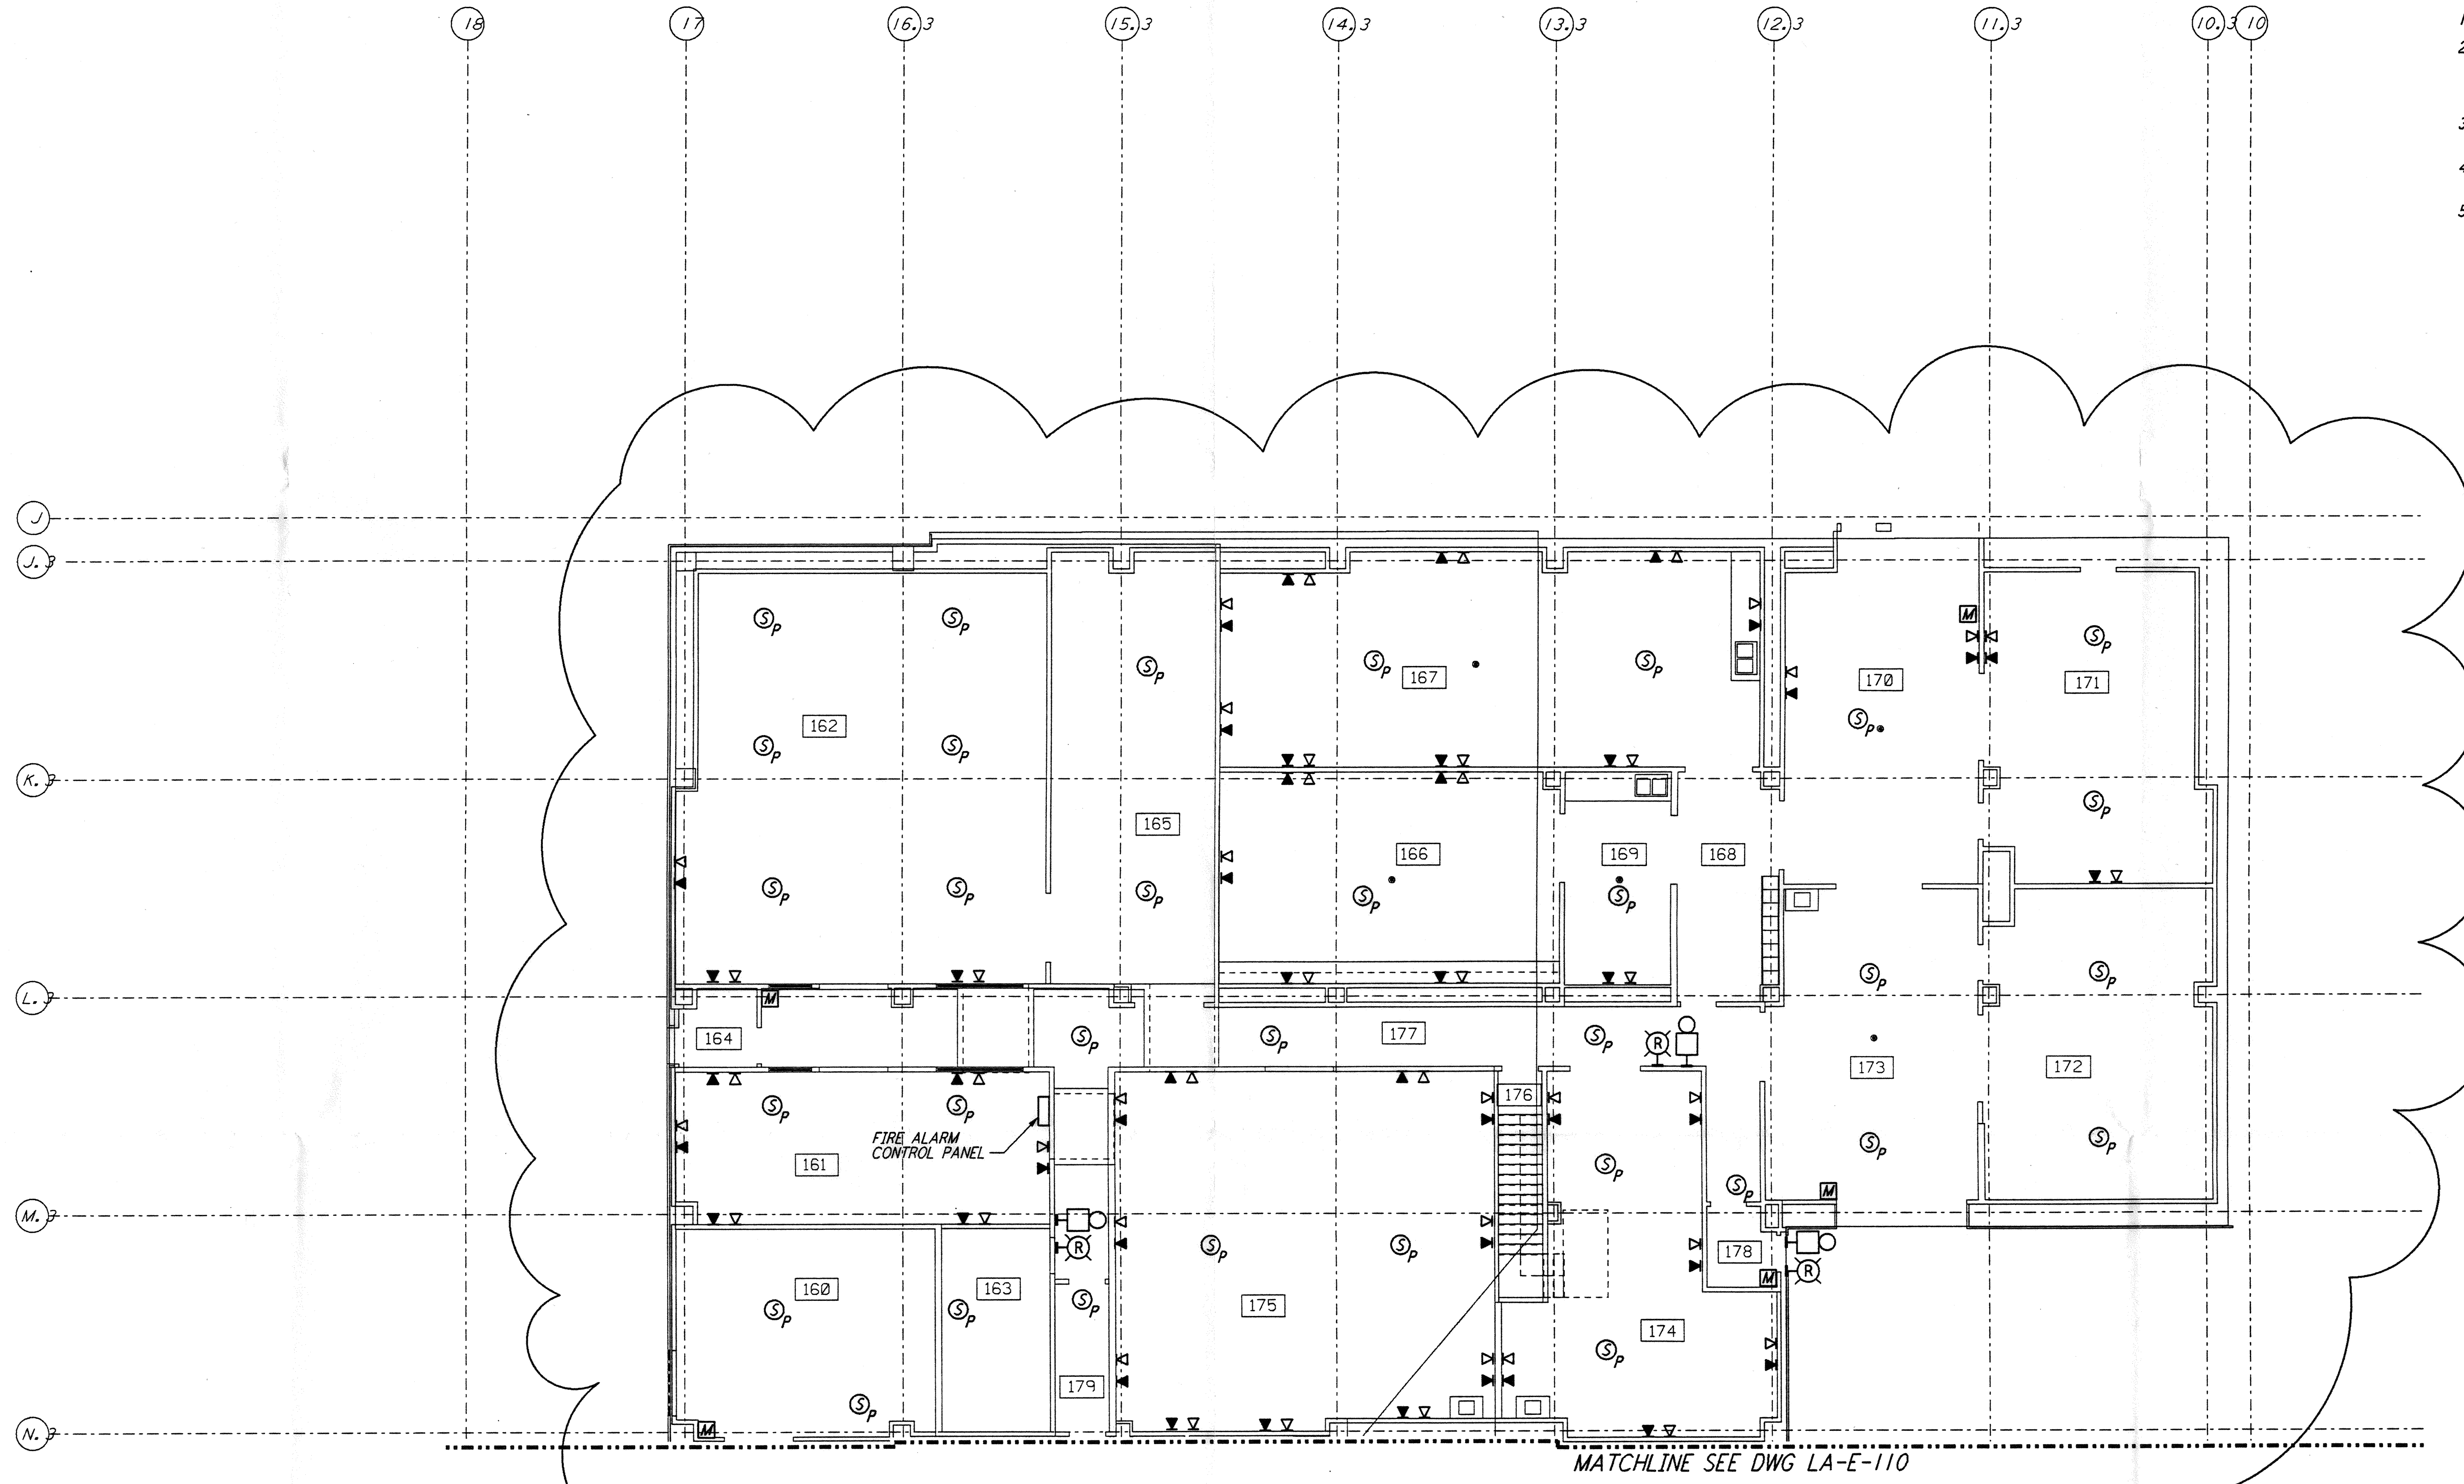


LIGO-D961013-01-0

KEY PLAN

This document and the design it covers are the property of PARSONS. They are loaned only with the borrower's expressed written agreement that they will not be reproduced, copied, loaned, exhibited, or used in any other way, except by written consent from PARSONS to the borrower.

NO.	DATE	BY	CHKD	ENGR	PROJ	DESCRIPTION
1	2-28-97	J. G.	[Signature]	[Signature]	[Signature]	GENERAL REVISIONS

ISSUED FOR CONSTRUCTION
 DRAWN M. M. 11-15-96
 CHECKED J. C. L. 7-24-96
 ENGINEER K. C. R. 10-25-96
 PROJ 7. D. M. 11-15-96

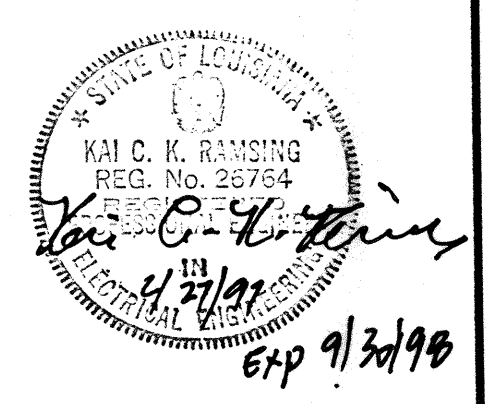

PARSONS
 100 WEST WALNUT STREET
 PASADENA, CALIFORNIA

LIGO
 CALIFORNIA INSTITUTE OF TECHNOLOGY
 MASSACHUSETTS INSTITUTE OF TECHNOLOGY

LASER INTERFEROMETER
 GRAVITATIONAL-WAVE OBSERVATORY
 SITE NO. 2 - LIVINGSTON, LOUISIANA

TITLE	SCALE	CONTRACT NUMBER	PROJECT NUMBER
ELECTRICAL CORNER STATION OSB LAB AREA FIRE DET & SECURITY PLAN	NONE	PP150969	8094
SHEET NUMBER	REVISIONS		
LA-E-111	[Revision Table]		