

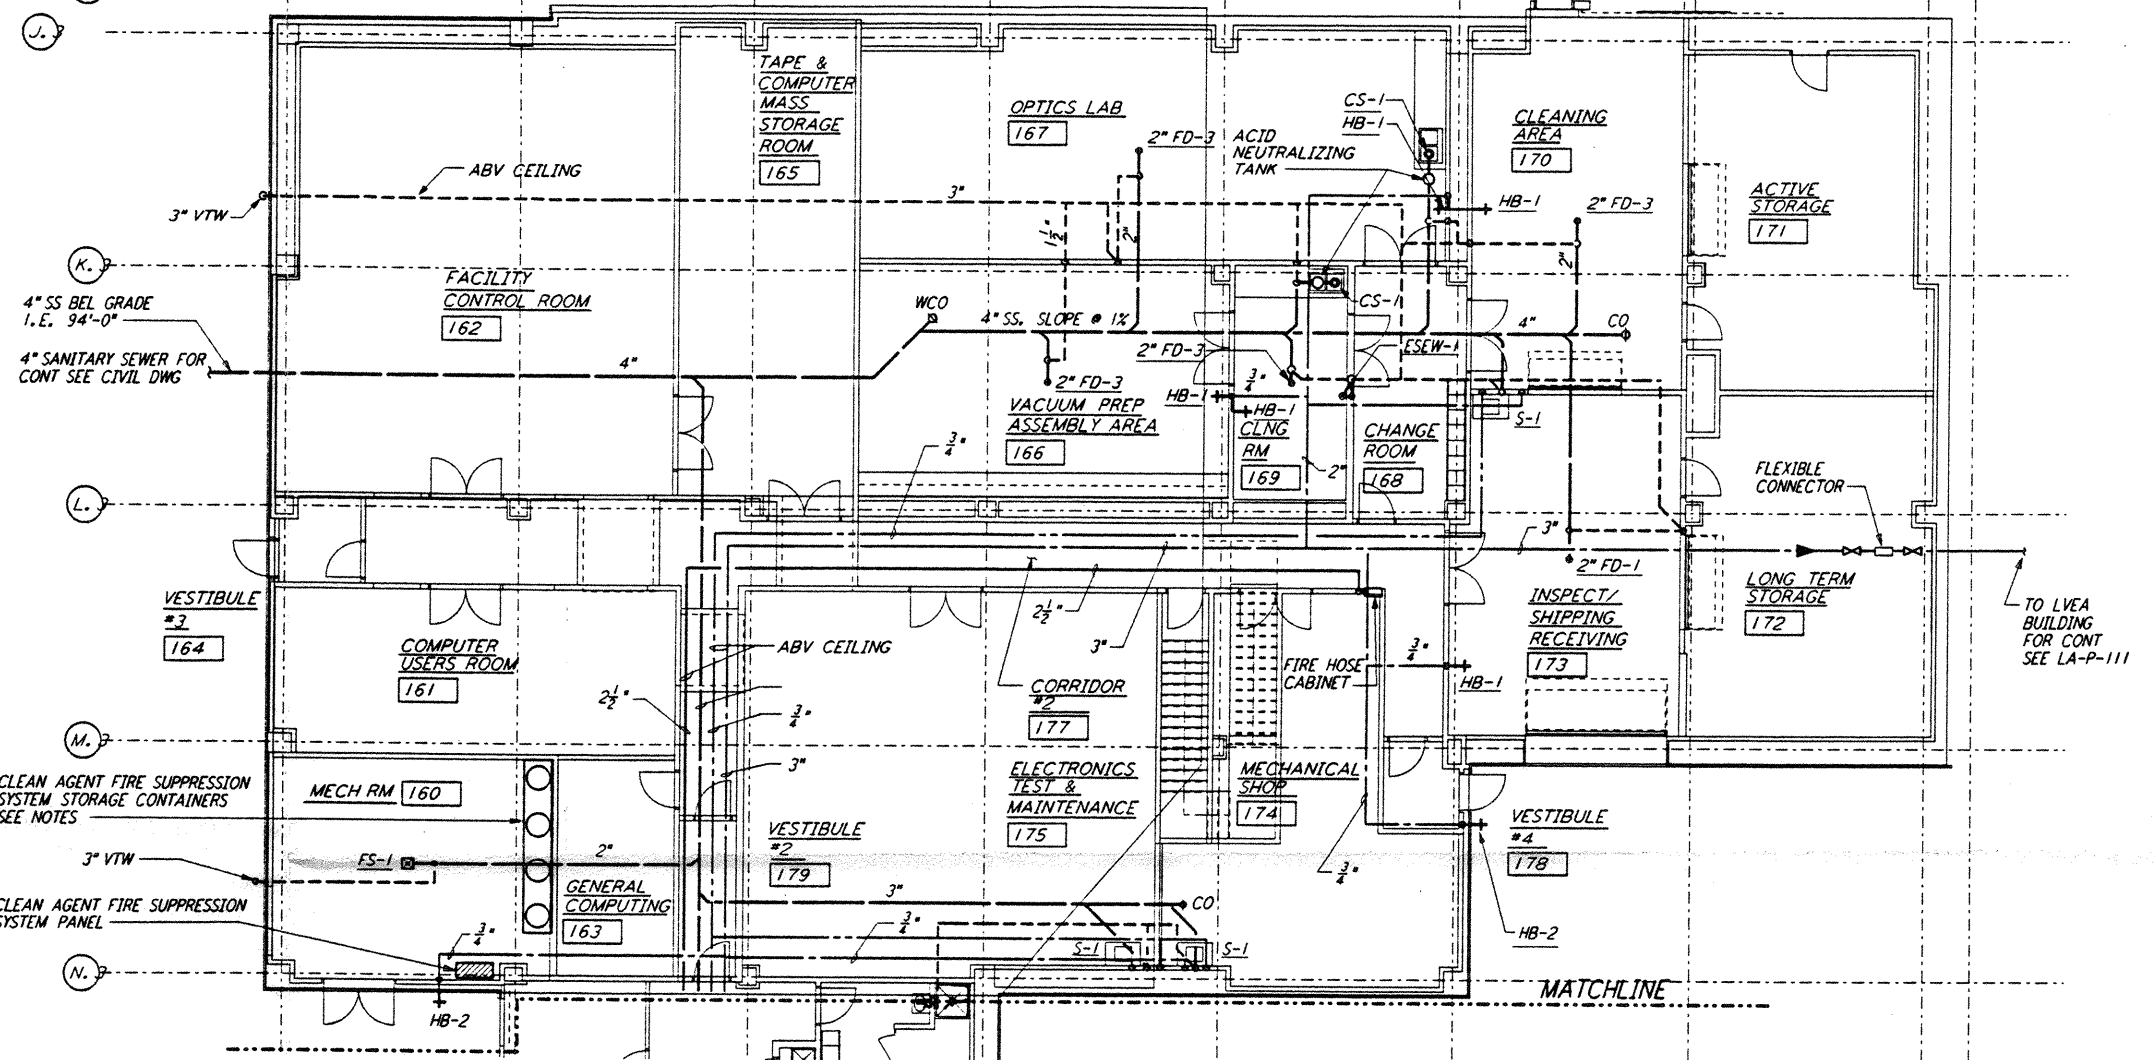


not be reproduced, copied, loaned, exhibited, or used in any other way, except by written consent from PARSONS to the borrower.

This document and the design it covers are the property of PARSONS. They are loaned only with the borrower's expressed written agreement that they will

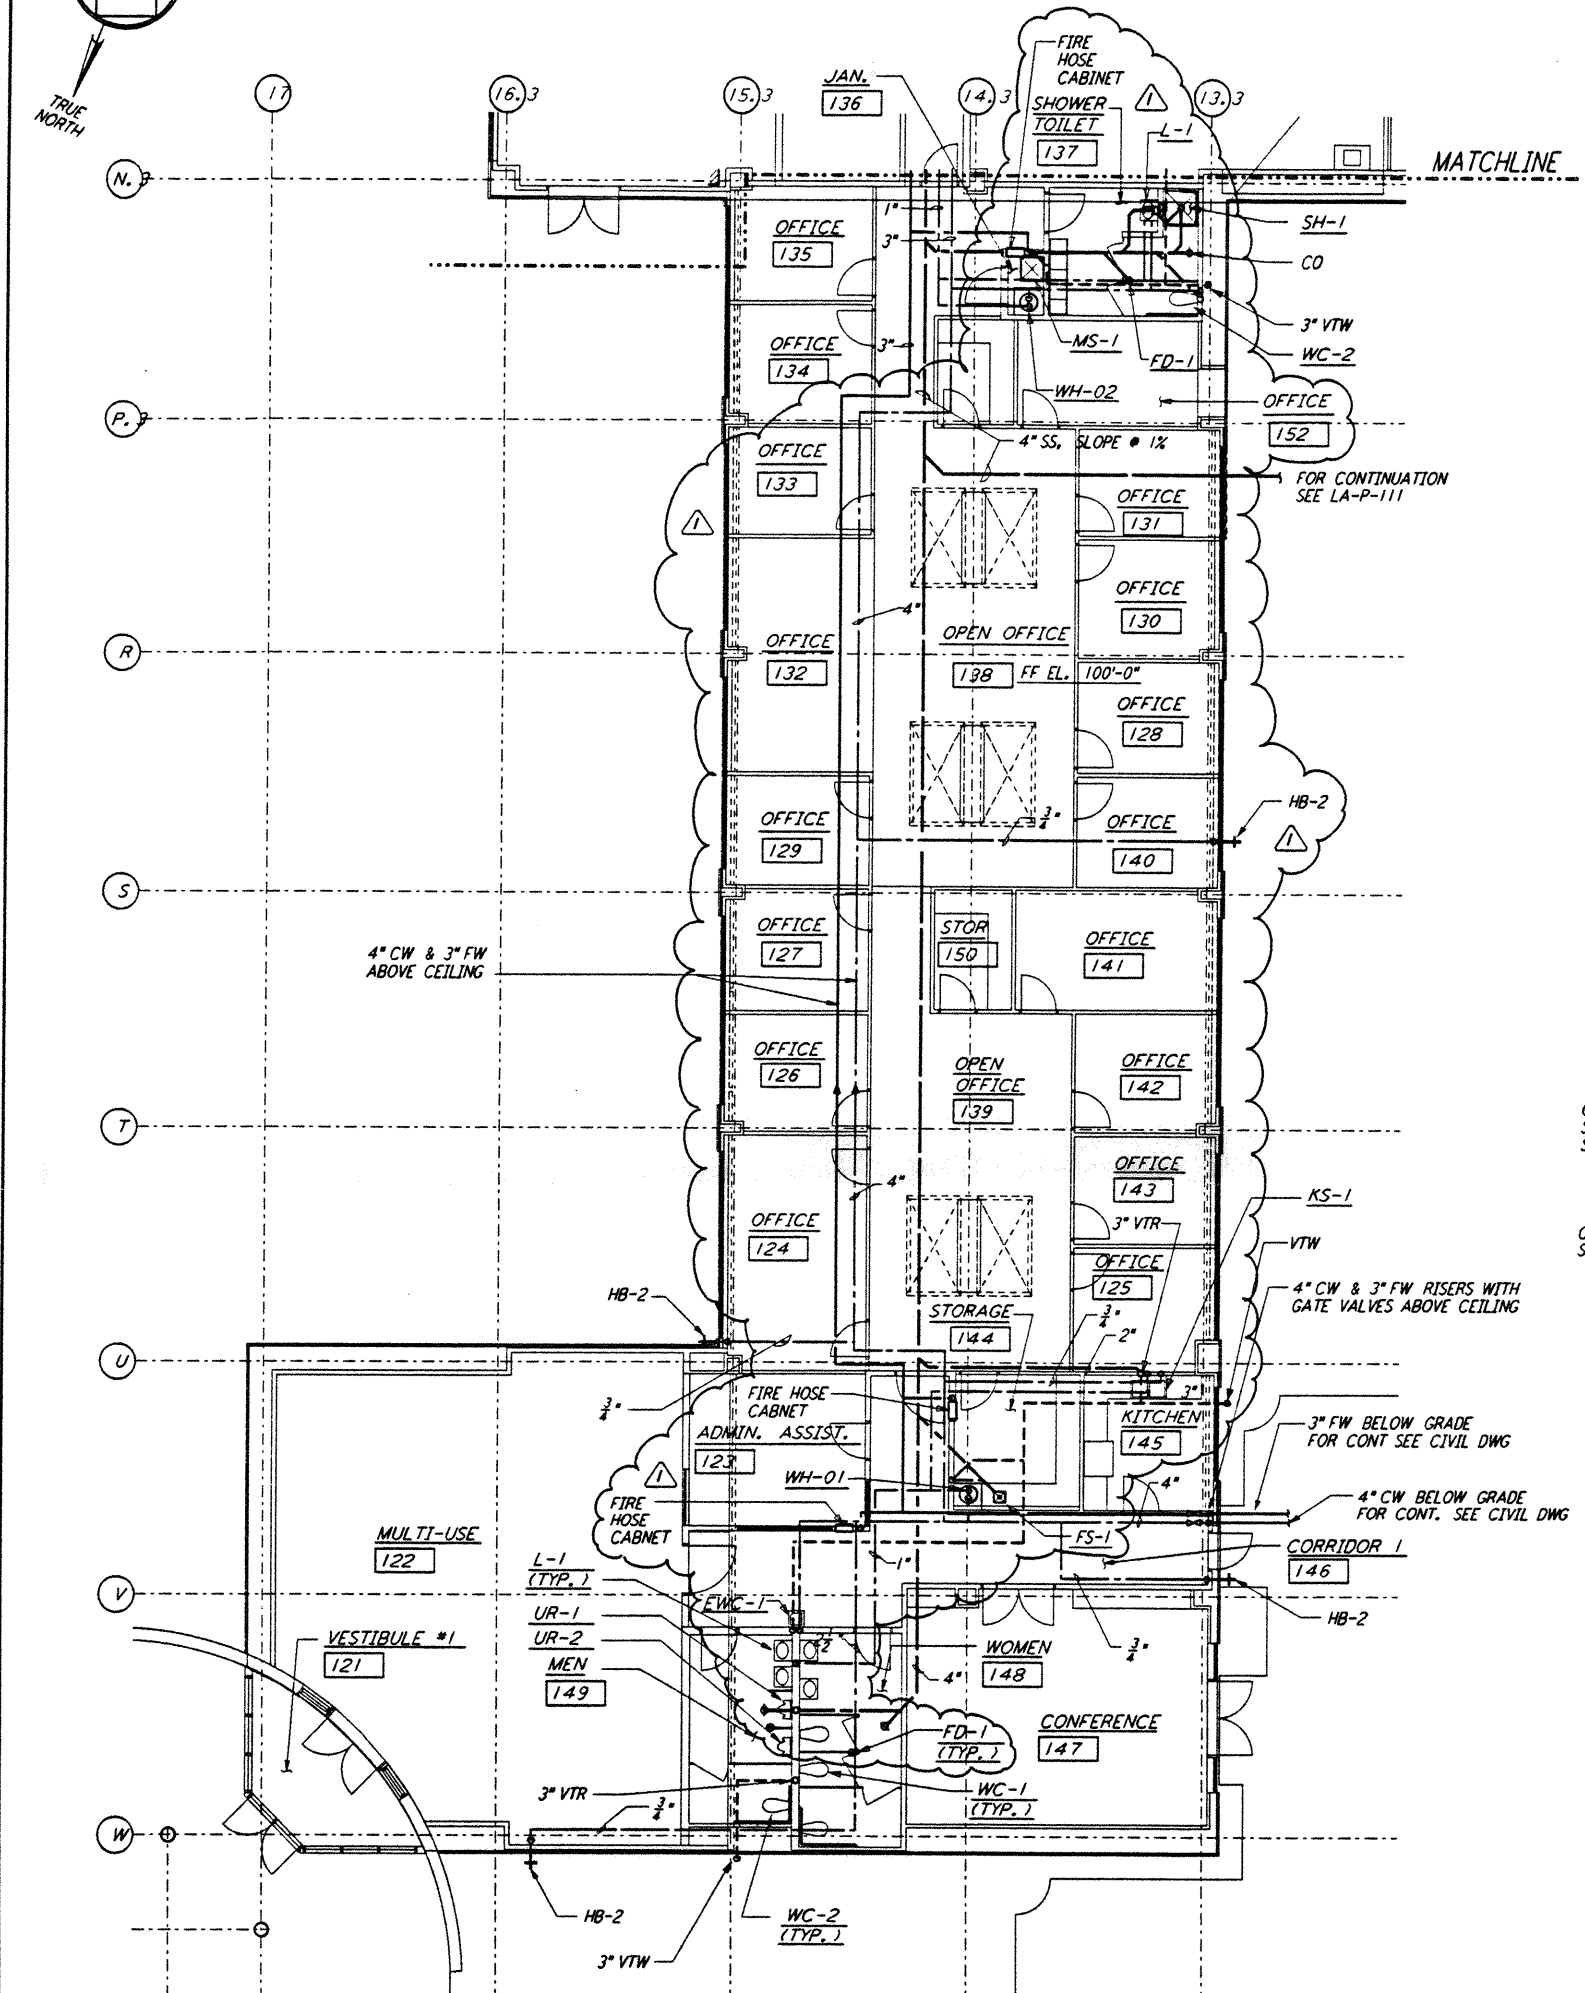


- NOTES:**
- A CLEAN AGENT FIRE SUPPRESSION SYSTEM SHALL BE PROVIDED ABOVE AND WITHIN THE DEPRESSED FLOOR SPACE, FOR THE FOLLOWING ROOMS:
 - FACILITY CONTROL ROOM [162]
 - TAPE & COMPUTER MASS STORAGE ROOM [165]
 - COMPUTER USERS ROOM [161]
 - GENERAL COMPUTING [163]
 - REFER TO THE PERFORMANCE TYPE SPECIFICATIONS FOR REQUIREMENTS AND DESIGN CRITERIA.

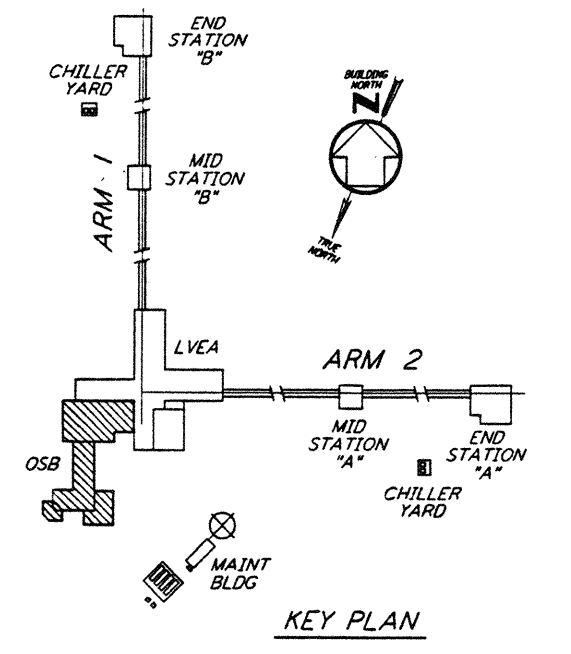

LIGO-D961049-01-0
 1" = 1'-0"

NO.	DATE	BY	CHKD	ENGR	PROJ	DESCRIPTION
1	3-20-97	WVK	AA	AA	TDM	REVISED PLUMBING PIPING LAYOUT

ISSUED FOR CONSTRUCTION
 DRAWN DG 11-15-96
 CHECKED ME 10-25-96
 ENGINEER AA 10-25-96
 PROJ TDM 11-15-96

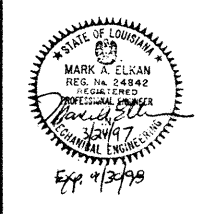

PARSONS
 100 WEST WALNUT STREET
 PASADENA, CALIFORNIA

LIGO
 CALIFORNIA INSTITUTE OF TECHNOLOGY
 MASSACHUSETTS INSTITUTE OF TECHNOLOGY

LASER INTERFEROMETER
 GRAVITATIONAL-WAVE OBSERVATORY
 SITE NO. 2 - LIVINGSTON, LOUISIANA

PLUMBING
 CORNER STATION
 OSB FLOOR PLAN

AS NOTED PP150969 8094
 SHEET NUMBER
LA-P-112