
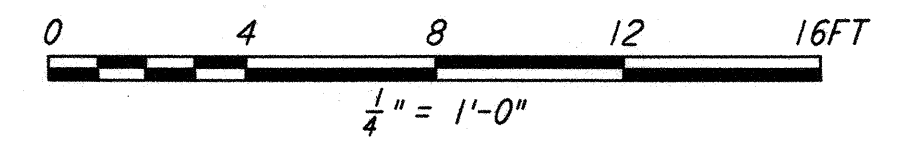
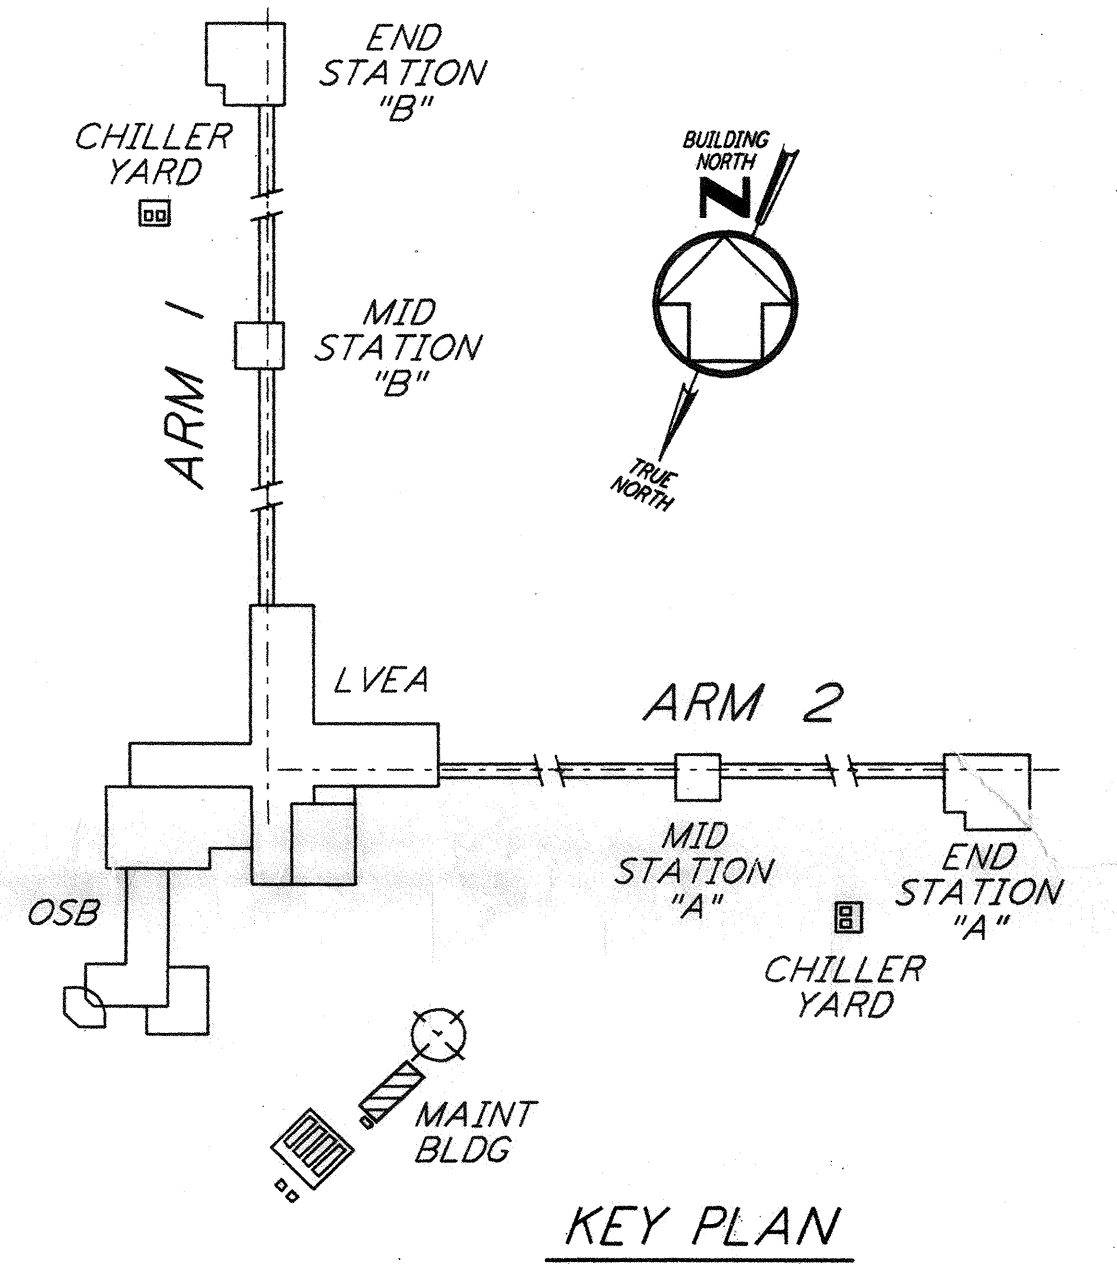


**NOTE:**  
 1. ALL EXTERIOR PIPING SHALL BE HEAT TRACED AND INSULATED.

not be reproduced, copied, loaned, exhibited, or used in any other way, except by written consent from PARSONS to the borrower.

This document and the design it covers are the property of PARSONS. They are loaned only with the borrower's expressed written agreement that they will

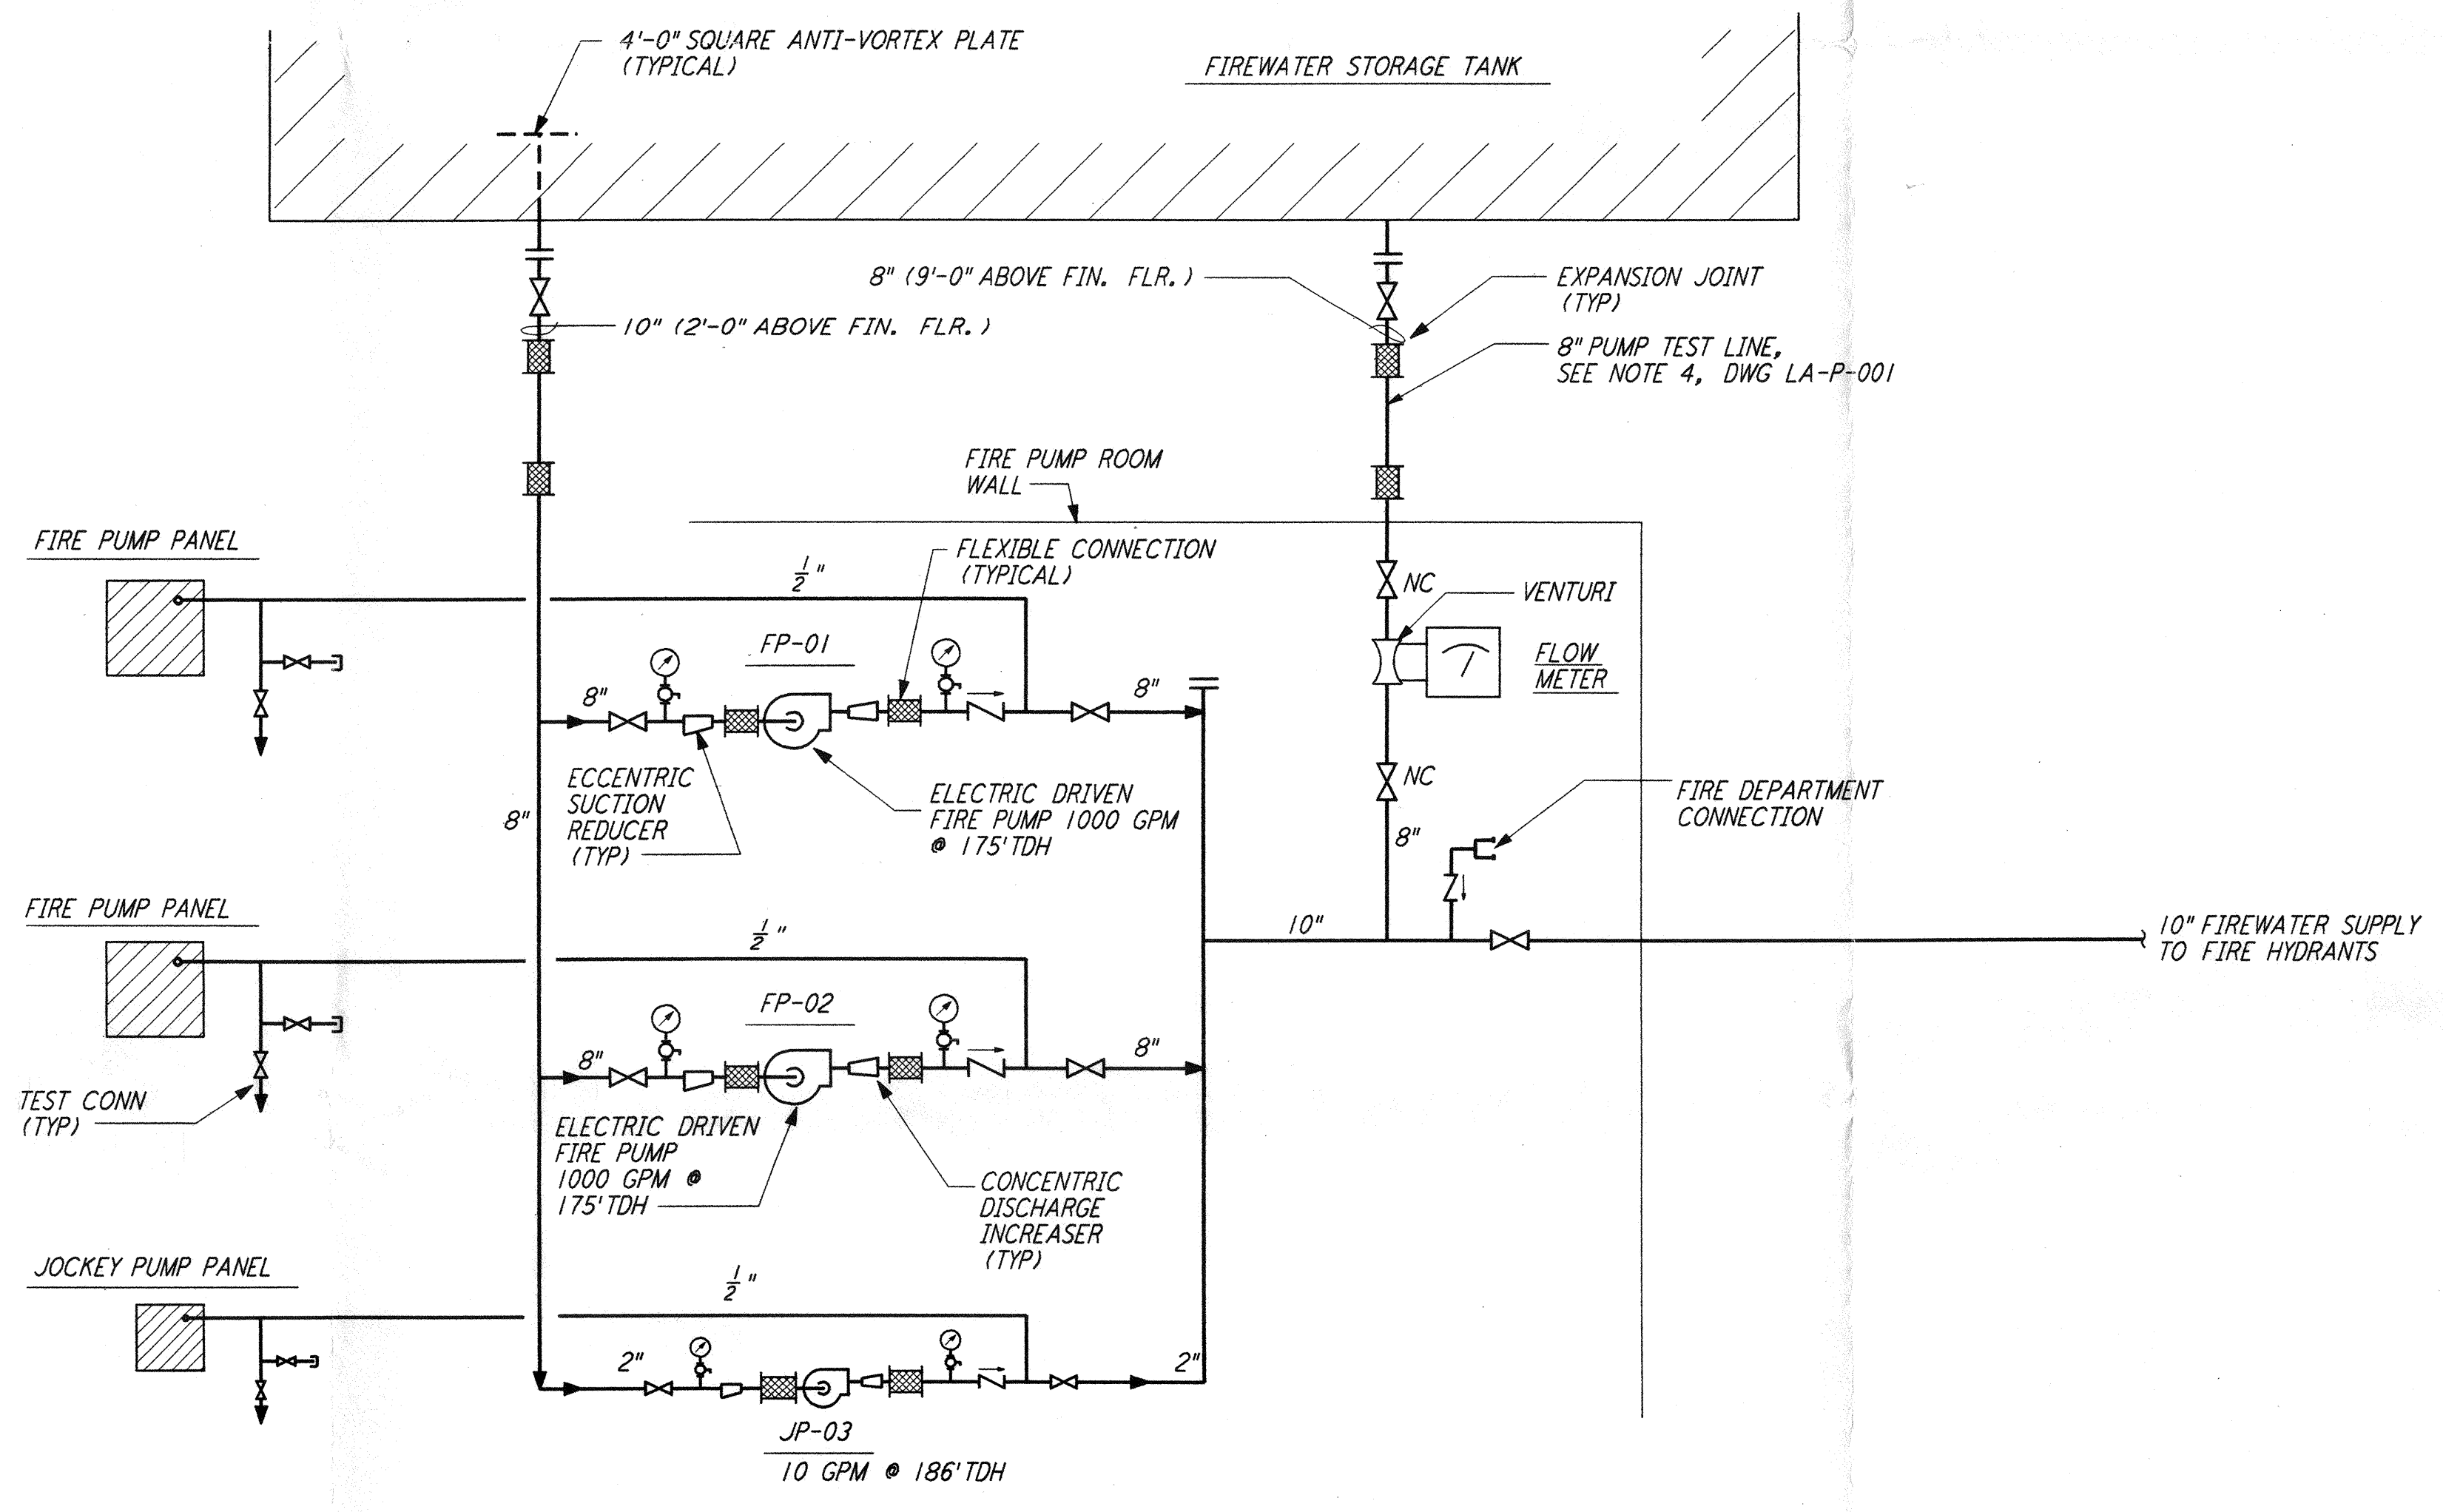

ISSUED FOR CONSTRUCTION	DATE	BY	CHKD	ENGR	PROJ
DRAWN	DG	11-15-96			
CHECKED	ME	10-25-96			
ENGINEER	AA	10-25-96			
PROJ	TDM	11-15-96			

**AS-BUILT DRAWINGS**

**PARSONS**  
 100 WEST WALNUT STREET  
 PASADENA, CALIFORNIA

**LIGO**  
 CALIFORNIA INSTITUTE OF TECHNOLOGY  
 MASSACHUSETTS INSTITUTE OF TECHNOLOGY

**LIGO-D961050-01-0**

LASER INTERFEROMETER  
 GRAVITATIONAL-WAVE OBSERVATORY  
 SITE NO. 2 - LIVINGSTON, LOUISIANA

TITLE	SCALE	CONTRACT NUMBER	PROJECT NUMBER
PLUMBING CORNER STATION MAINTENANCE BUILDING FLOOR PLAN & FLOW DIAGRAM	AS NOTED	PP150969	8094
SHEET NUMBER	REVISIONS		
<b>LA-P-113</b>			

NO.	DATE	BY	CHKD	ENGR	PROJ	DESCRIPTION
1	8-7-98	DJB	NW	MM	MM	ISSUED FOR AS-BUILT