

5

4

3

2

E

D




C

B

A

not be reproduced, copied, loaned, exhibited, or used in any other way, except by written consent from PARSONS to the borrower.

This document and the design it covers are the property of PARSONS. They are loaned only with the borrower's expressed written agreement that they will

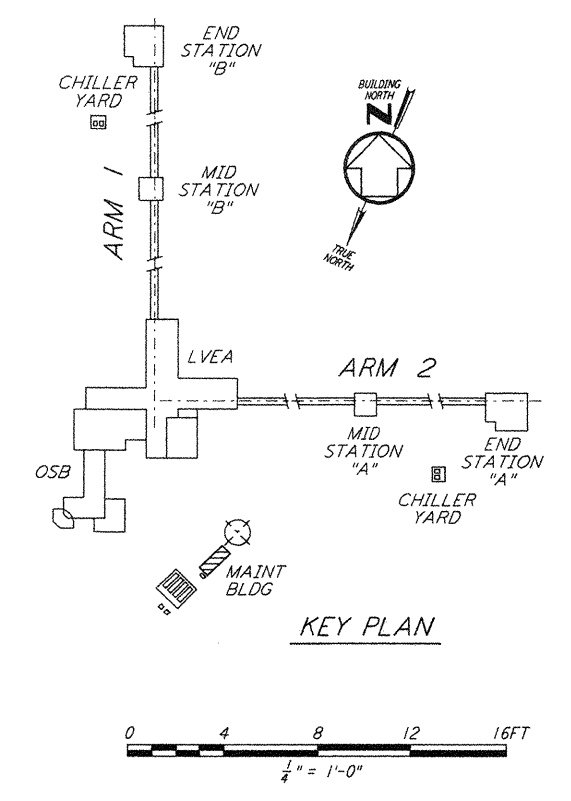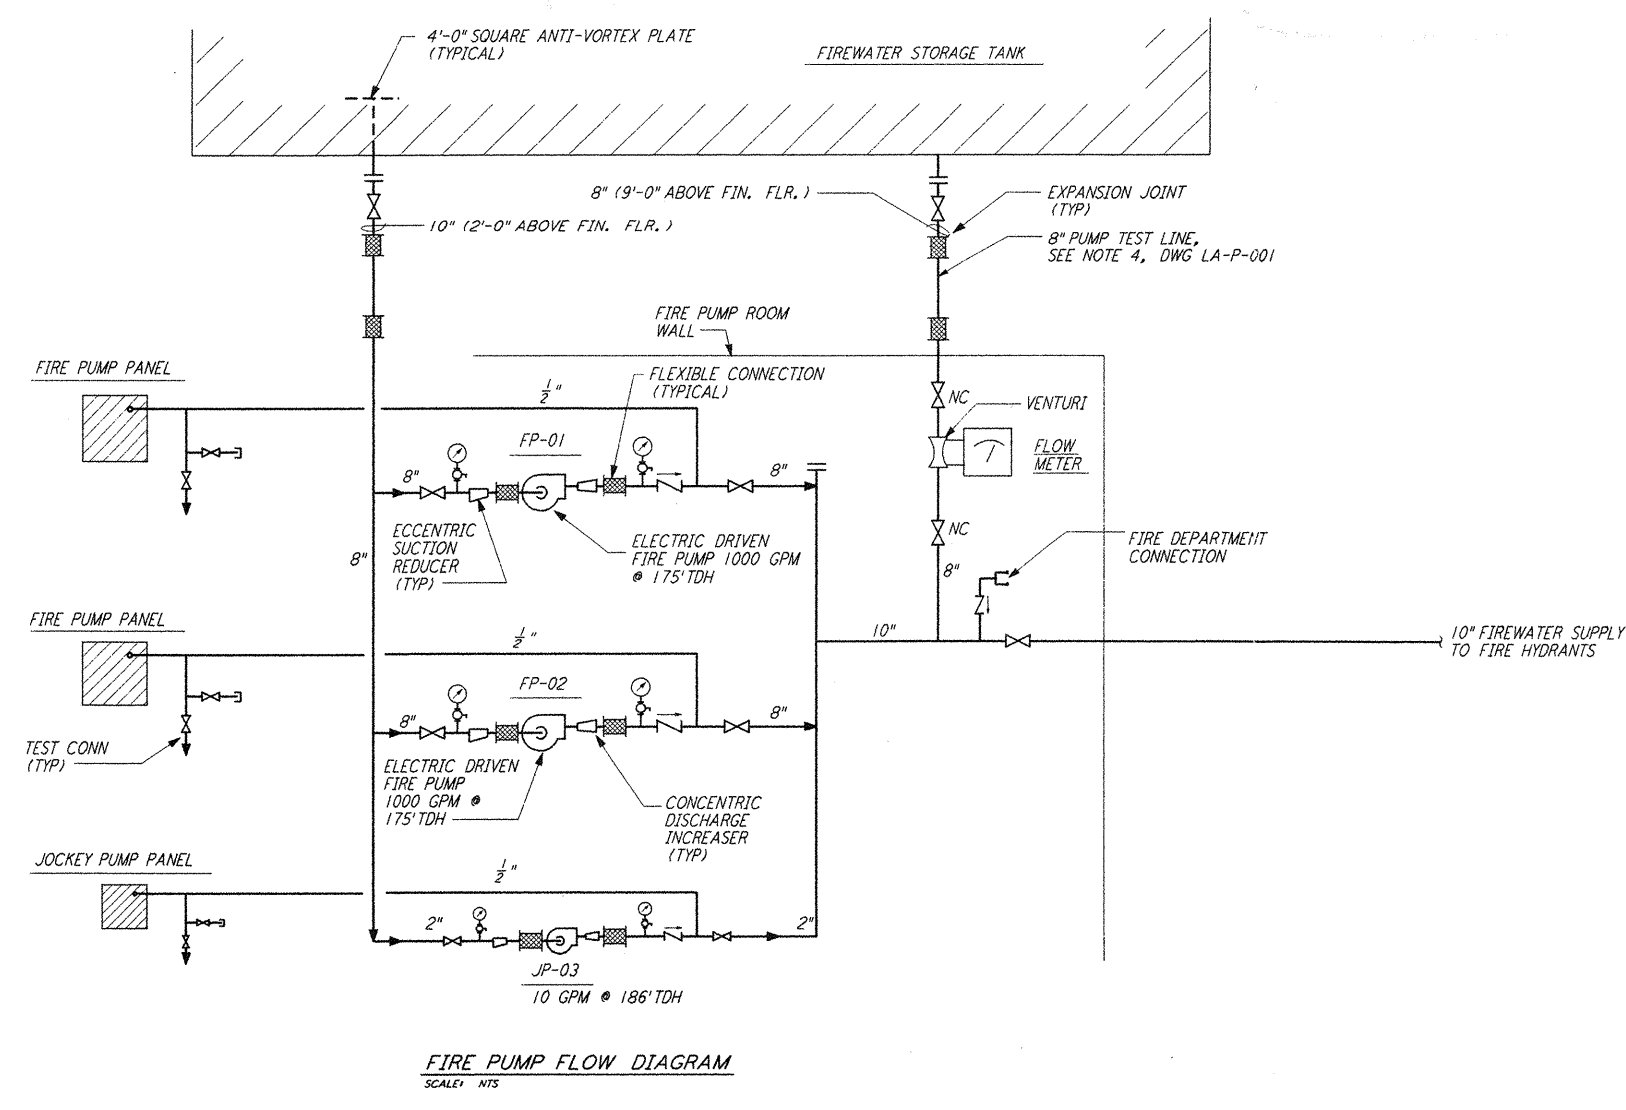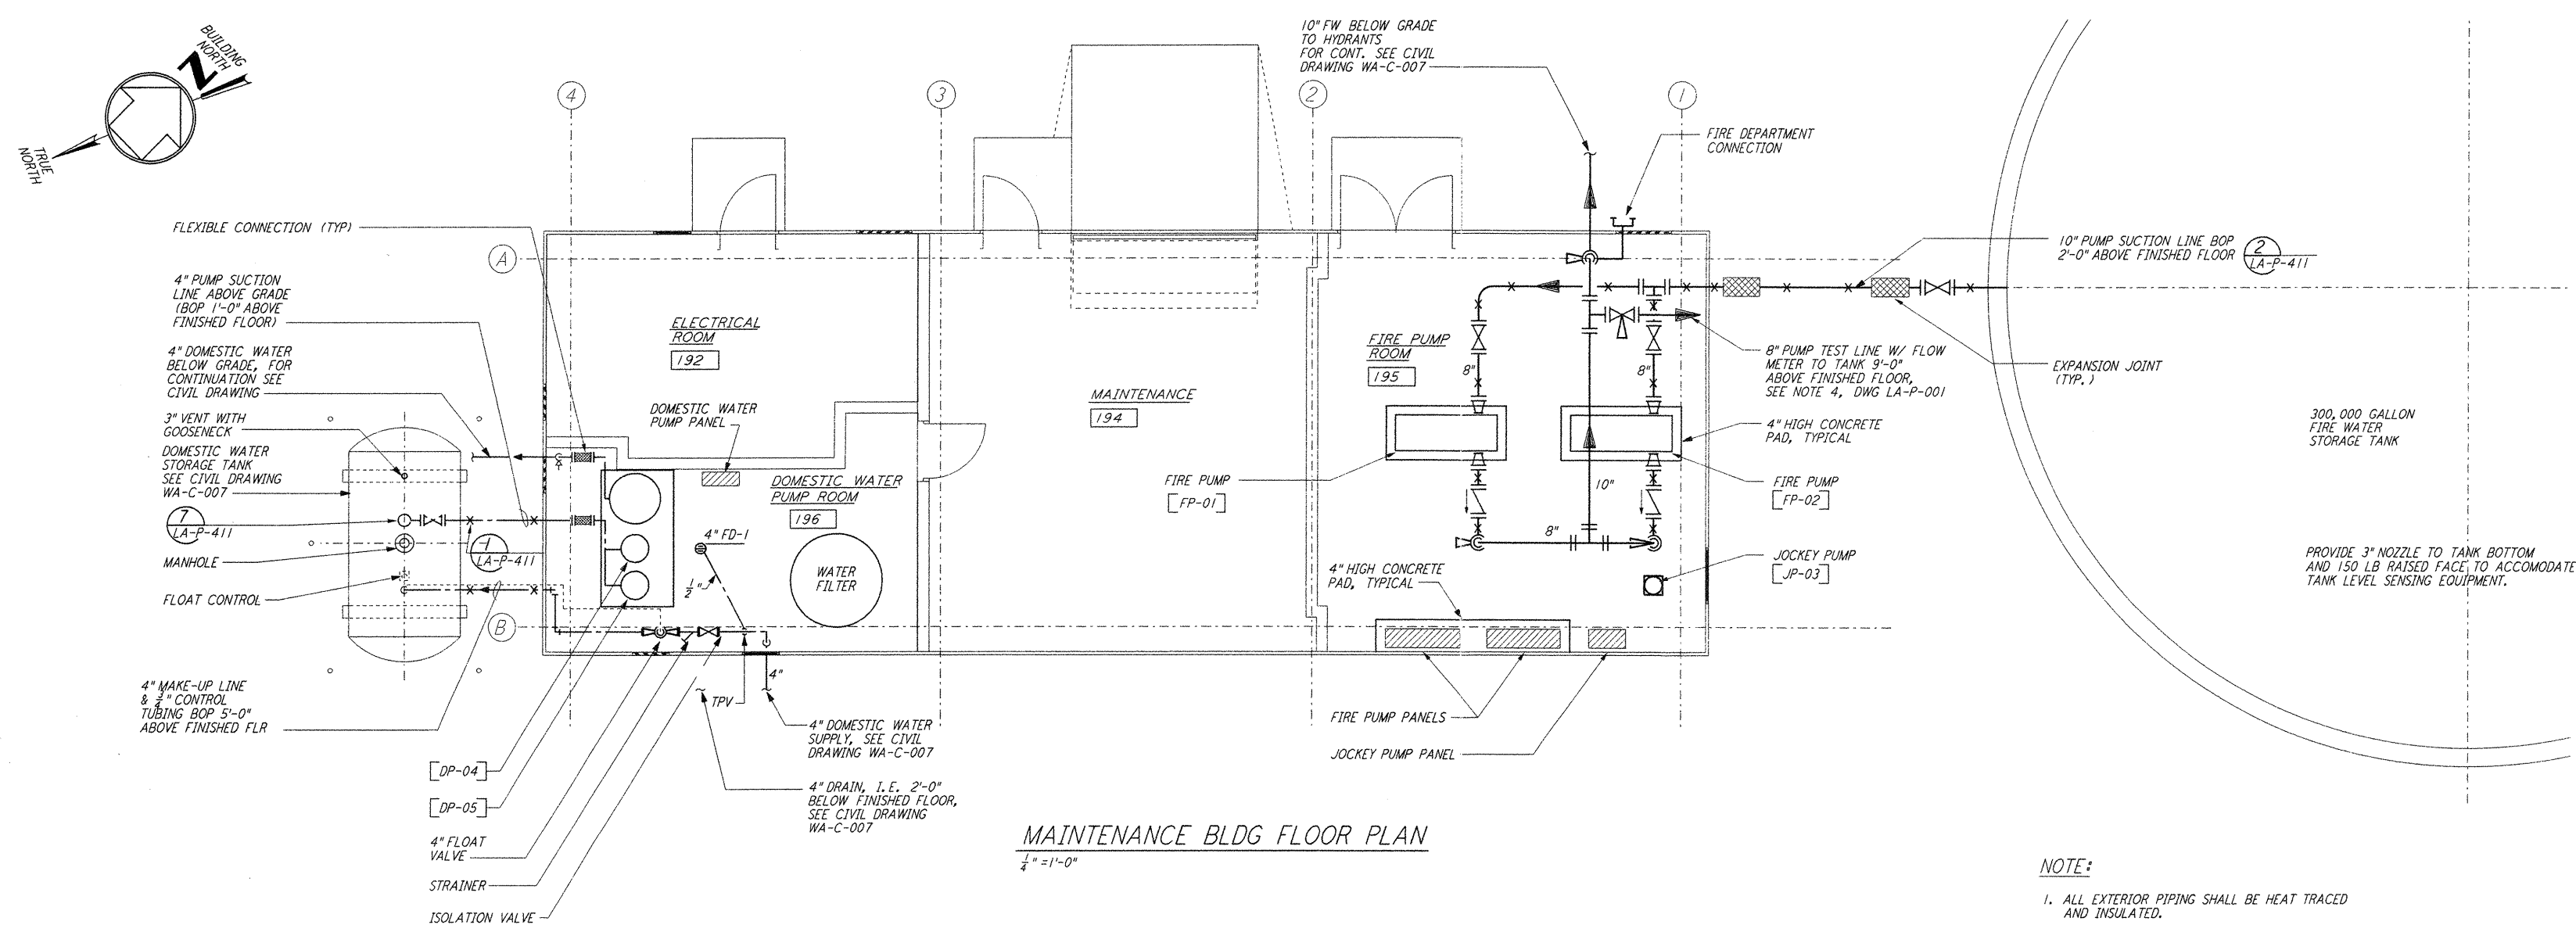

NO.	DATE	BY	CHKD	ENGR	PROJ	DESCRIPTION
1	8-7-98	DJB	WJ	WJ	WJ	ISSUED FOR AS-BUILT

ISSUED FOR CONSTRUCTION	
DRAWN	DG 11-15-96
CHECKED	ME 10-25-96
ENGINEER	AA 10-25-96
PROJ	TDM 11-15-96
AS-BUILT DRAWINGS	

PARSONS
 100 WEST WALNUT STREET
 PASADENA, CALIFORNIA

LIGO
 CALIFORNIA INSTITUTE OF TECHNOLOGY
 MASSACHUSETTS INSTITUTE OF TECHNOLOGY

LIGO-D961050-01-0
 LASER INTERFEROMETER
 GRAVITATIONAL-WAVE OBSERVATORY
 SITE NO. 2 - LIVINGSTON, LOUISIANA

TITLE: PLUMBING CORNER STATION MAINTENANCE BUILDING FLOOR PLAN & FLOW DIAGRAM
 SCALE: AS NOTED
 CONTRACT NUMBER: PP150969
 PROJECT NUMBER: 8094
 SHEET NUMBER: LA-P-113

5

4

3

2