




PIPE SUPPORT DETAIL (1) REF
 NTS LA-P-411

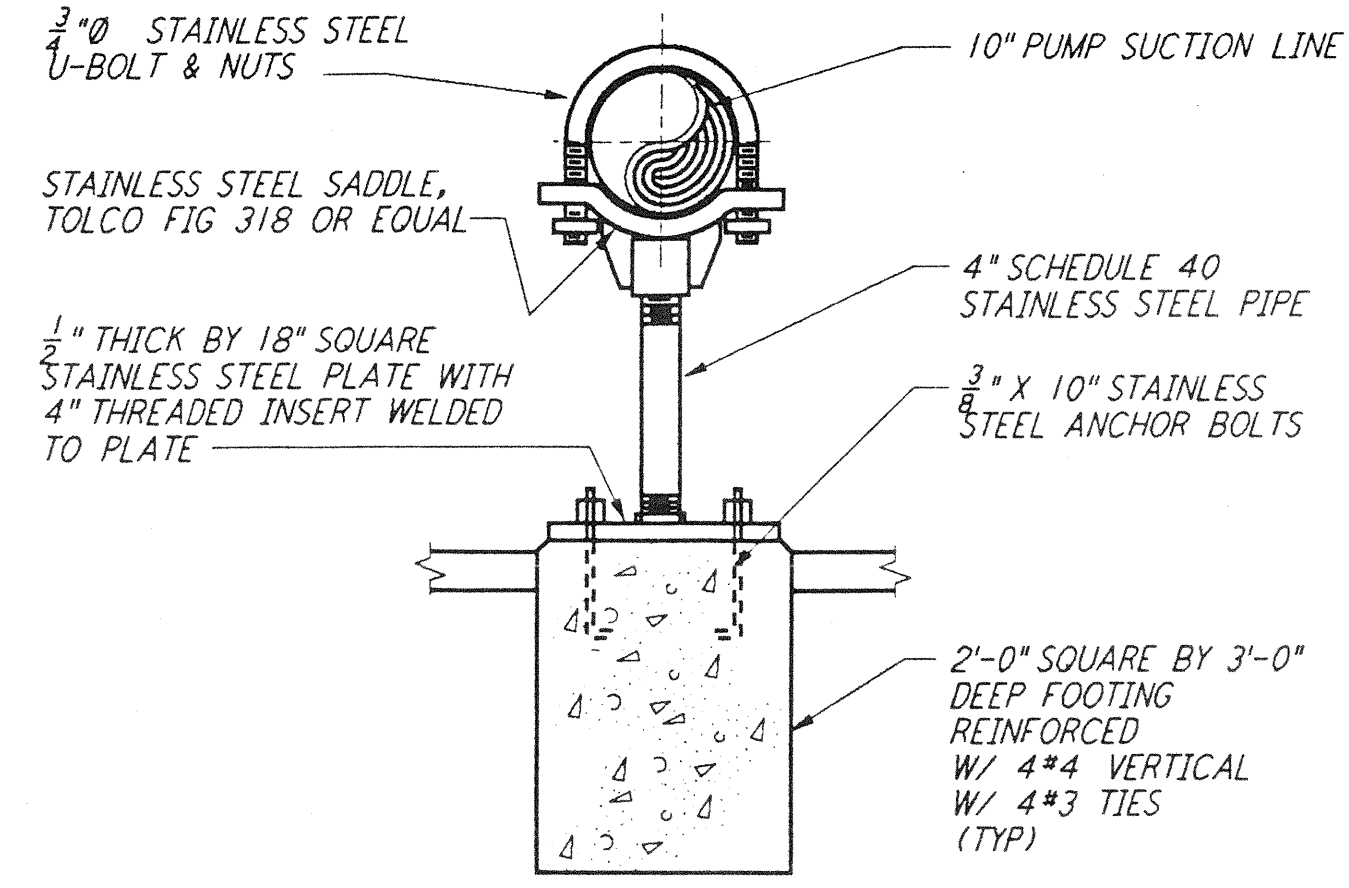


PIPE SUPPORT DETAIL (2) REF
 NTS LA-P-411

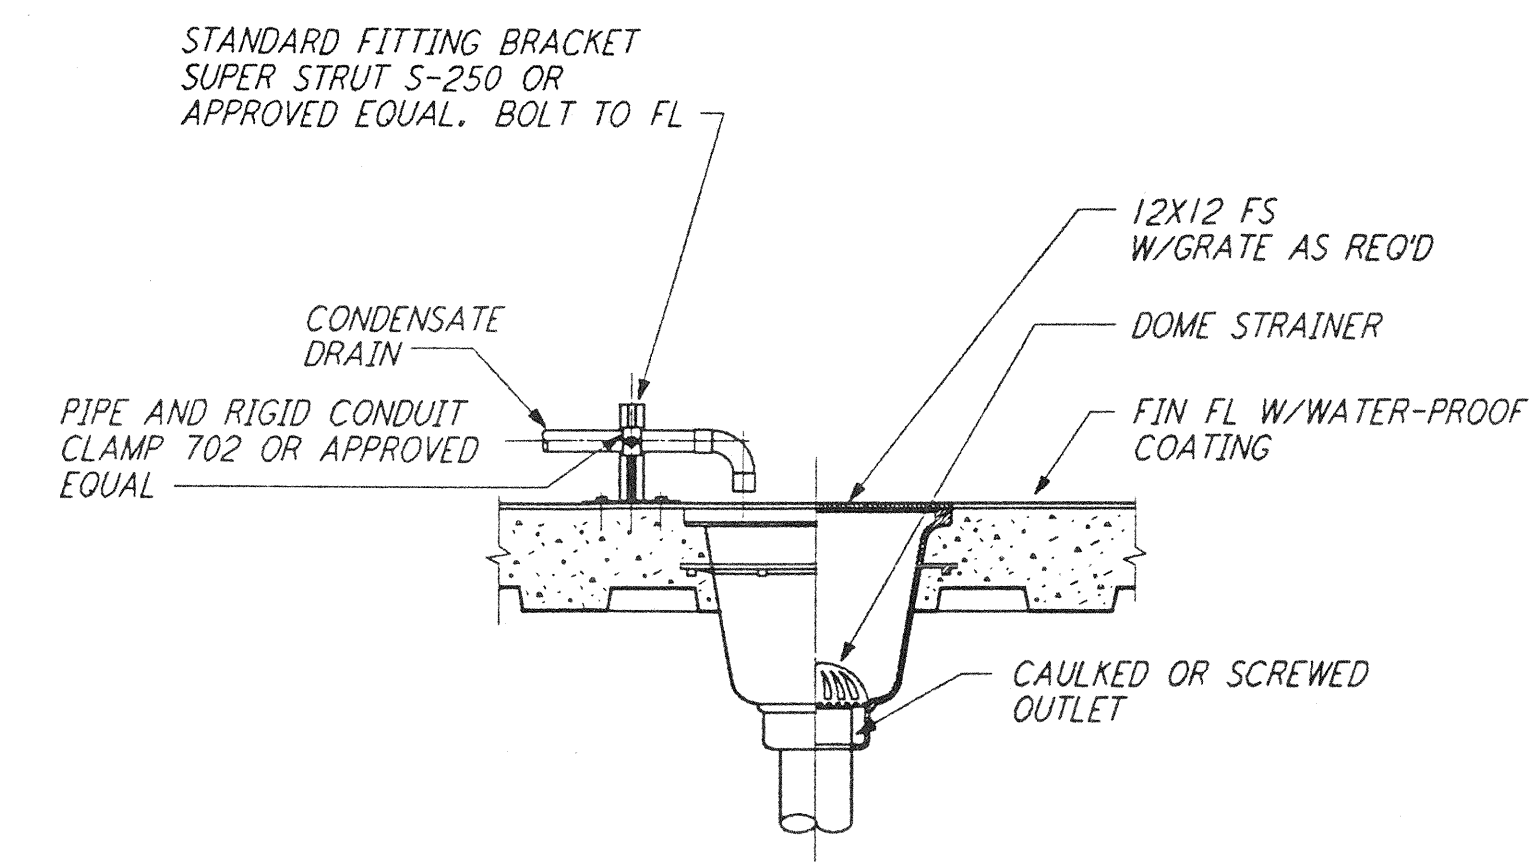


FLOOR SINK DETAIL (3) REF
 NTS LA-P-411

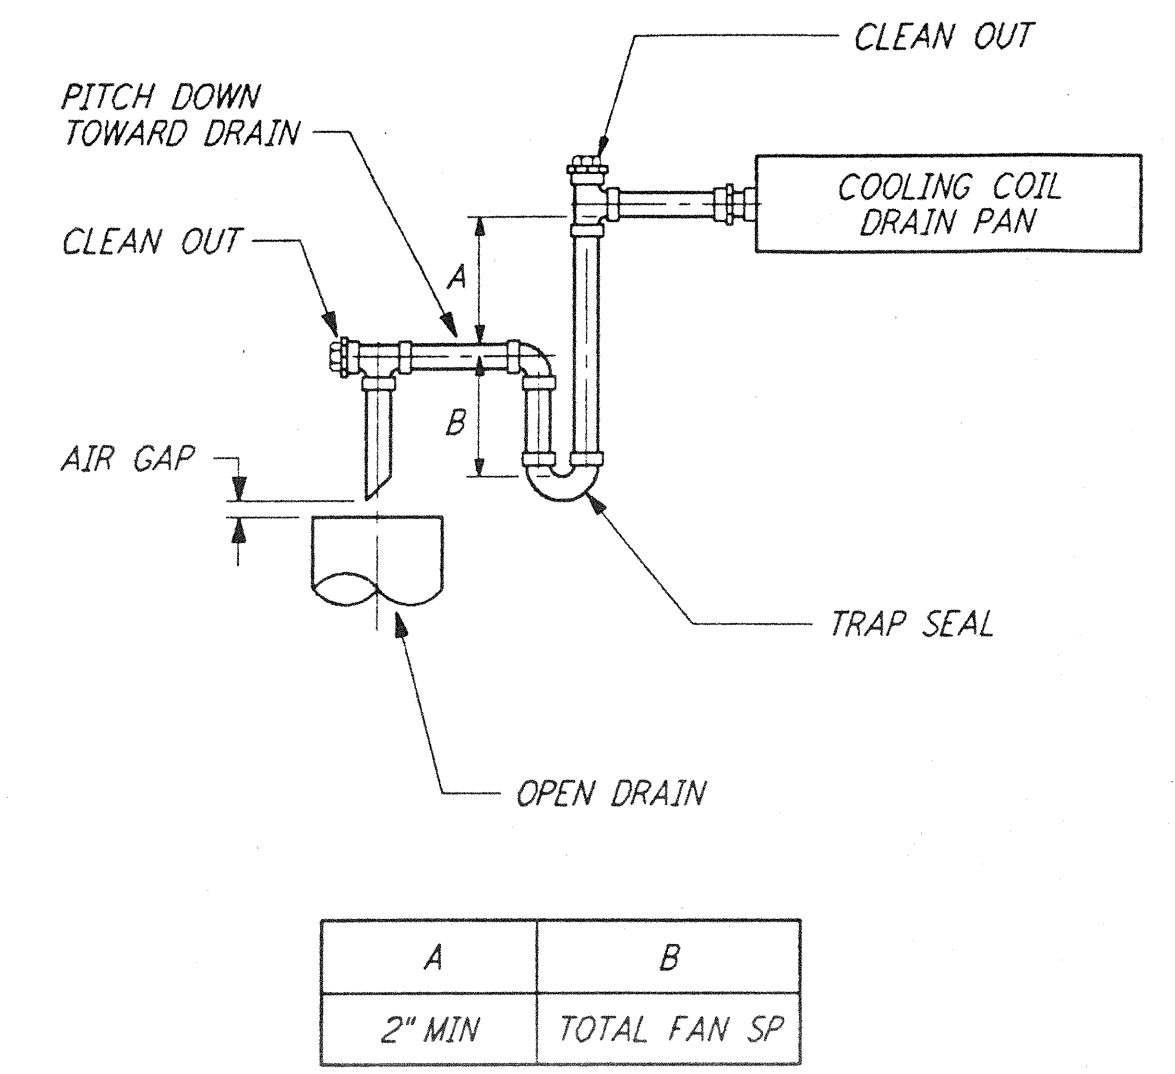


CONDENSATE DRAIN DETAIL (4) REF
 NTS LA-P-411

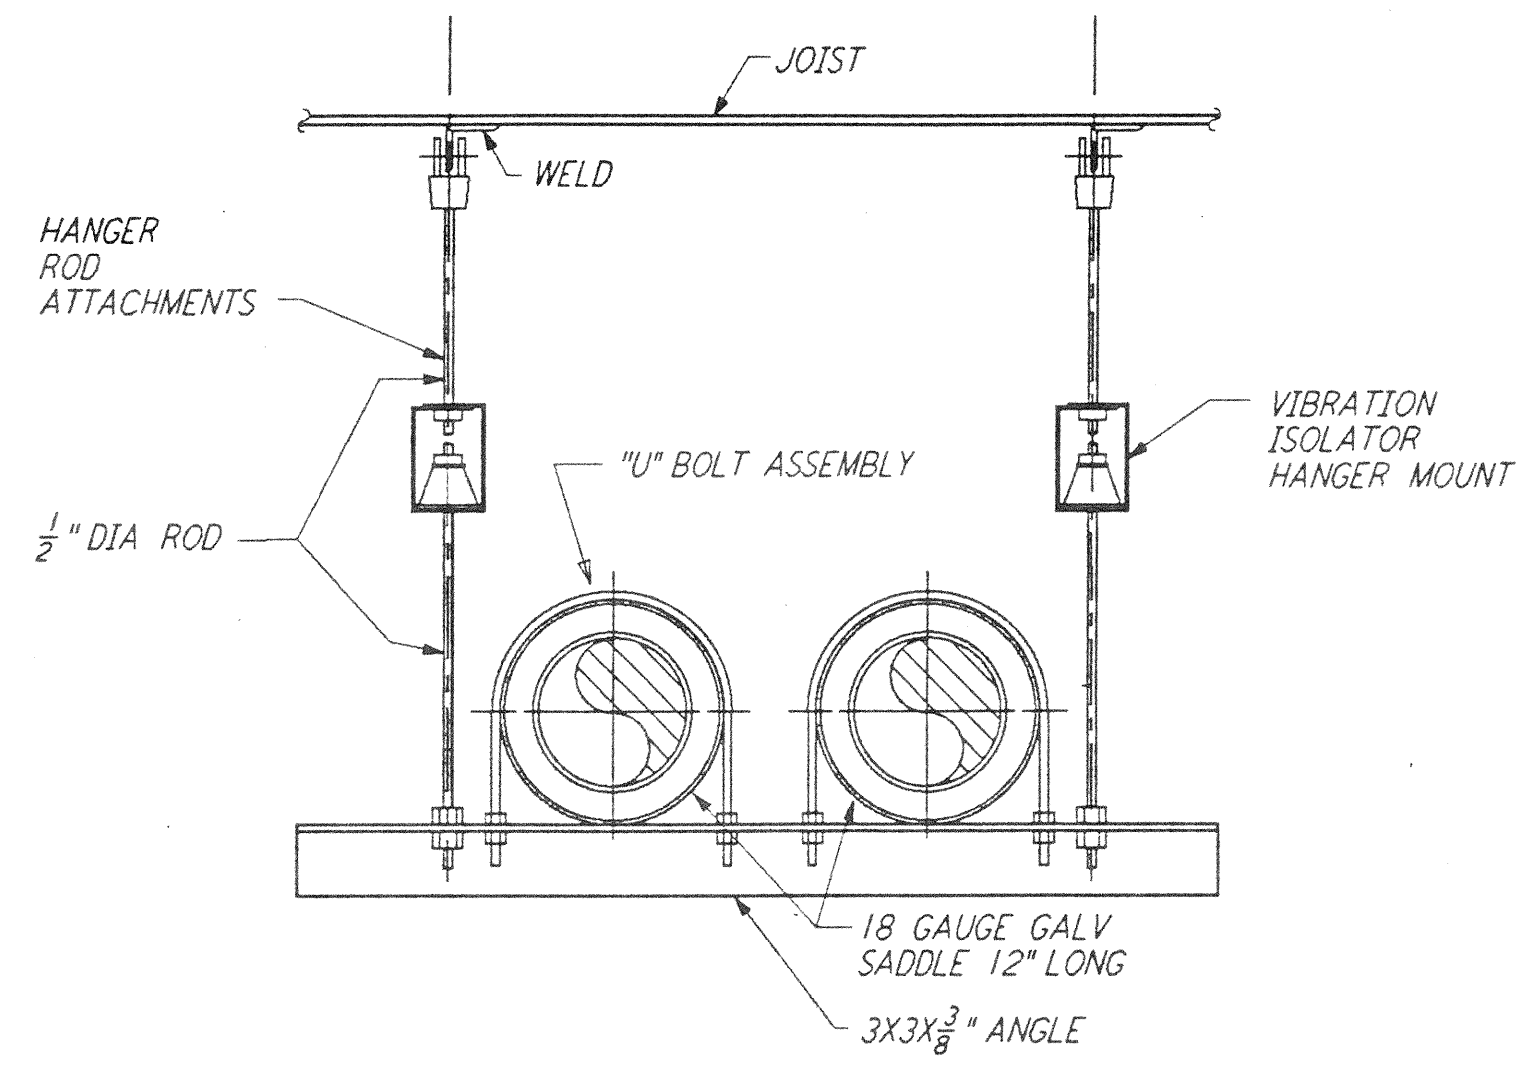


PIPE HANGER - TRAPEZE DETAIL (5) REF
 NTS LA-P-411

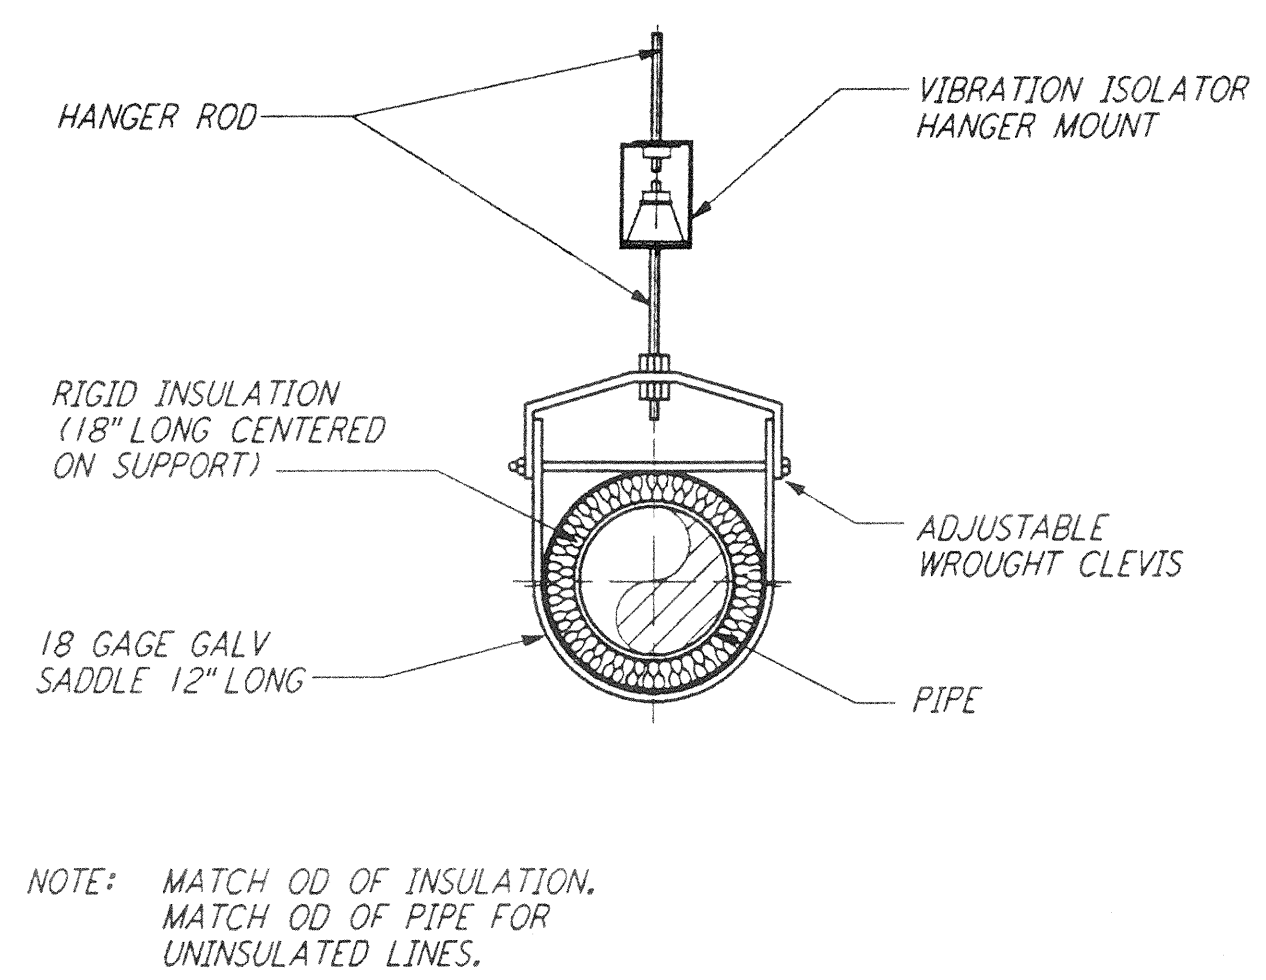

PIPE HANGER DETAIL - SINGLE PIPE (6) REF
 NTS LA-P-411

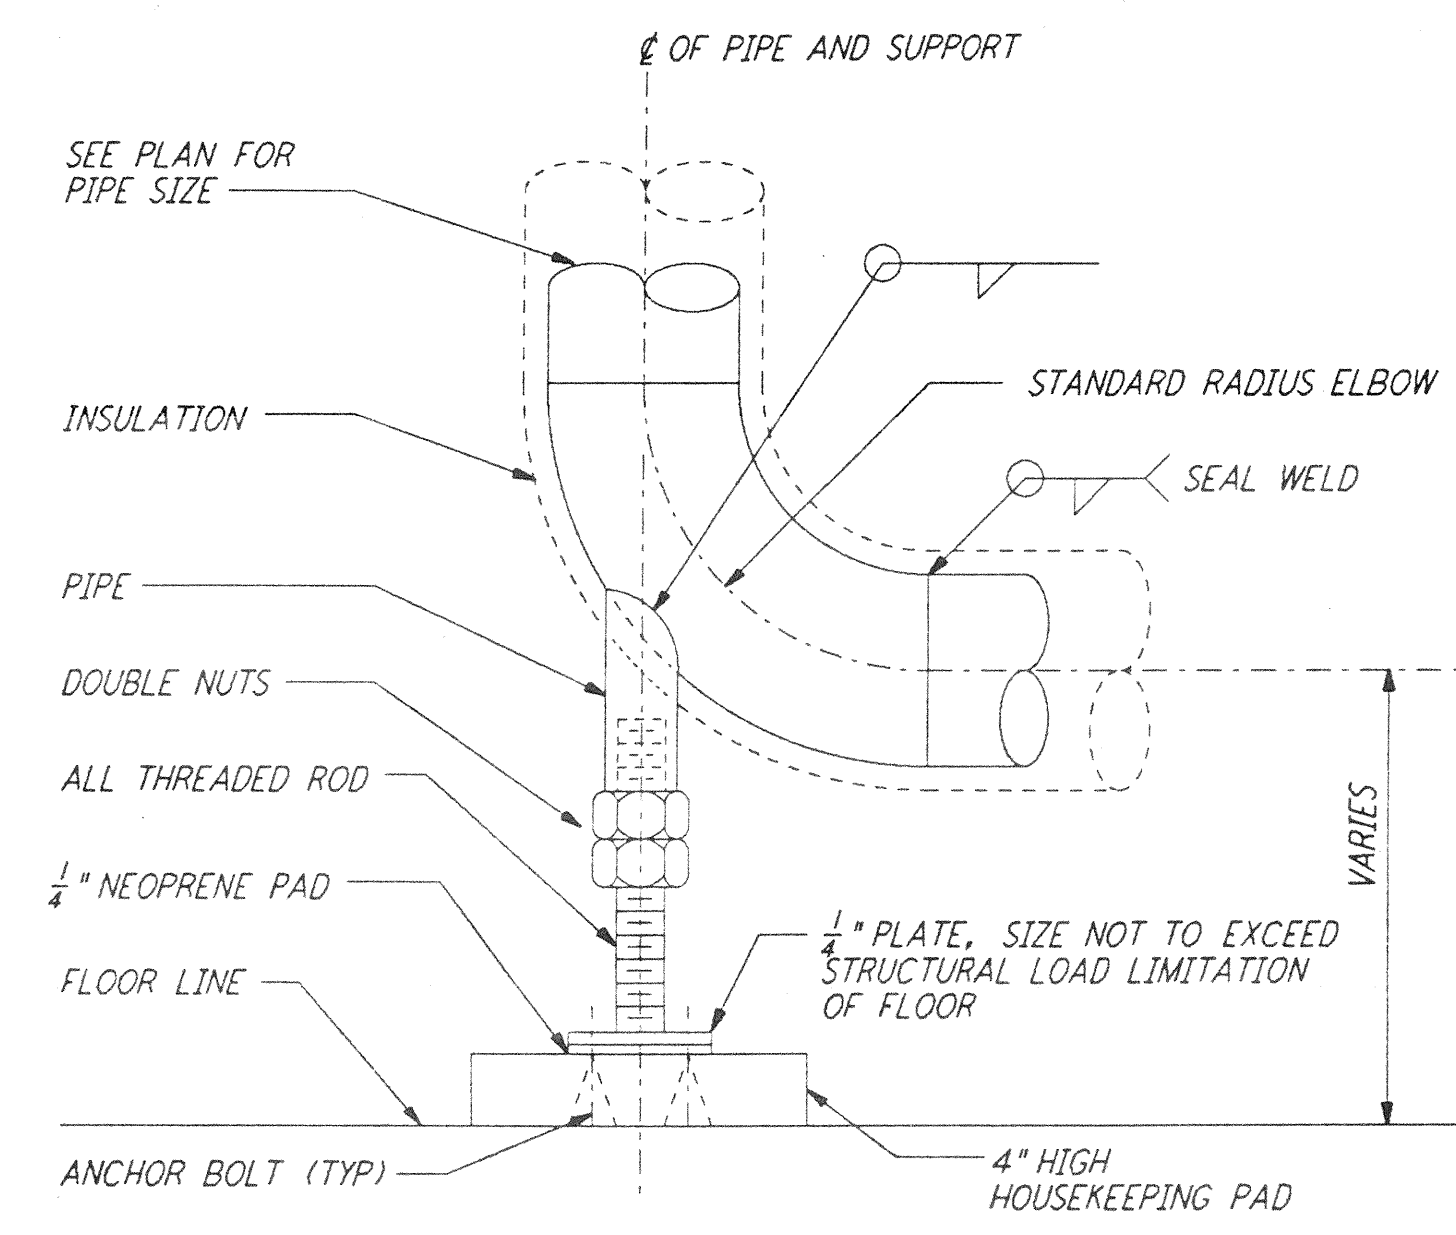

BASE ELBOW SUPPORT DETAIL (7) REF
 NTS LA-P-411

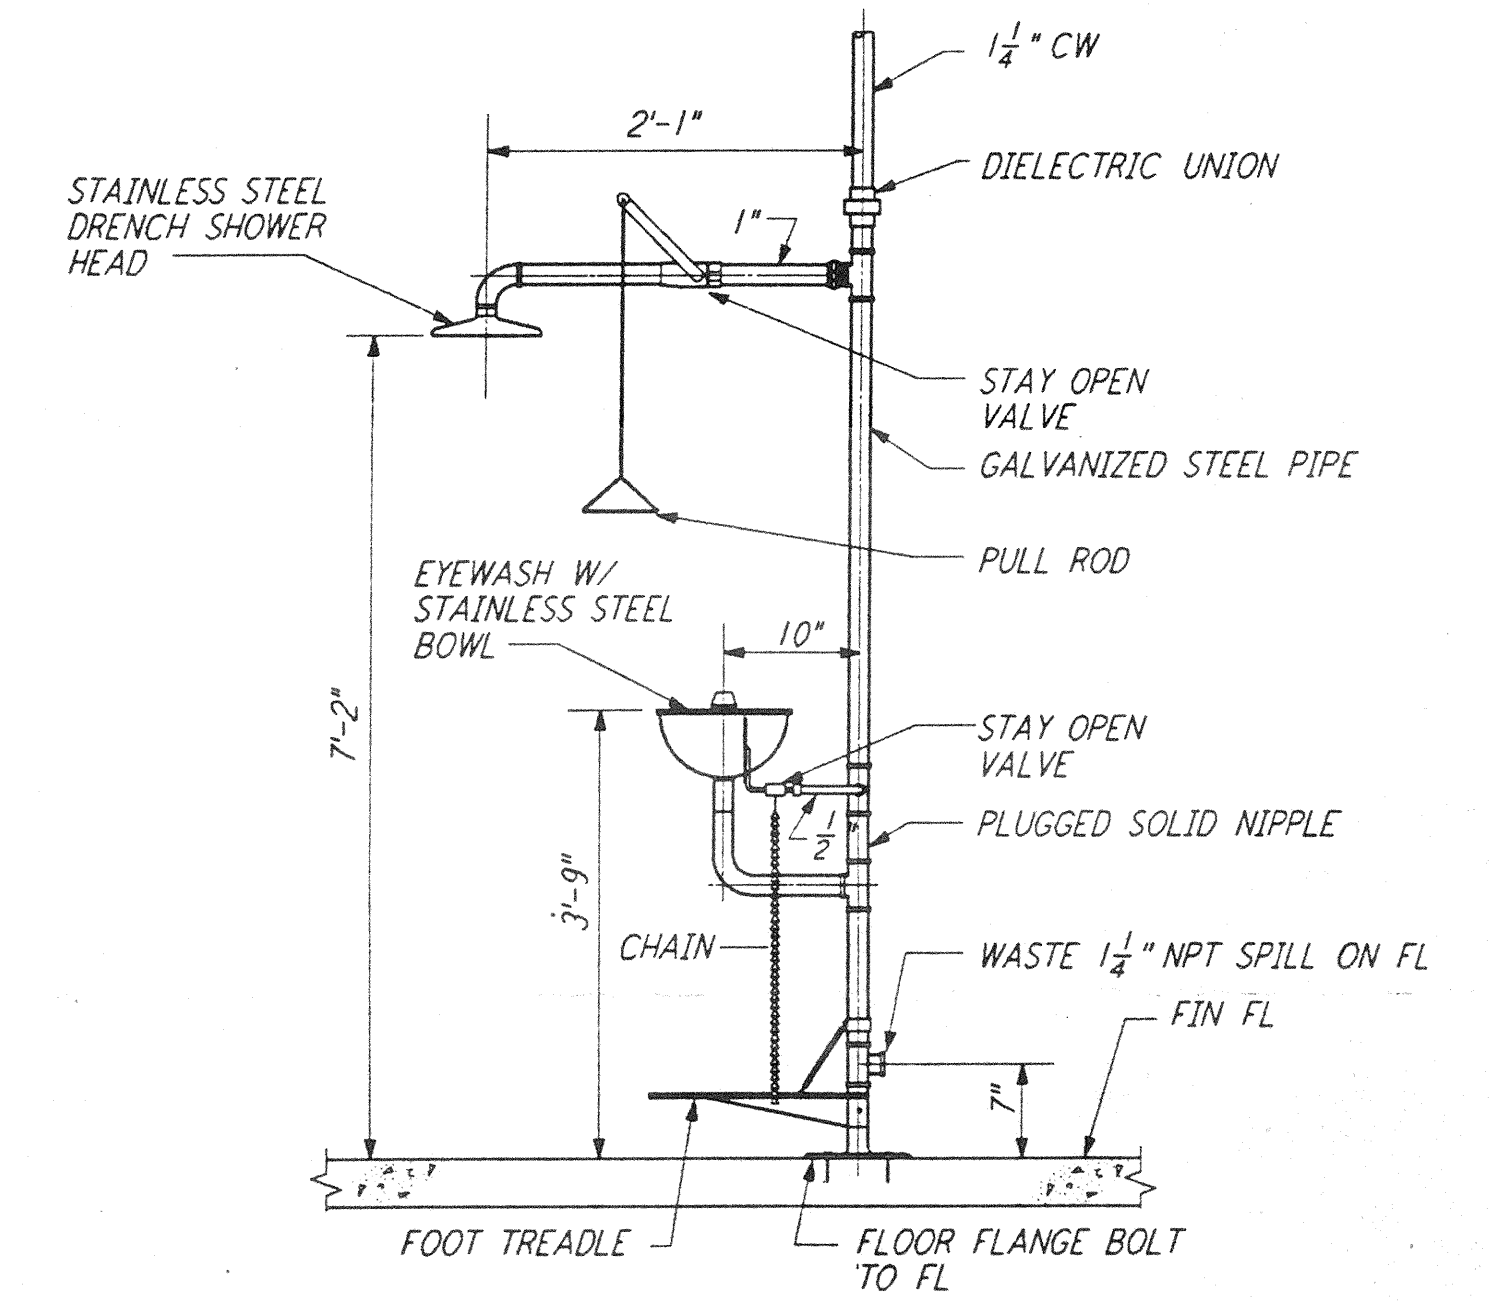


EMERGENCY SHOWER AND EYE WASH DETAIL (8) REF
 NTS LA-P-411

This document and the design it covers are the property of PARSONS. They are loaned only with the borrower's expressed written agreement that they will not be reproduced, copied, loaned, exhibited, or used in any other way, except by written consent from PARSONS to the borrower.

| NO. | DATE | BY | CHKD | ENGR | PROJ | DESCRIPTION |
|-----|------|----|------|------|------|-------------|
| | | | | | | |
| | | | | | | |
| | | | | | | |
| | | | | | | |

| | |
|-------------------------|---------------|
| ISSUED FOR CONSTRUCTION | |
| DRAWN | DG 11-15-96 |
| CHECKED | MFE 10-26-96 |
| ENGINEER | AA 10-23-96 |
| PROJ | BDPA 11/15/96 |

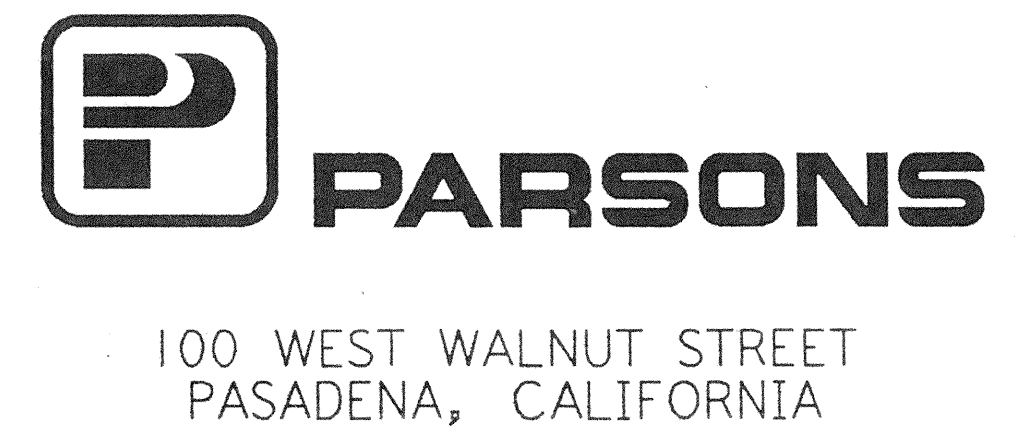

| | | | |
|--|-------|-----------------|----------------|
| LASER INTERFEROMETER GRAVITATIONAL-WAVE OBSERVATORY SITE NO. 2 - LIVINGSTON, LOUISIANA | | | |
| TITLE | SCALE | CONTRACT NUMBER | PROJECT NUMBER |
| PLUMBING DETAILS | NONE | PP150969 | 8094 |
| SHEET NUMBER | | REVISIONS | |
| LA-P-411 | | | |