



- NOTES:**
- 1) FOR GENERAL NOTES & LEGEND SEE PSI DWG. #V049-3-001 SHT. 1.
 - 2) FOR LIST OF CIVIL CONTRACTORS REFERENCE DWGS. WITH CURRENT REVISIONS SEE PSI DWG. #V049-3-001 SHT. 2.
 - 3) GROUND GRID IS BY OTHERS.
 - 4) TIE GROUNDING CONDUCTOR TO EXISTING GROUND GRID. SEE PARSONS DWG. #VA-E-202.
 - 5) GROUND VENT PIPE SUPPORT TO EXISTING GROUND GRID. SEE PARSONS DWG. #VA-E-202.

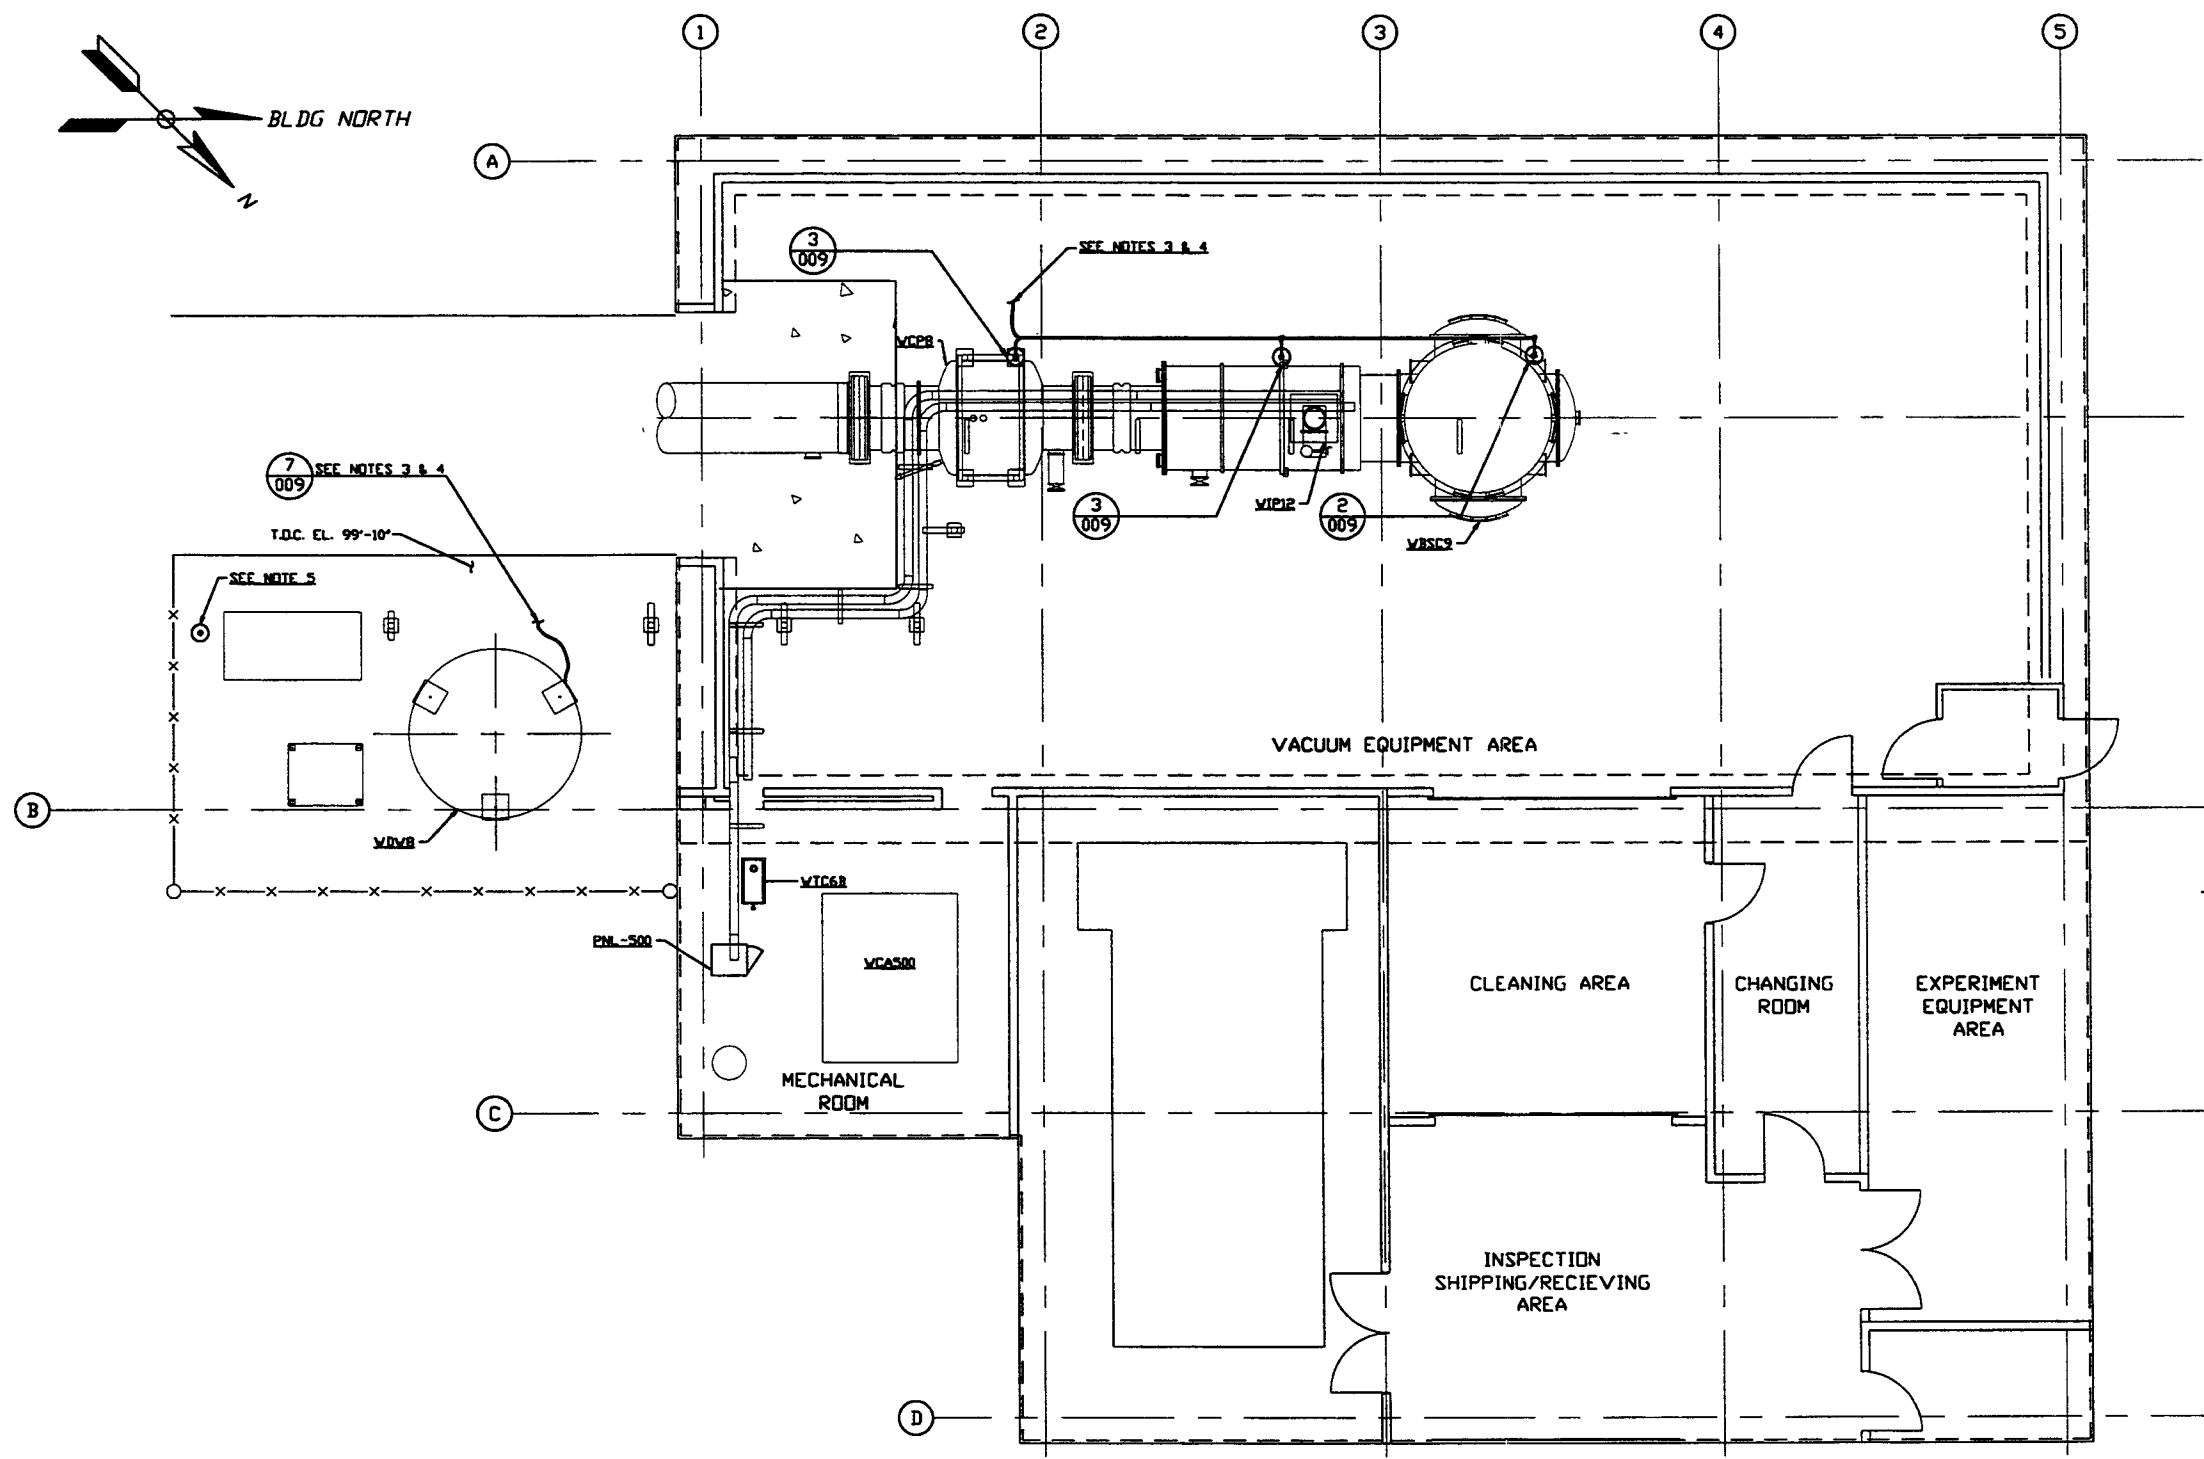

RIGHT END STATION PLAN @ EL. 100'-0"

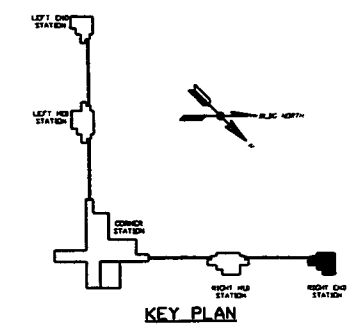

PROPRIETARY AND CONFIDENTIAL
 THIS DOCUMENT CONTAINS PROPRIETARY INFORMATION BELONGING TO PROCESS SYSTEMS INTERNATIONAL, INC. OR ITS AFFILIATED COMPANIES AND SHALL BE USED ONLY FOR THE PURPOSE FOR WHICH IT WAS SUPPLIED. IT SHALL NOT BE COPIED, REPRODUCED OR OTHERWISE USED, FOR ANY OTHER PURPOSE, WITHOUT THE WRITTEN CONSENT OF PROCESS SYSTEMS INTERNATIONAL, INC. AND SHALL BE RETURNED UPON REQUEST.

DWG. NO.	DESCRIPTION	REFERENCE DRAWINGS
V049-3-502	CABLE TRAY PLAN RIGHT END STATION	
V049-3-009	GROUNDING DETAILS	
V049-3-002	OVERALL SITE PLAN WASHINGTON	
V049-3-001	GENERAL NOTES & LEGEND	

REV	DESCRIPTION	ISSUE DESCRIPTION	CHKD	DRWN	DATE	DEDR
1	ISSUE FOR CONSTRUCTION				05.12.97	0480
0	ISSUE FOR FOR UPDATE & BID				11.25.96	0355

PROCESS SYSTEMS INTERNATIONAL, INC.
 20 WALSH DR. WESTBOROUGH, MASSACHUSETTS 01581 USA

GROUNDING PLAN
 LIGO VACUUM EQUIPMENT
 WASHINGTON SITE
 RIGHT END STATION

CAB FILE: V0493509
 SHEET: D
 DWG. NO.: V049-3-509
 SCALE: 3/16" = 1' - 0"
 SHEET: 1 OF 1