



NOTES:

- 1.) FOR GENERAL NOTES & LEGEND SEE PSI DWG. #V049-3-001 SHT. 1.
- 2.) FOR LIST OF CIVIL CONTRACTORS REFERENCE DWGS. WITH CURRENT REVISIONS SEE PSI DWG. #V049-3-001 SHT. 2.
- 3.) GROUND GRID IS BY OTHERS.
- 4.) TIE GROUNDING CONDUCTOR TO EXISTING GROUND GRID. SEE PARSONS DWG. #VA-E-506.
- 5.) GROUND VENT PIPE SUPPORT TO EXISTING GROUND GRID. SEE PARSONS DWG. #VA-E-506.

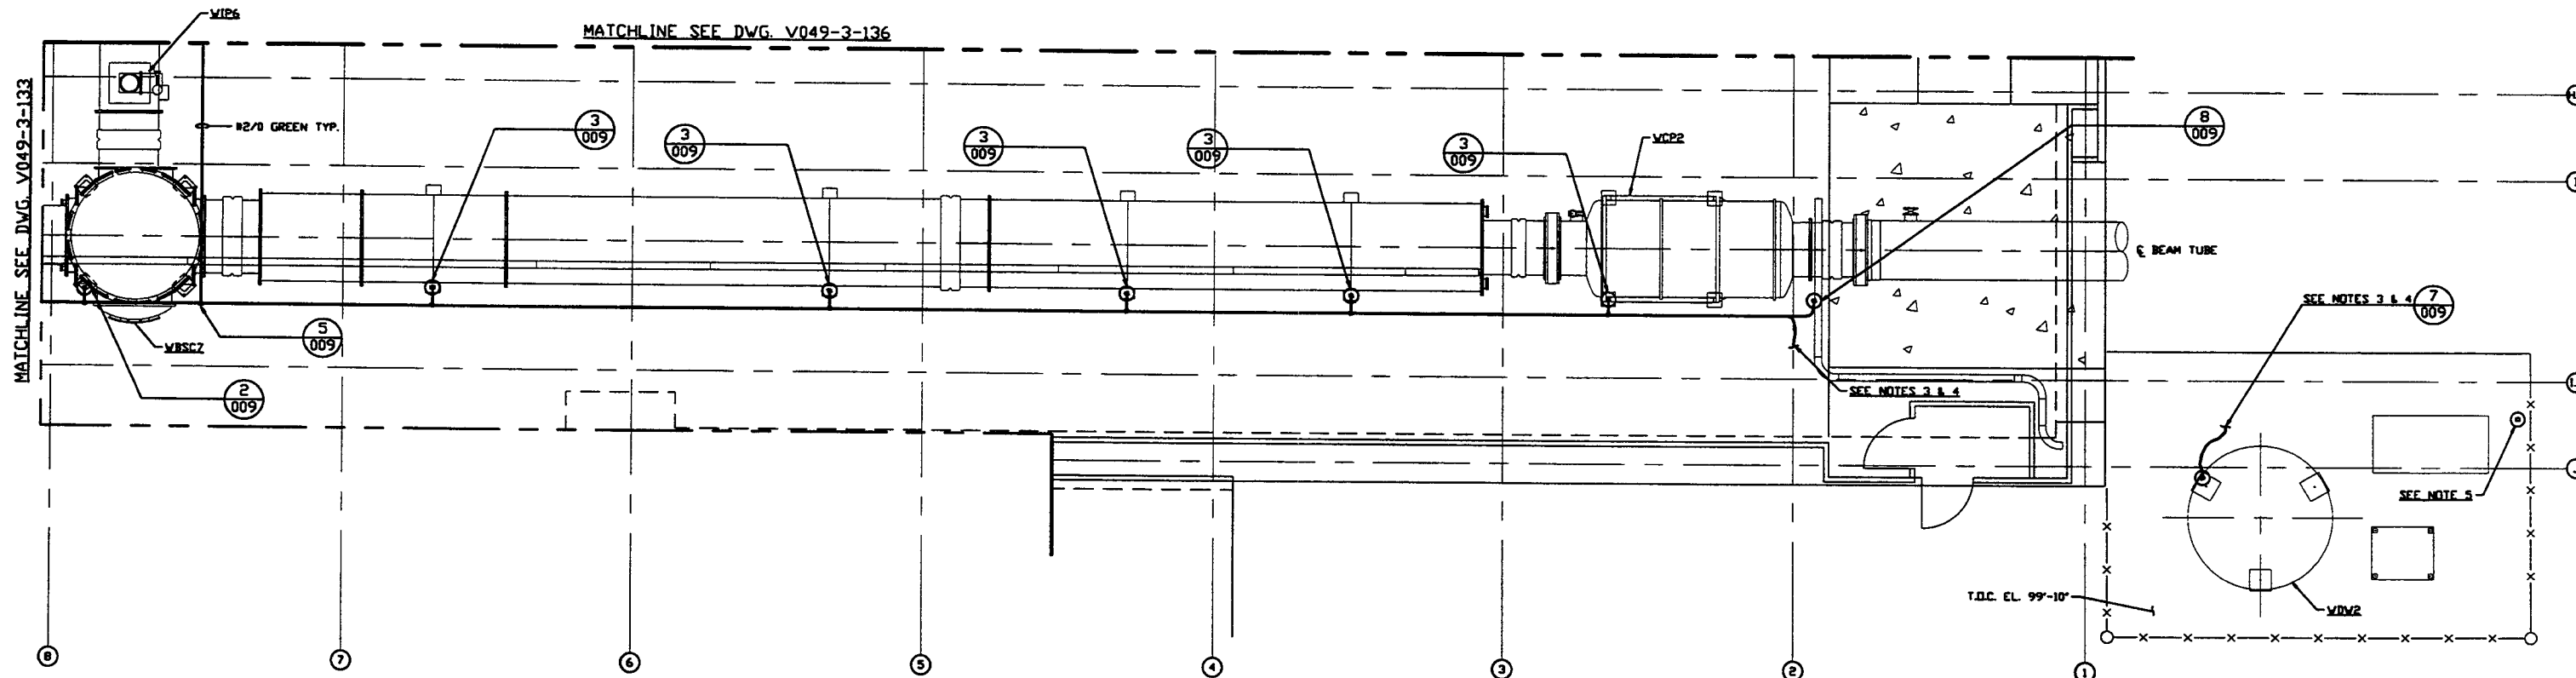

RIGHT BEAM MANIFOLD PLAN @ EL. 100'-0"

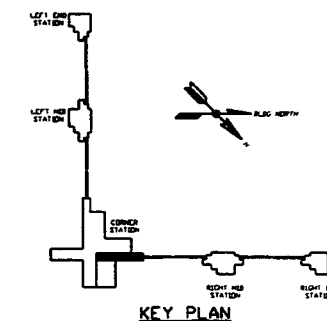

PROPRIETARY AND CONFIDENTIAL
THIS DOCUMENT CONTAINS PROPRIETARY INFORMATION BELONGING TO PROCESS SYSTEMS INTERNATIONAL, INC. OR ITS AFFILIATED COMPANIES AND SHALL BE USED ONLY FOR THE PURPOSE FOR WHICH IT WAS SUPPLIED. IT SHALL NOT BE COPIED, REPRODUCED OR OTHERWISE USED, NOR SHALL SUCH INFORMATION BE FURNISHED IN WHOLE OR IN PART TO OTHERS EXCEPT IN ACCORDANCE WITH THE TERMS OF ANY AGREEMENT UNDER WHICH IT WAS SUPPLIED OR WITH THE PRIOR WRITTEN CONSENT OF PROCESS SYSTEMS INTERNATIONAL, INC. AND SHALL BE RETURNED UPON REQUEST.

DWG. NO.	DESCRIPTION	DWG. NO.	DESCRIPTION
V049-3-136	GROUNDING PLAN WASHINGTON DIAGONAL SECTION		
V049-3-133	GROUNDING PLAN WASHINGTON VERTEX SECTION		
V049-3-108	CABLE TRAY PLAN WASHINGTON RIGHT BEAM MANIFOLD		
V049-3-009	GROUNDING DETAILS		
V049-3-002	WASHINGTON OVERALL SITE PLAN		
V049-3-001	GENERAL NOTES & LEGEND		

REV	DESCRIPTION	CHKD	DRWN	DATE	DEDR
1	ISSUE FOR CONSTRUCTION			05.12.97	0480
0	ISSUE FOR FOR UPDATE & BID			11.25.96	0355

PROCESS SYSTEMS INTERNATIONAL, INC.
20 WALDEP DR. WESTBOROUGH, MASSACHUSETTS 01581 USA

**GROUNDING PLAN
LIGO VACUUM EQUIPMENT
WASHINGTON SITE
RIGHT BEAM MANIFOLD**

CAD FILE: V0493135
SIZE: D
DWG. NO.: V049-3-135
REV: 1

SCALE: 3/16" = 1' - 0"
SHEET: 1 OF 1