



NOTES

- FOR JOINT TYPES SEE S-203
 IJ = ISOLATION JOINT
 EXJ = EXPANSION JOINT
 CJ = CONTROL JOINT
- CONTRACTOR TO PROPOSE CONSTRUCTION JOINT LOCATIONS TO ENGINEER OF RECORD FOR APPROVAL.

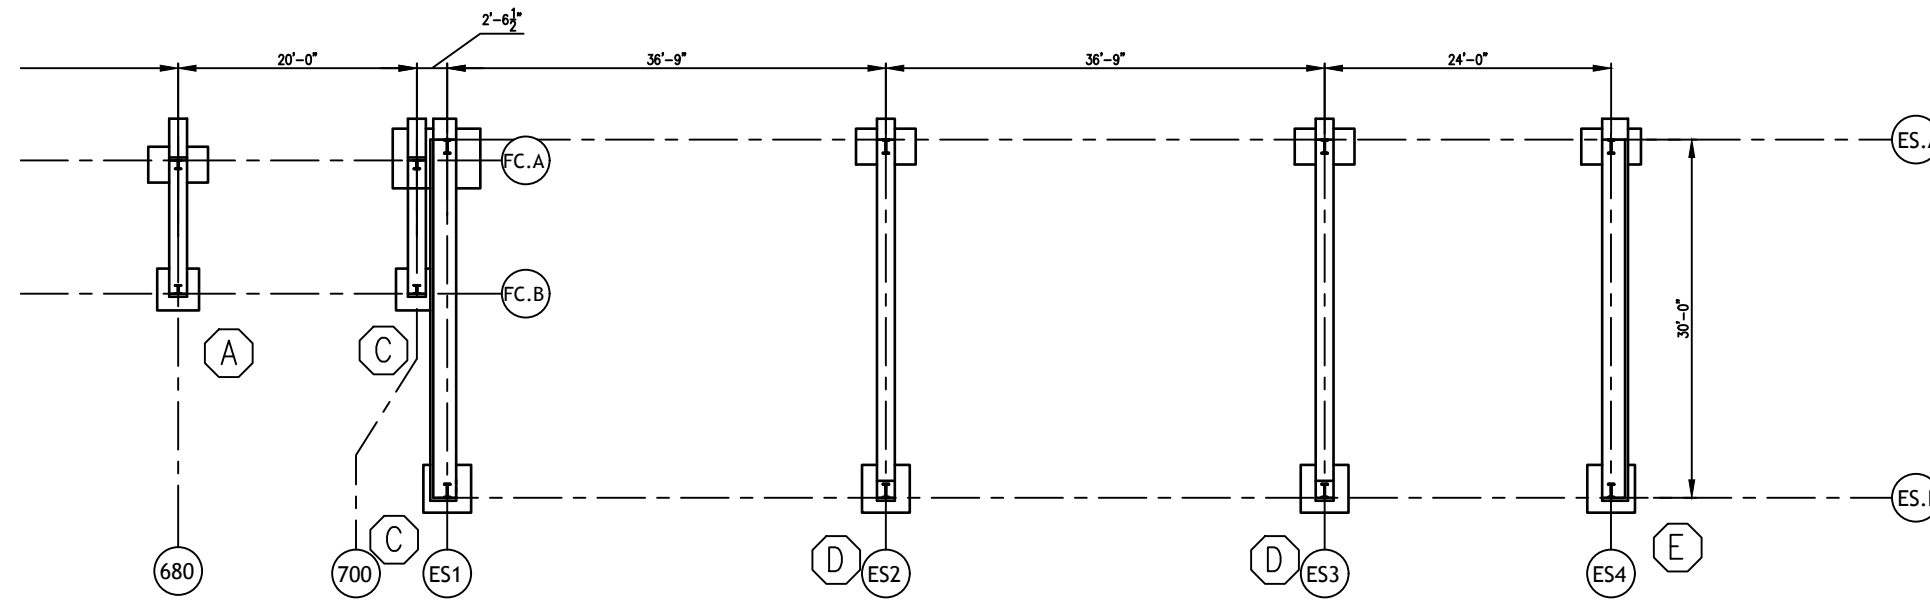

1 FCES - FOUNDATION PLAN
 S100 1/8" = 1'-0"

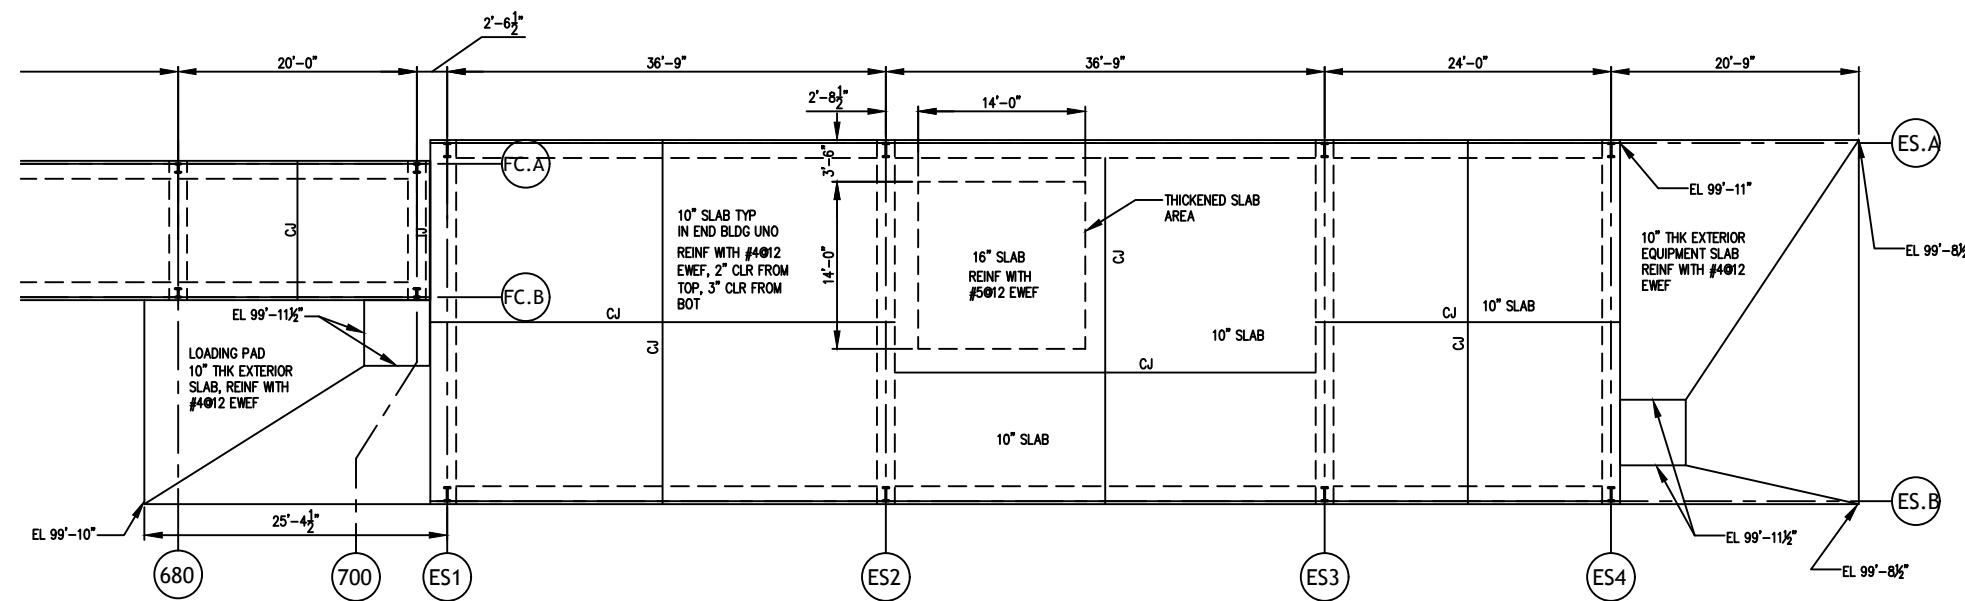

1 FCES - SLAB PLAN
 S100 1/8" = 1'-0"

LIGO-D2100345-v1

D DANA ENGINEERING, INC.
 PROFESSIONAL SERVICE CORPORATION

4000 SOUTH IRBY STREET
 KENNEWICK, WA 99337
 (509) 582-0126

Revisions		
No.	Description	Date

LIGO Laboratory A+ Project
 Hanford, WA

FILTER CAVITY END STATION (FCES) FOUNDATION AND SLAB PLAN

	project number	21262.00	drawing number	S102
	date	01.13.21		
	phase	CONSTRUCTION		